



**1** MECHANICAL PLAN - ATTIC  
 3/16" = 1'-0"

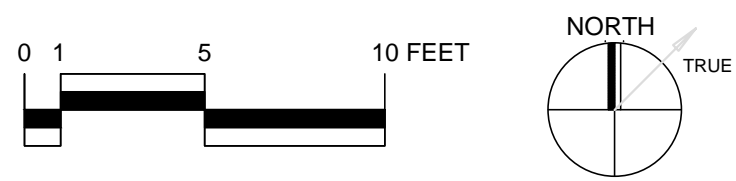

**SCATTERGOOD DESIGN**  
 architecture + planning  
 80 middle street  
 portland, maine 04101  
 207-775-6141  
 scattergooddesign.com

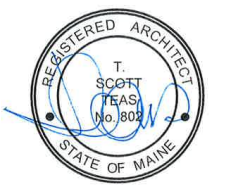

90 MORNING STREET, PORTLAND, ME

MECHANICAL PLAN - ATTIC LEVEL

scale	1/8" = 1'-0"	title	
date	JAN 10 2016	drawn by	PWH / TST
project #	1304	checked by	

**M 1.0**