


**NOTE:**  
Buildings B, C & D are similar to Building A, refer to Architectural drawings for more information.

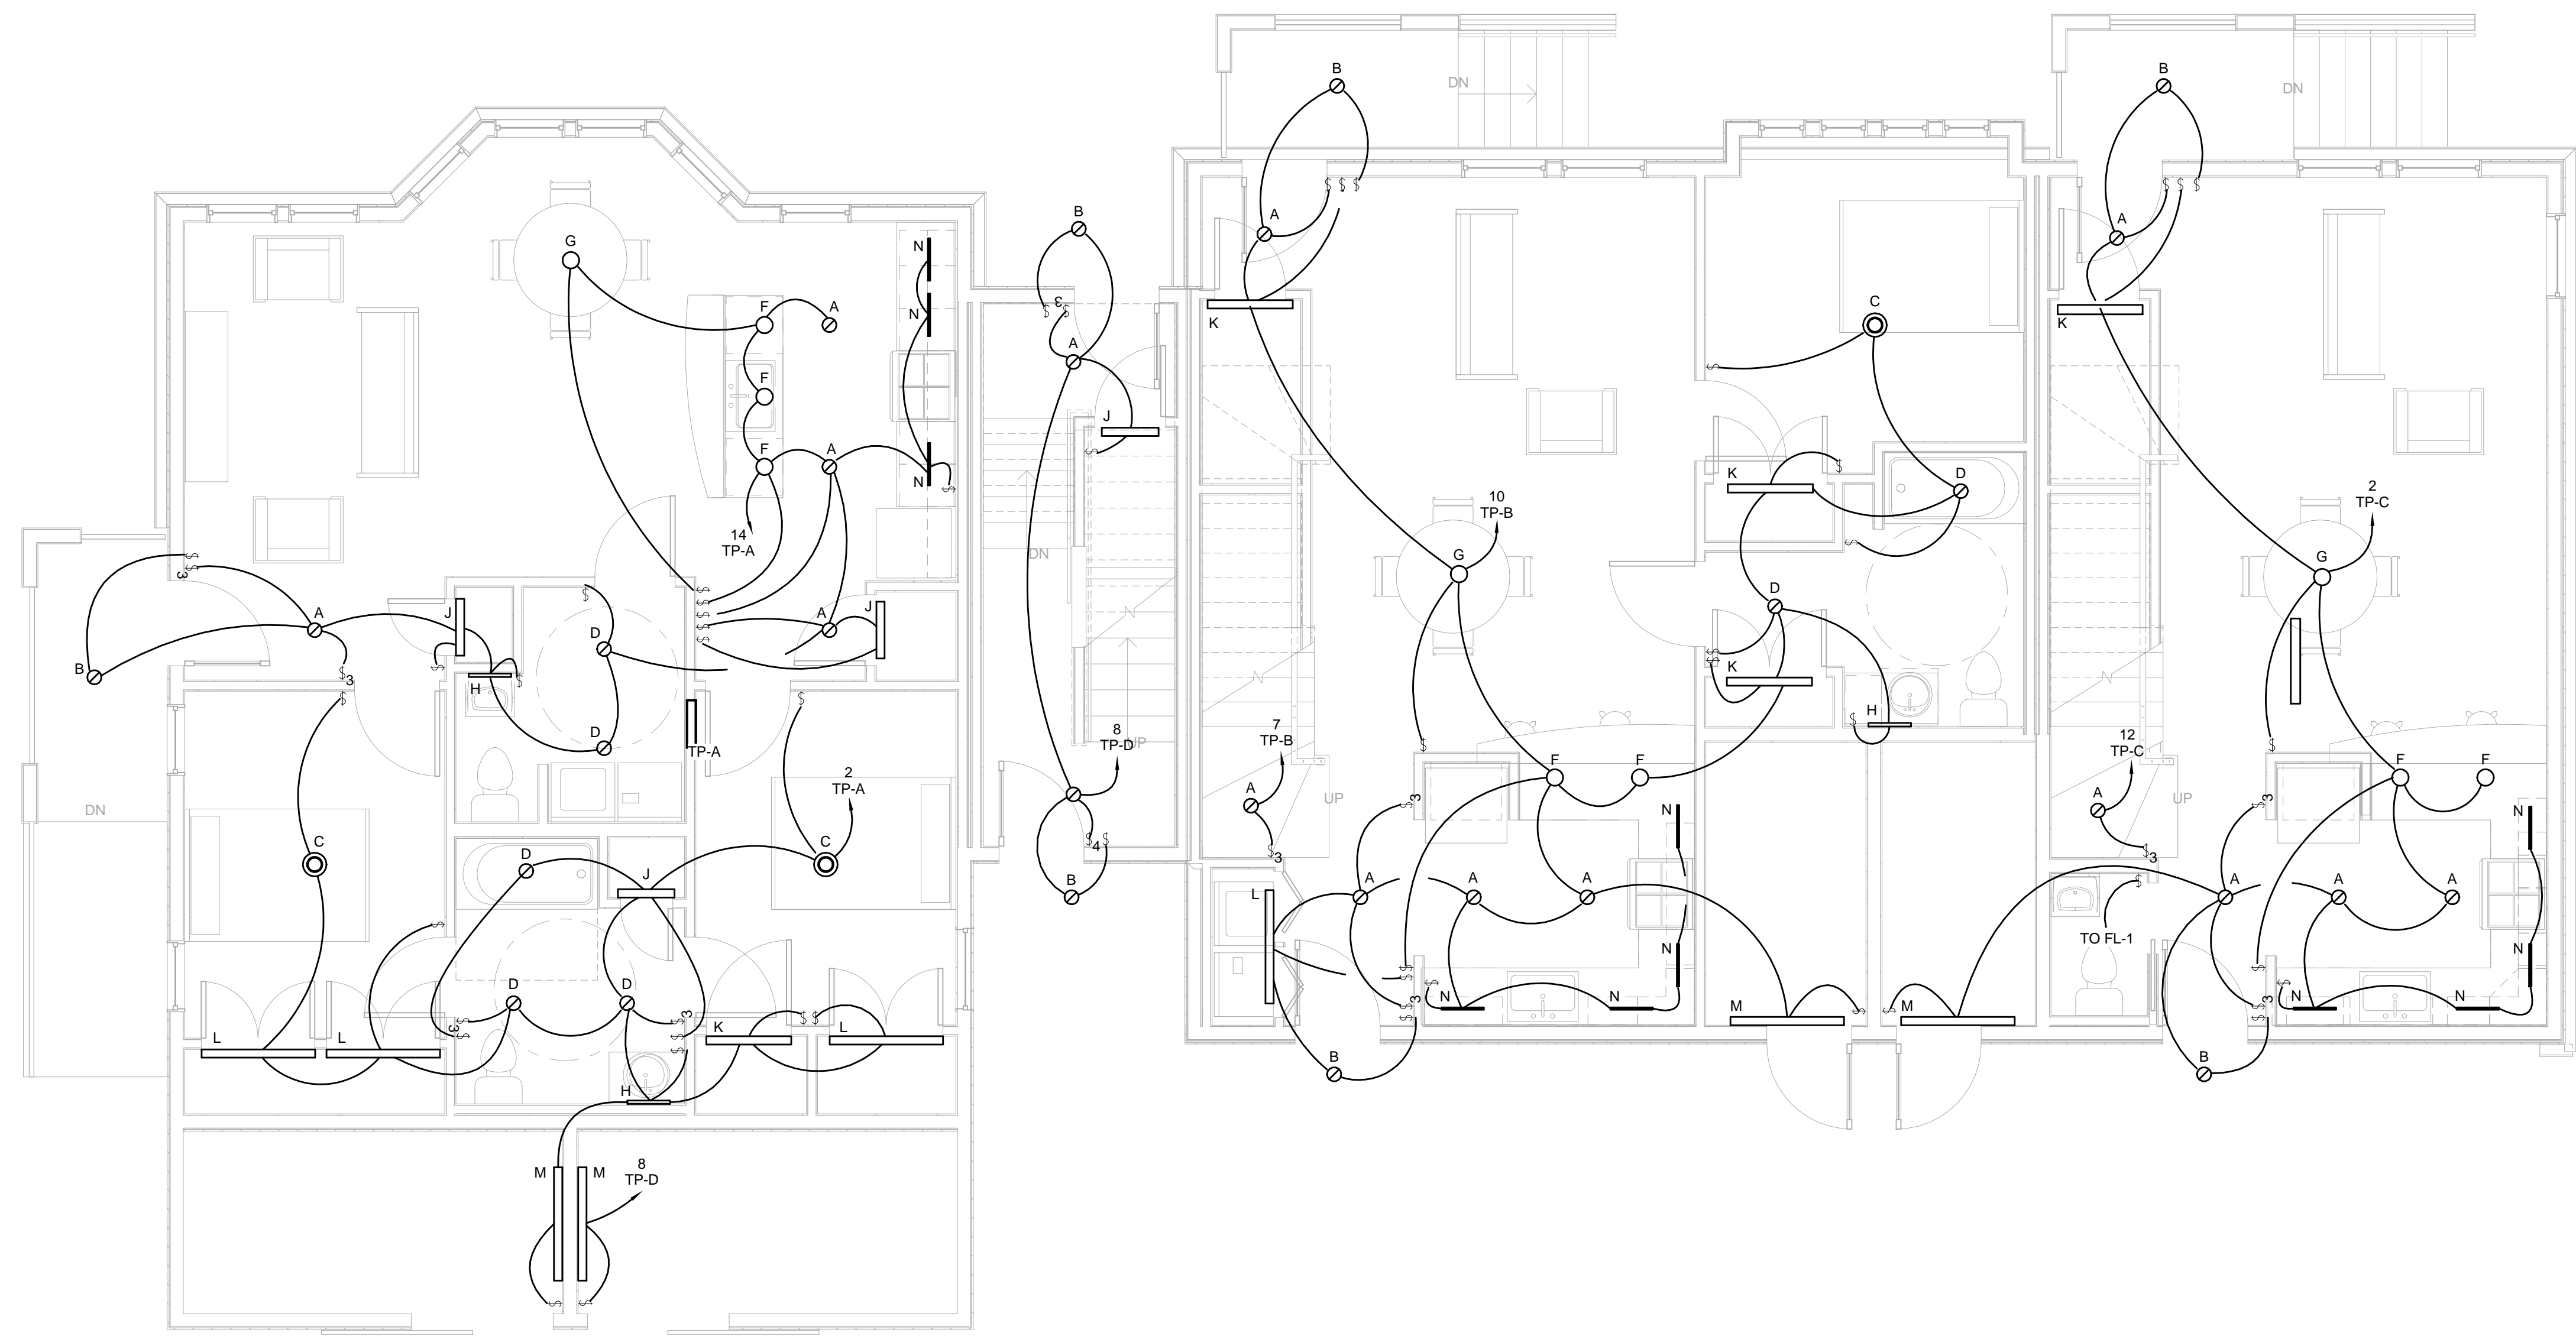

**1** Bldg A 1st Flr Lighting Plan  
1/4" = 1'-0"




49 DARTMOUTH STREET  
PORTLAND, MAINE 04101  
207-775-1059  
www.pdtarchs.com

**COPYRIGHT 2011**  
PDT Architects  
Reuse or reproduction of the contents of this document is not permitted without written permission of PDT Architects.



**BENNETT ENGINEERING**  
MECHANICAL • ELECTRICAL  
(207) 865-9475

**ADAMS SCHOOL REDEVELOPMENT**  
Portland, ME

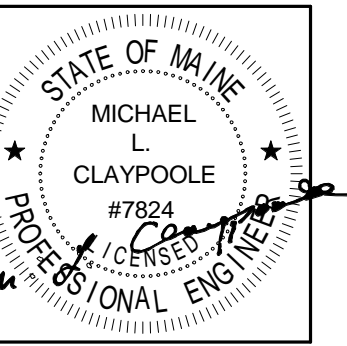

JOB NO.  
08-056

DRWN. CHK  
SMR WSBJR

SCALE:  
1/4" = 1'-0"

ISSUE  
5 MARCH 2012

TITLE  
Bldg A First Floor  
Lighting Plan

SHEET  
**E201**