


NOTE:
Buildings B, C & D are similar to Building A, refer to Architectural drawings for more information.

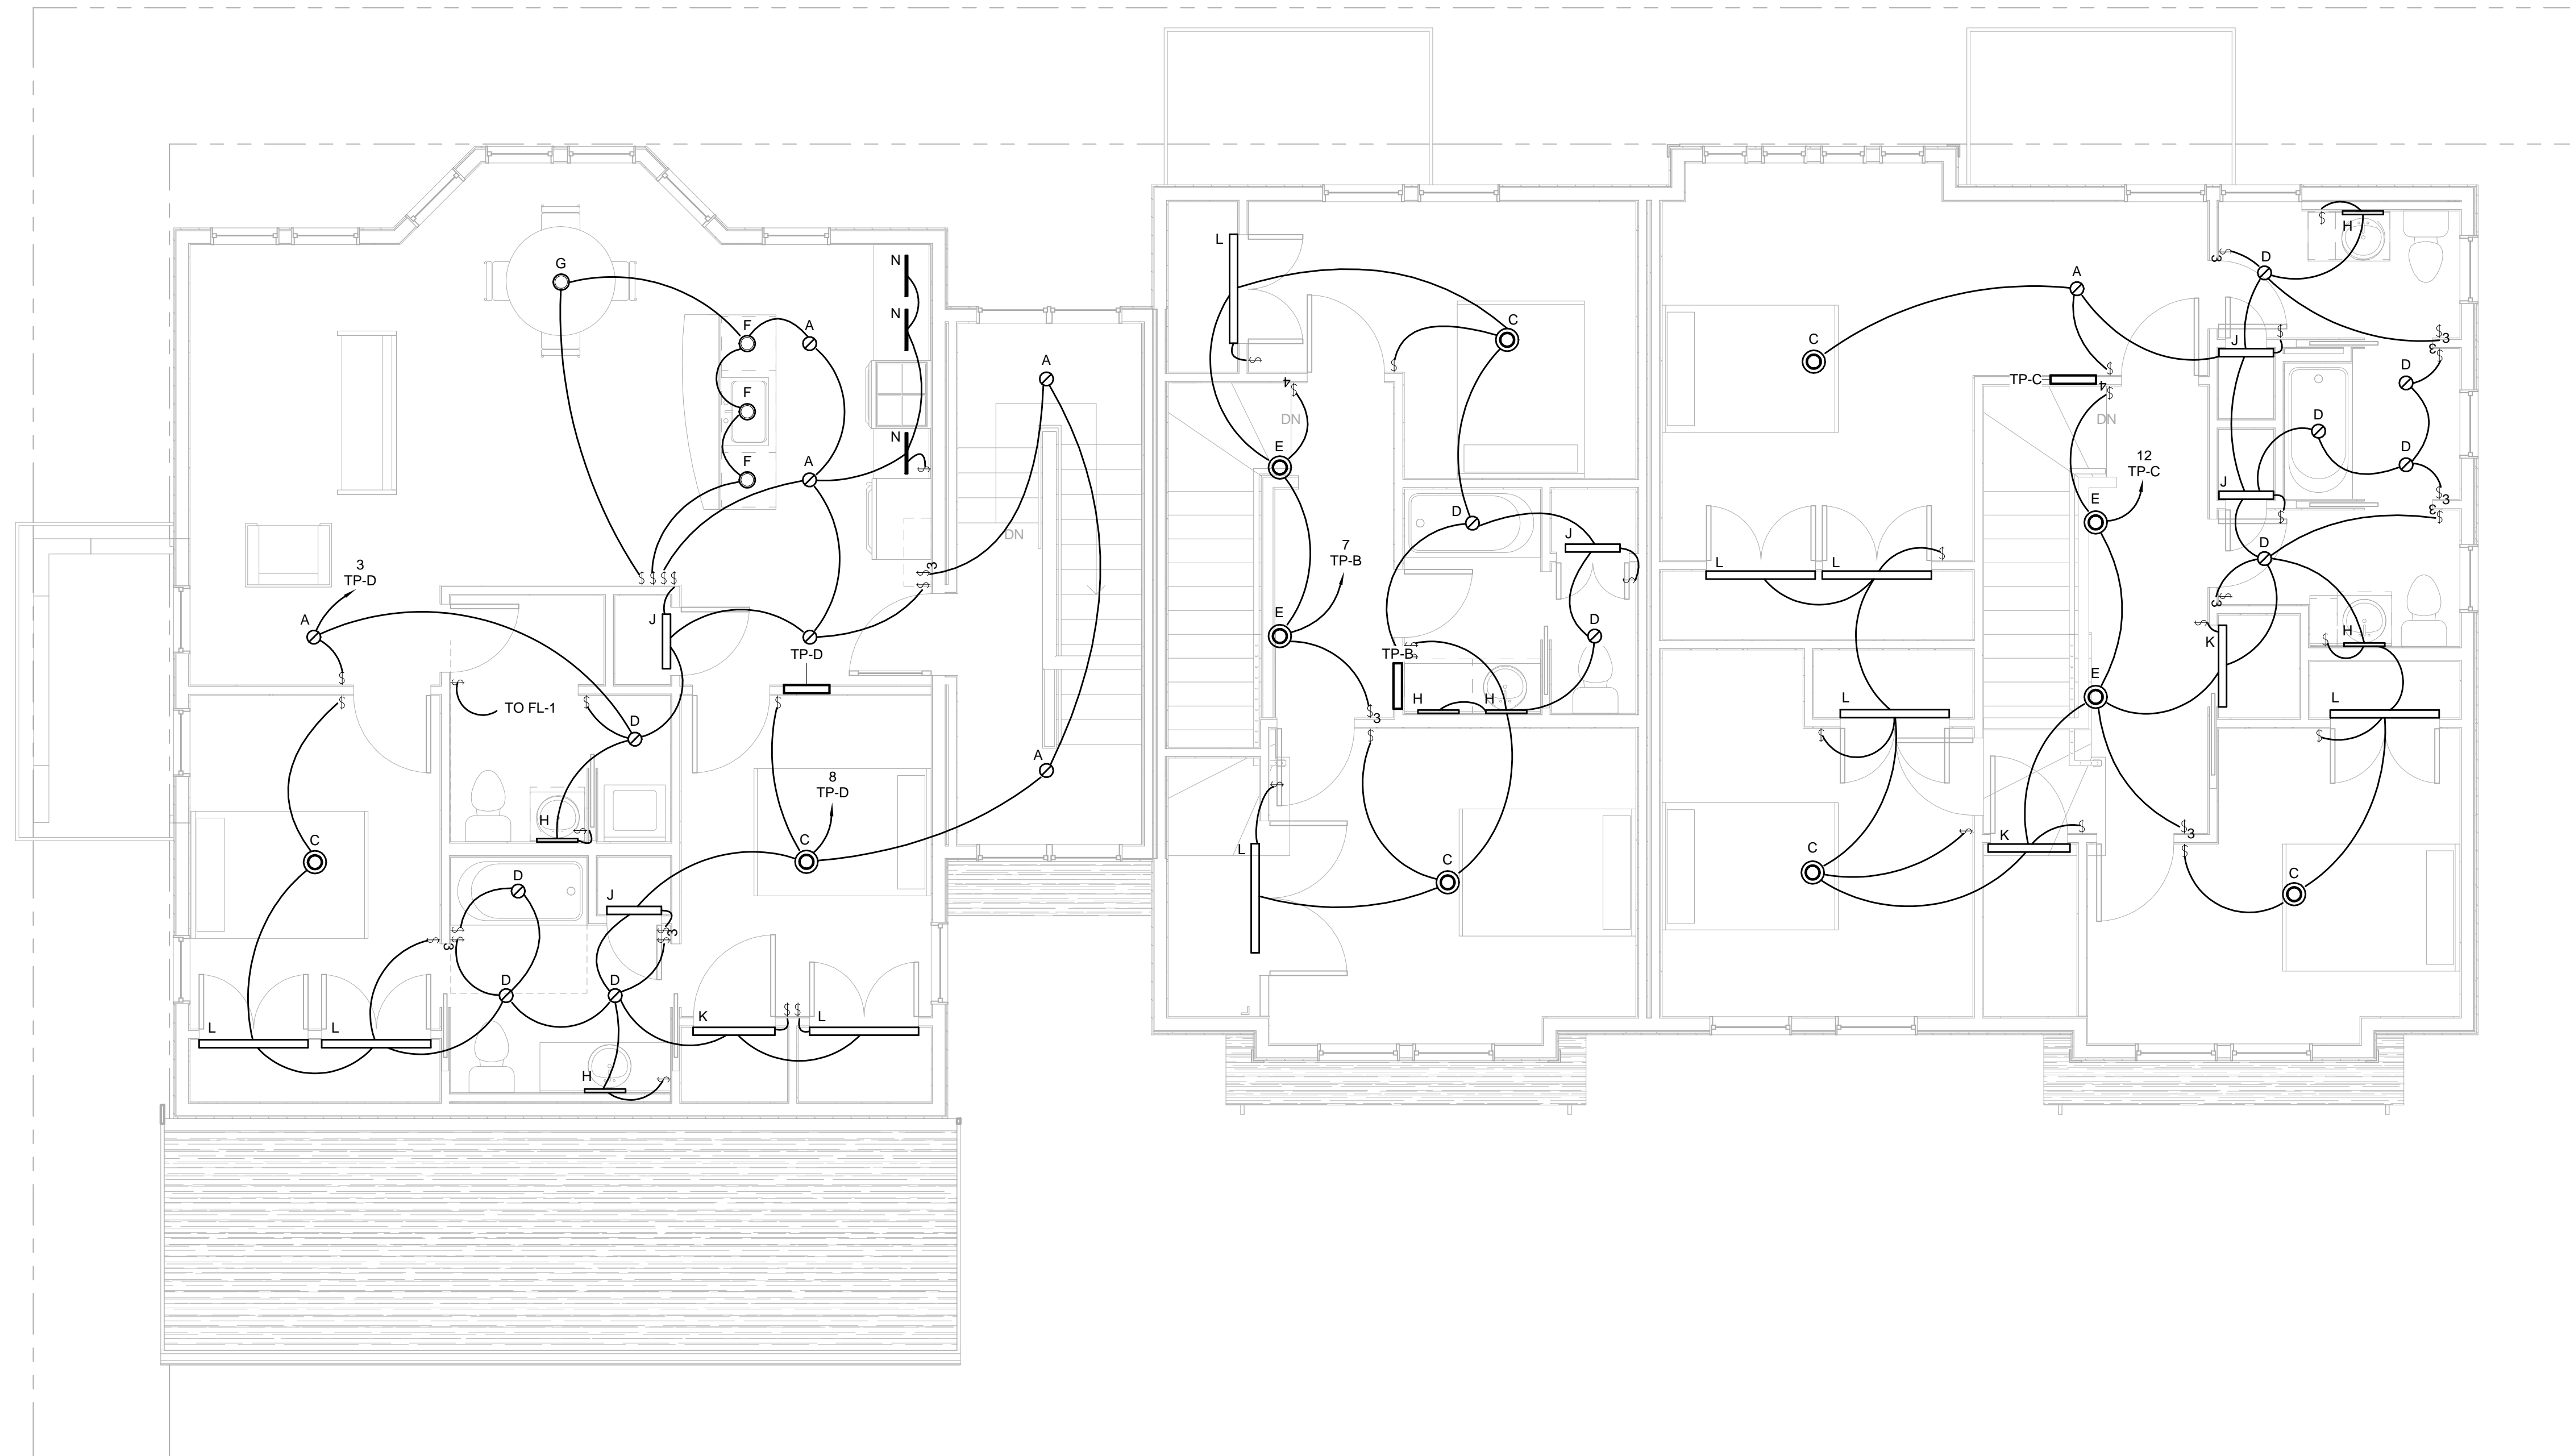

1 Bldg A 2nd Flr Lighting Plan
1/4" = 1'-0"




49 DARTMOUTH STREET
PORTLAND, MAINE 04101
207-775-1059
www.pdtarchs.com

COPYRIGHT 2011
PDT Architects
Reuse or reproduction of the contents of this document is not permitted without written permission of PDT Architects.



BENNETT ENGINEERING
MECHANICAL • ELECTRICAL
(207) 865-9475

ADAMS SCHOOL REDEVELOPMENT
Portland, ME

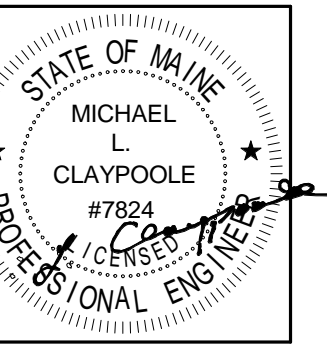

JOB NO.
08-056

DRWN. CHK
SMR WSBJR

SCALE:
1/4" = 1'-0"

ISSUE
5 MARCH 2012

TITLE
Bldg A Second Floor Lighting Plan

SHEET
E202