




BUILDING 'C' ONE LINE DIAGRAM
SCALE: NONE

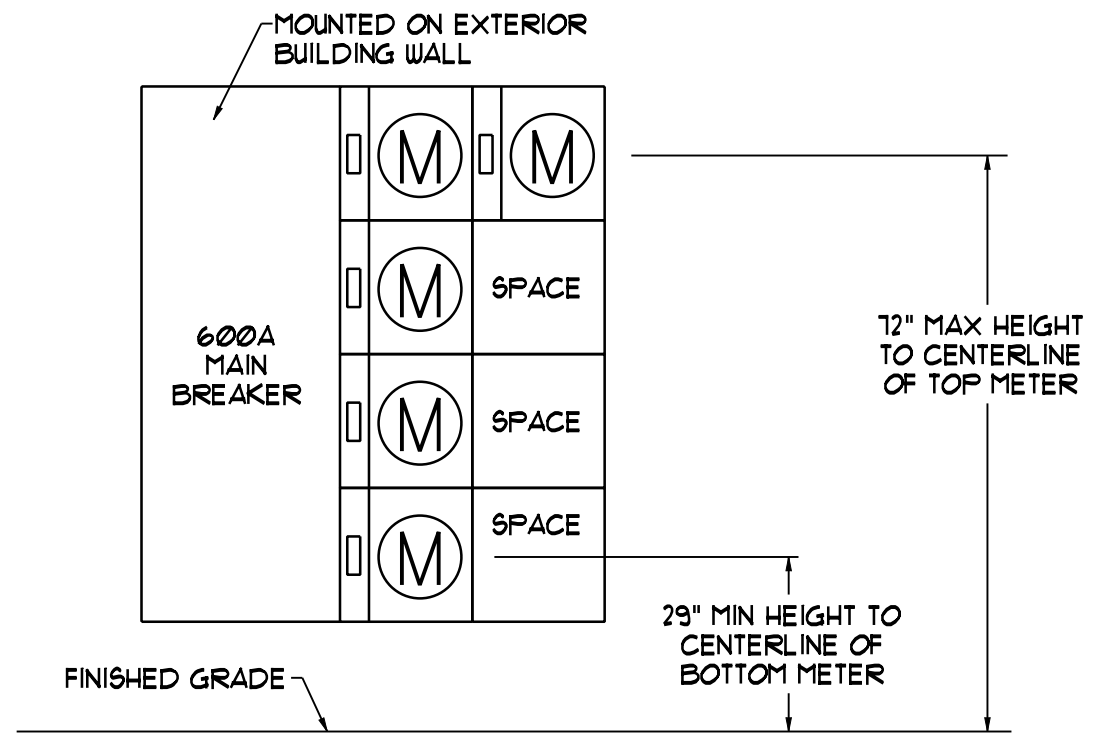


METER STACK ELEVATION - (BUILDING 'C')
SCALE: NONE

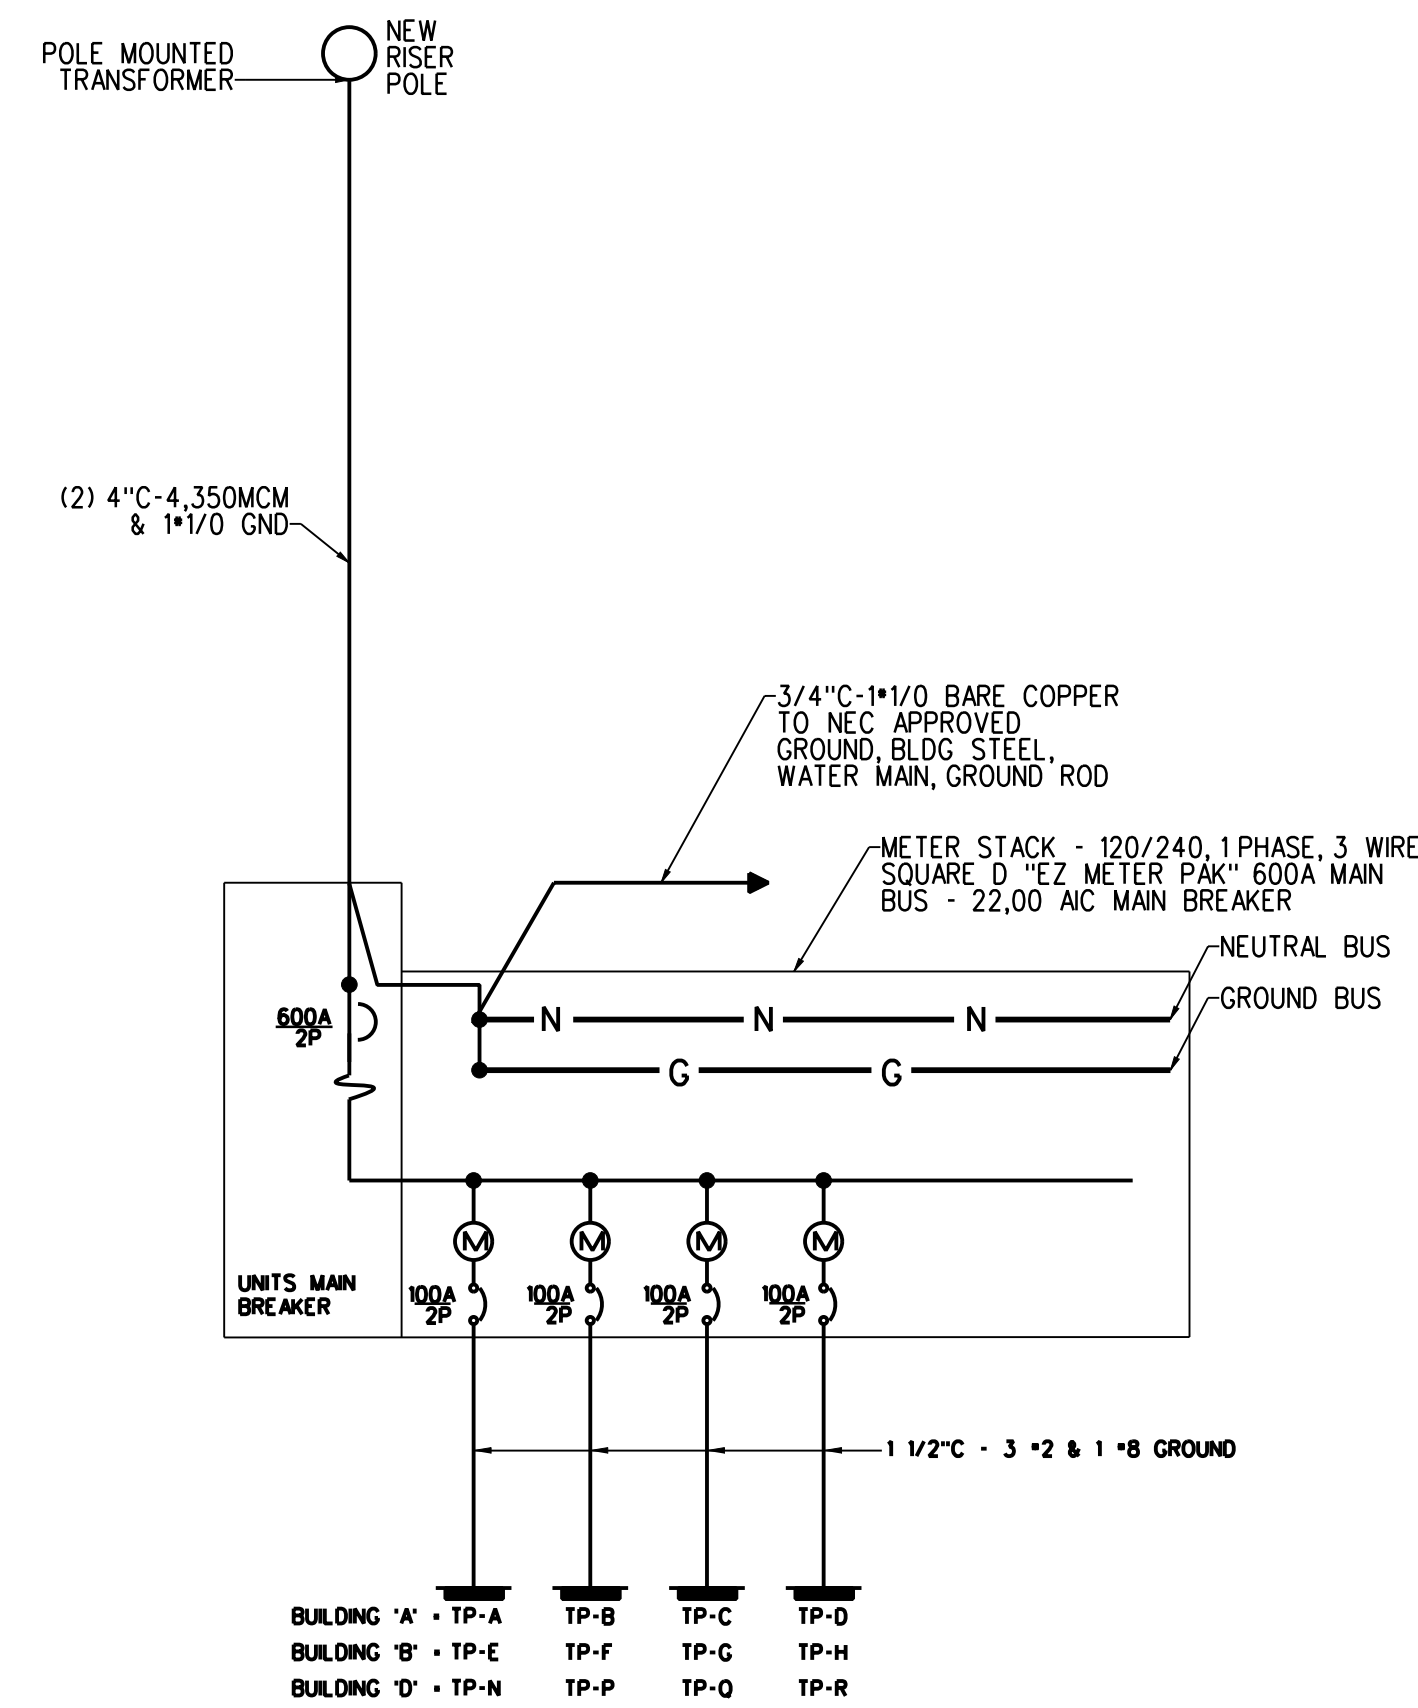

BUILDINGS 'A', 'B' & 'D' ONE LINE DIAGRAM
SCALE: NONE

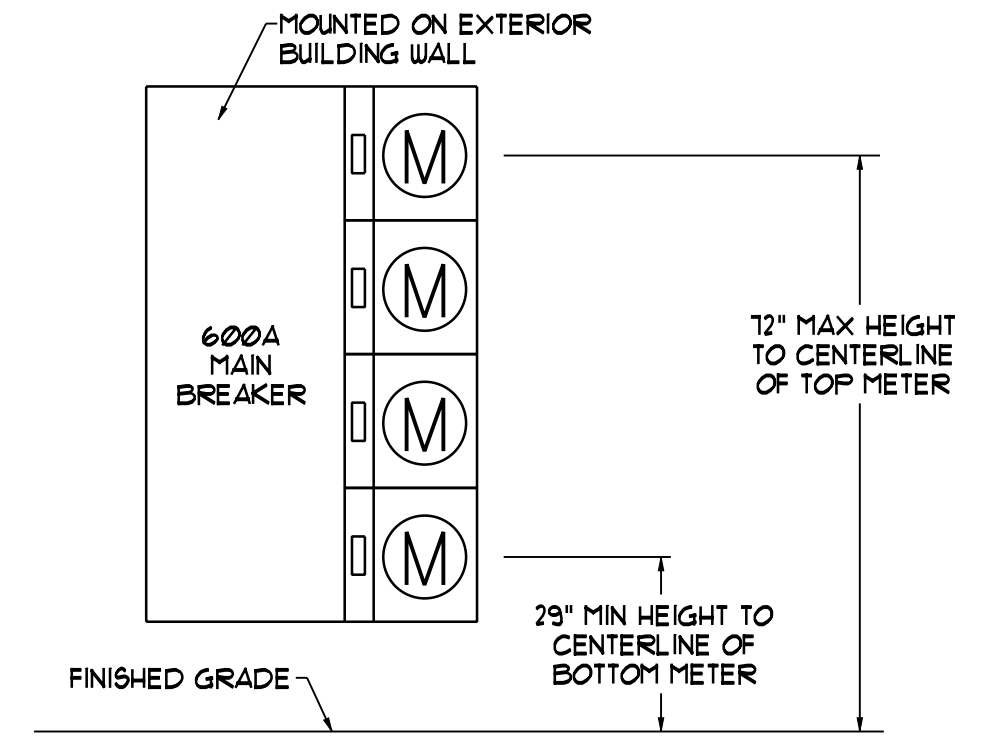

METER STACK ELEVATION - (BUILDINGS 'A', 'B' & 'D')
SCALE: NONE

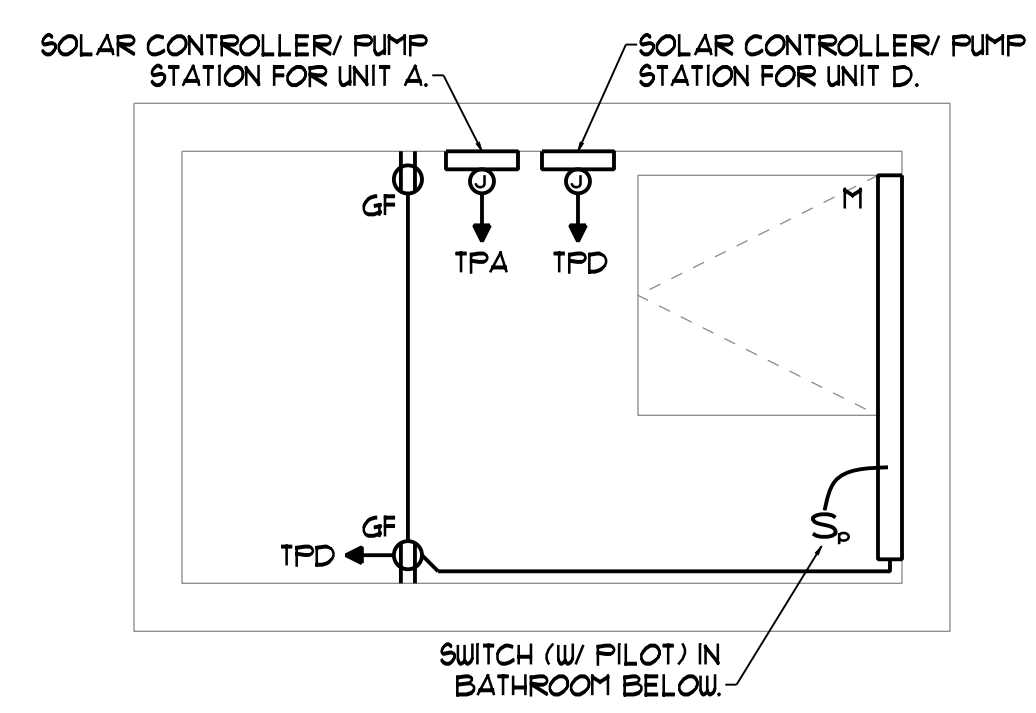

ALTERNATE #4 - ATTIC MECHANICAL ROOM
SCALE: 1/2" = 1'-0"

NOTES:
1. SEE ARCHITECTURAL PLAN FOR LOCATION OF ATTIC MECHANICAL ROOM AND ACCESS.
2. UNITS B AND C POWER REQUIREMENTS ARE SIMILAR.




49 DARTMOUTH STREET
PORTLAND, MAINE 04101
207-775-1059
www.pdtarchs.com

COPYRIGHT 2011
PDT Architects
Reuse or reproduction of the contents of this document is not permitted without written permission of PDT Architects.



ADAMS SCHOOL REDEVELOPMENT
Portland, ME

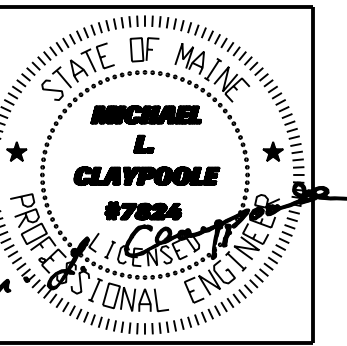

JOB NO.
08-056

DRWN. CHK
SMR WSBJR

SCALE:
AS NOTED

ISSUE
5 MARCH 2012

TITLE
Electrical
Details

SHEET
E602