




49 DARTMOUTH STREET
PORTLAND, MAINE 04101
207-775-1059
www.pdtarch.com

COPYRIGHT 2011
PDT Architects
Reuse or reproduction of the contents of this document is not permitted without written permission of PDT Architects.



MECHANICAL • ELECTRICAL
(207) 865-9475

ADAMS SCHOOL REDEVELOPMENT
Portland, ME

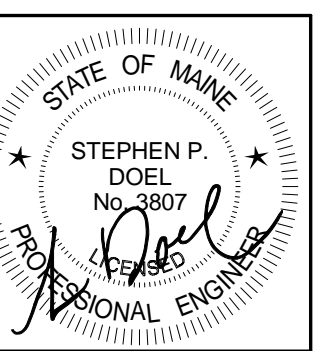

JOB NO.
08-056

DRWN. CHK
JMV SPD


SCALE:
1/4" = 1'-0"

ISSUE
5 MARCH 2012

TITLE
Bldg A First Floor
Domestic Piping
Plan

SHEET
M201

NOTE:
Buildings B, C & D are similar to Building A, refer to Architectural drawings for more information.

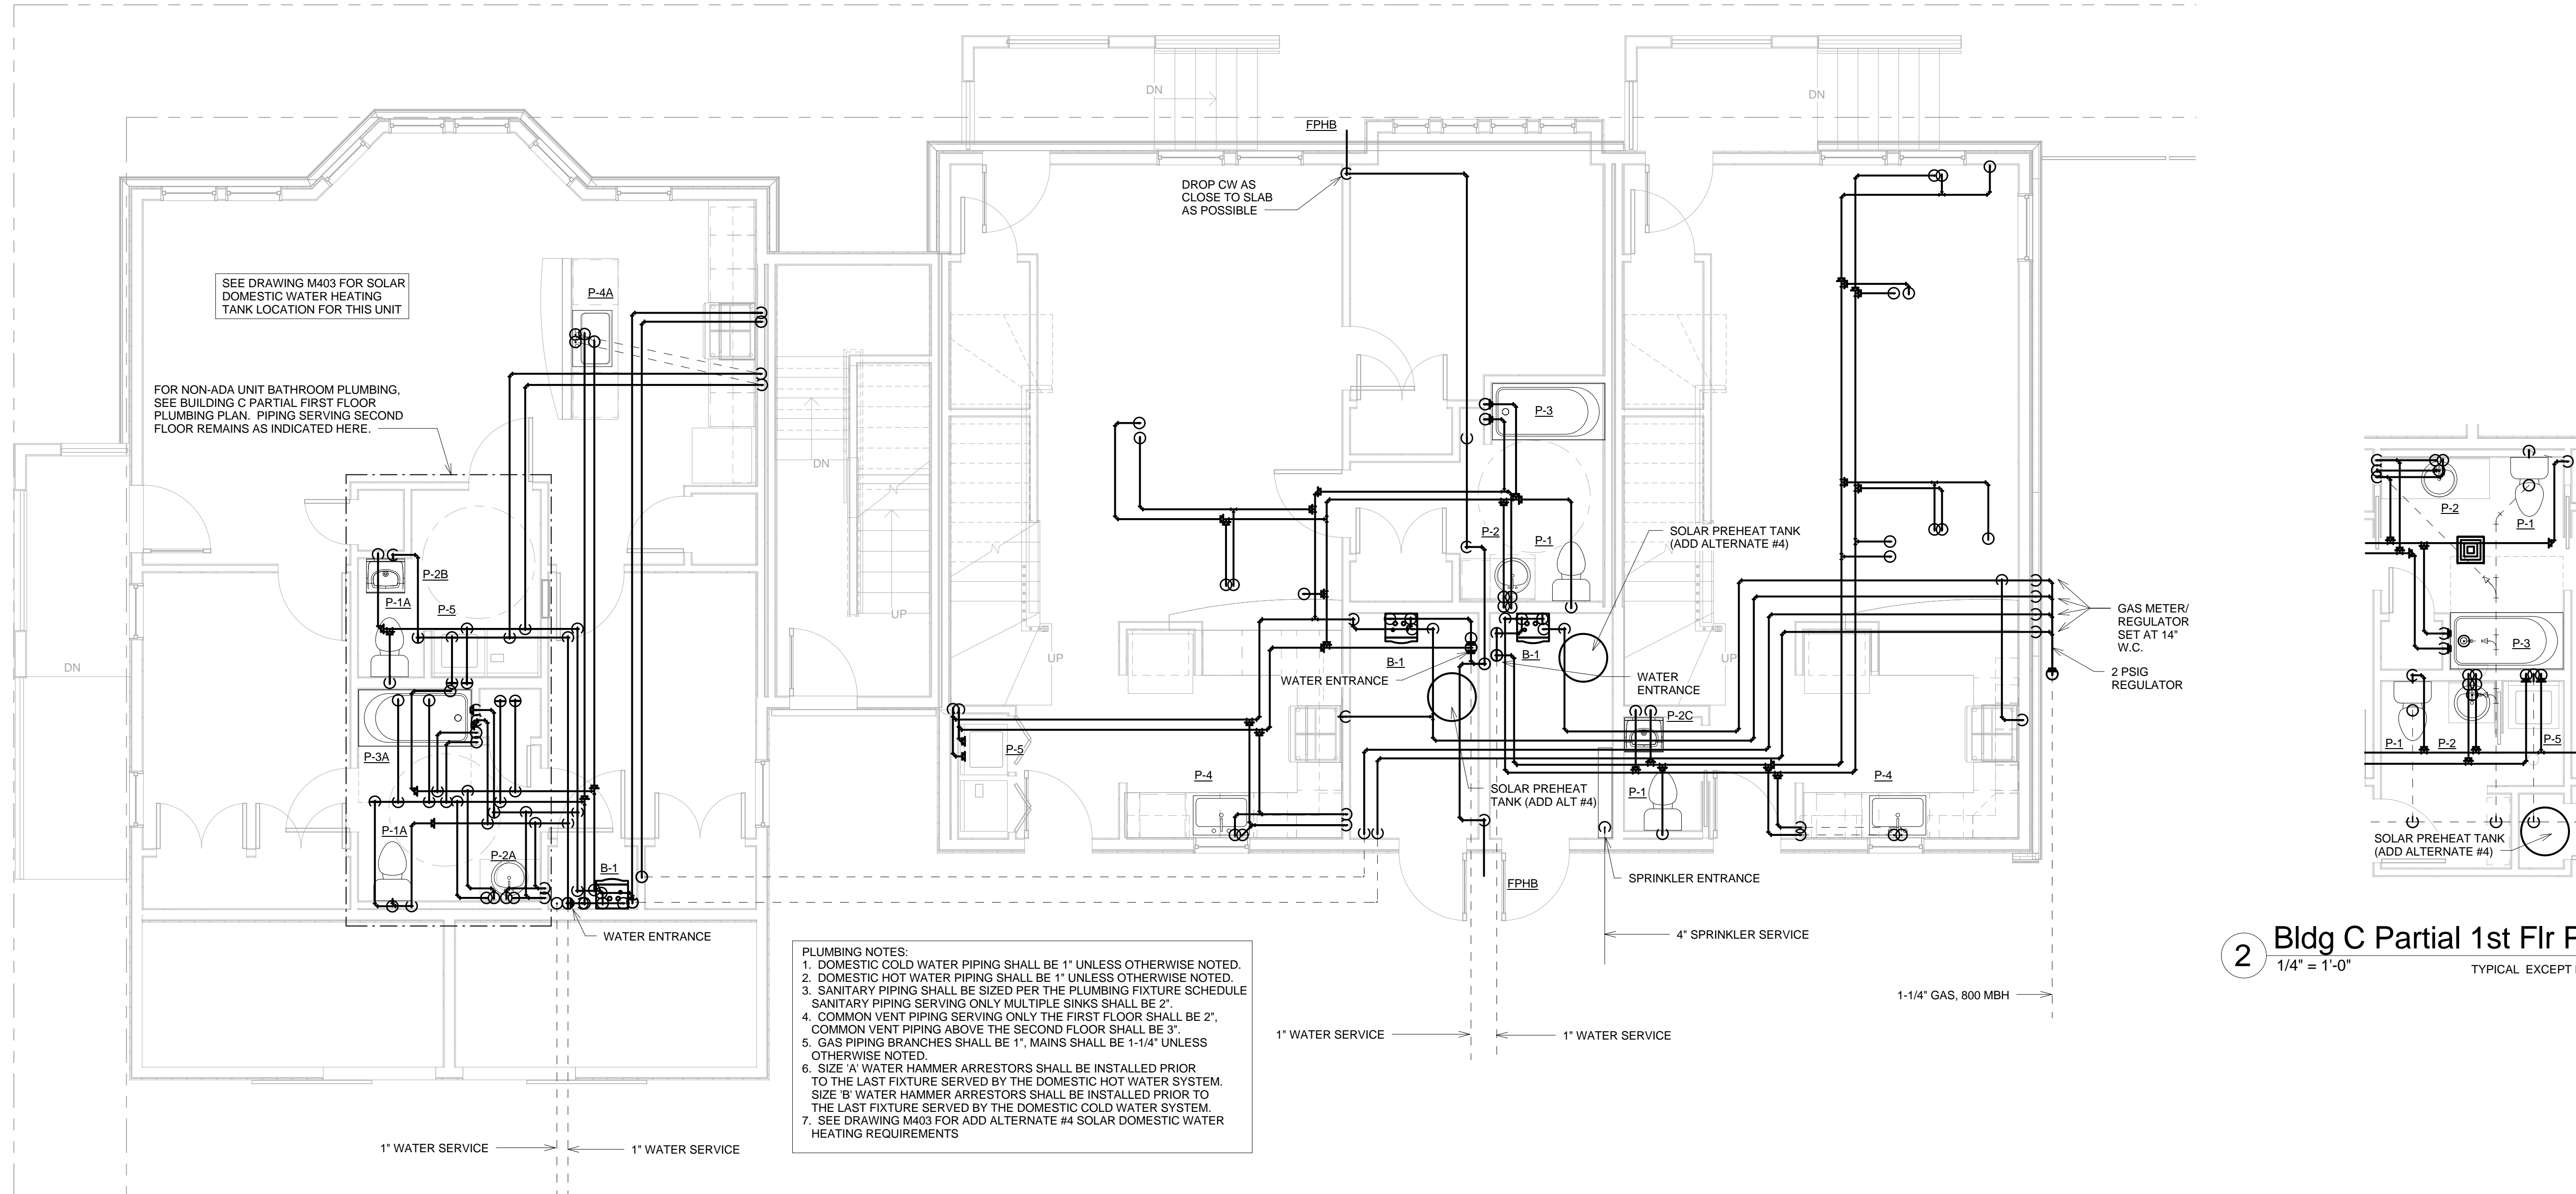

- PLUMBING NOTES:**
1. DOMESTIC COLD WATER PIPING SHALL BE 1" UNLESS OTHERWISE NOTED.
 2. DOMESTIC HOT WATER PIPING SHALL BE 1" UNLESS OTHERWISE NOTED.
 3. SANITARY PIPING SHALL BE SIZED PER THE PLUMBING FIXTURE SCHEDULE.
 4. COMMON VENT PIPING SERVING ONLY THE FIRST FLOOR SHALL BE 2".
 5. COMMON VENT PIPING ABOVE THE SECOND FLOOR SHALL BE 3".
 6. GAS PIPING BRANCHES SHALL BE 1", MAINS SHALL BE 1-1/4" UNLESS OTHERWISE NOTED.
 7. SIZE 'A' WATER HAMMER ARRESTORS SHALL BE INSTALLED PRIOR TO THE LAST FIXTURE SERVED BY THE DOMESTIC HOT WATER SYSTEM.
 8. SIZE 'B' WATER HAMMER ARRESTORS SHALL BE INSTALLED PRIOR TO THE LAST FIXTURE SERVED BY THE DOMESTIC COLD WATER SYSTEM.
 9. SEE DRAWING M403 FOR ADD ALTERNATE #4 SOLAR DOMESTIC WATER HEATING REQUIREMENTS.

1 Bldg A 1st Flr Domestic Piping Plan
1/4" = 1'-0"

2 Bldg C Partial 1st Flr Plumbing Plan
1/4" = 1'-0" TYPICAL EXCEPT FOR UNIT A