



PROGRESS PRINT
NOT FOR CONSTRUCTION

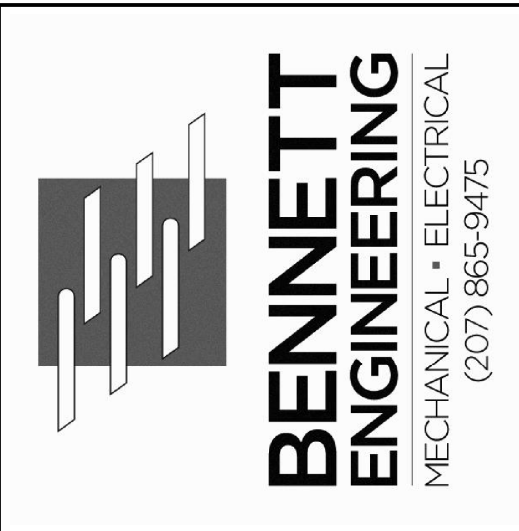

IDEAL ELECTRIC
86 China Rd.
Winslow, ME 04901

65 MUNJOY ST. APARTMENTS
65 Munjoy St., Portland, ME 04101
TYPICAL UPPER FLOOR LIGHTING PLAN

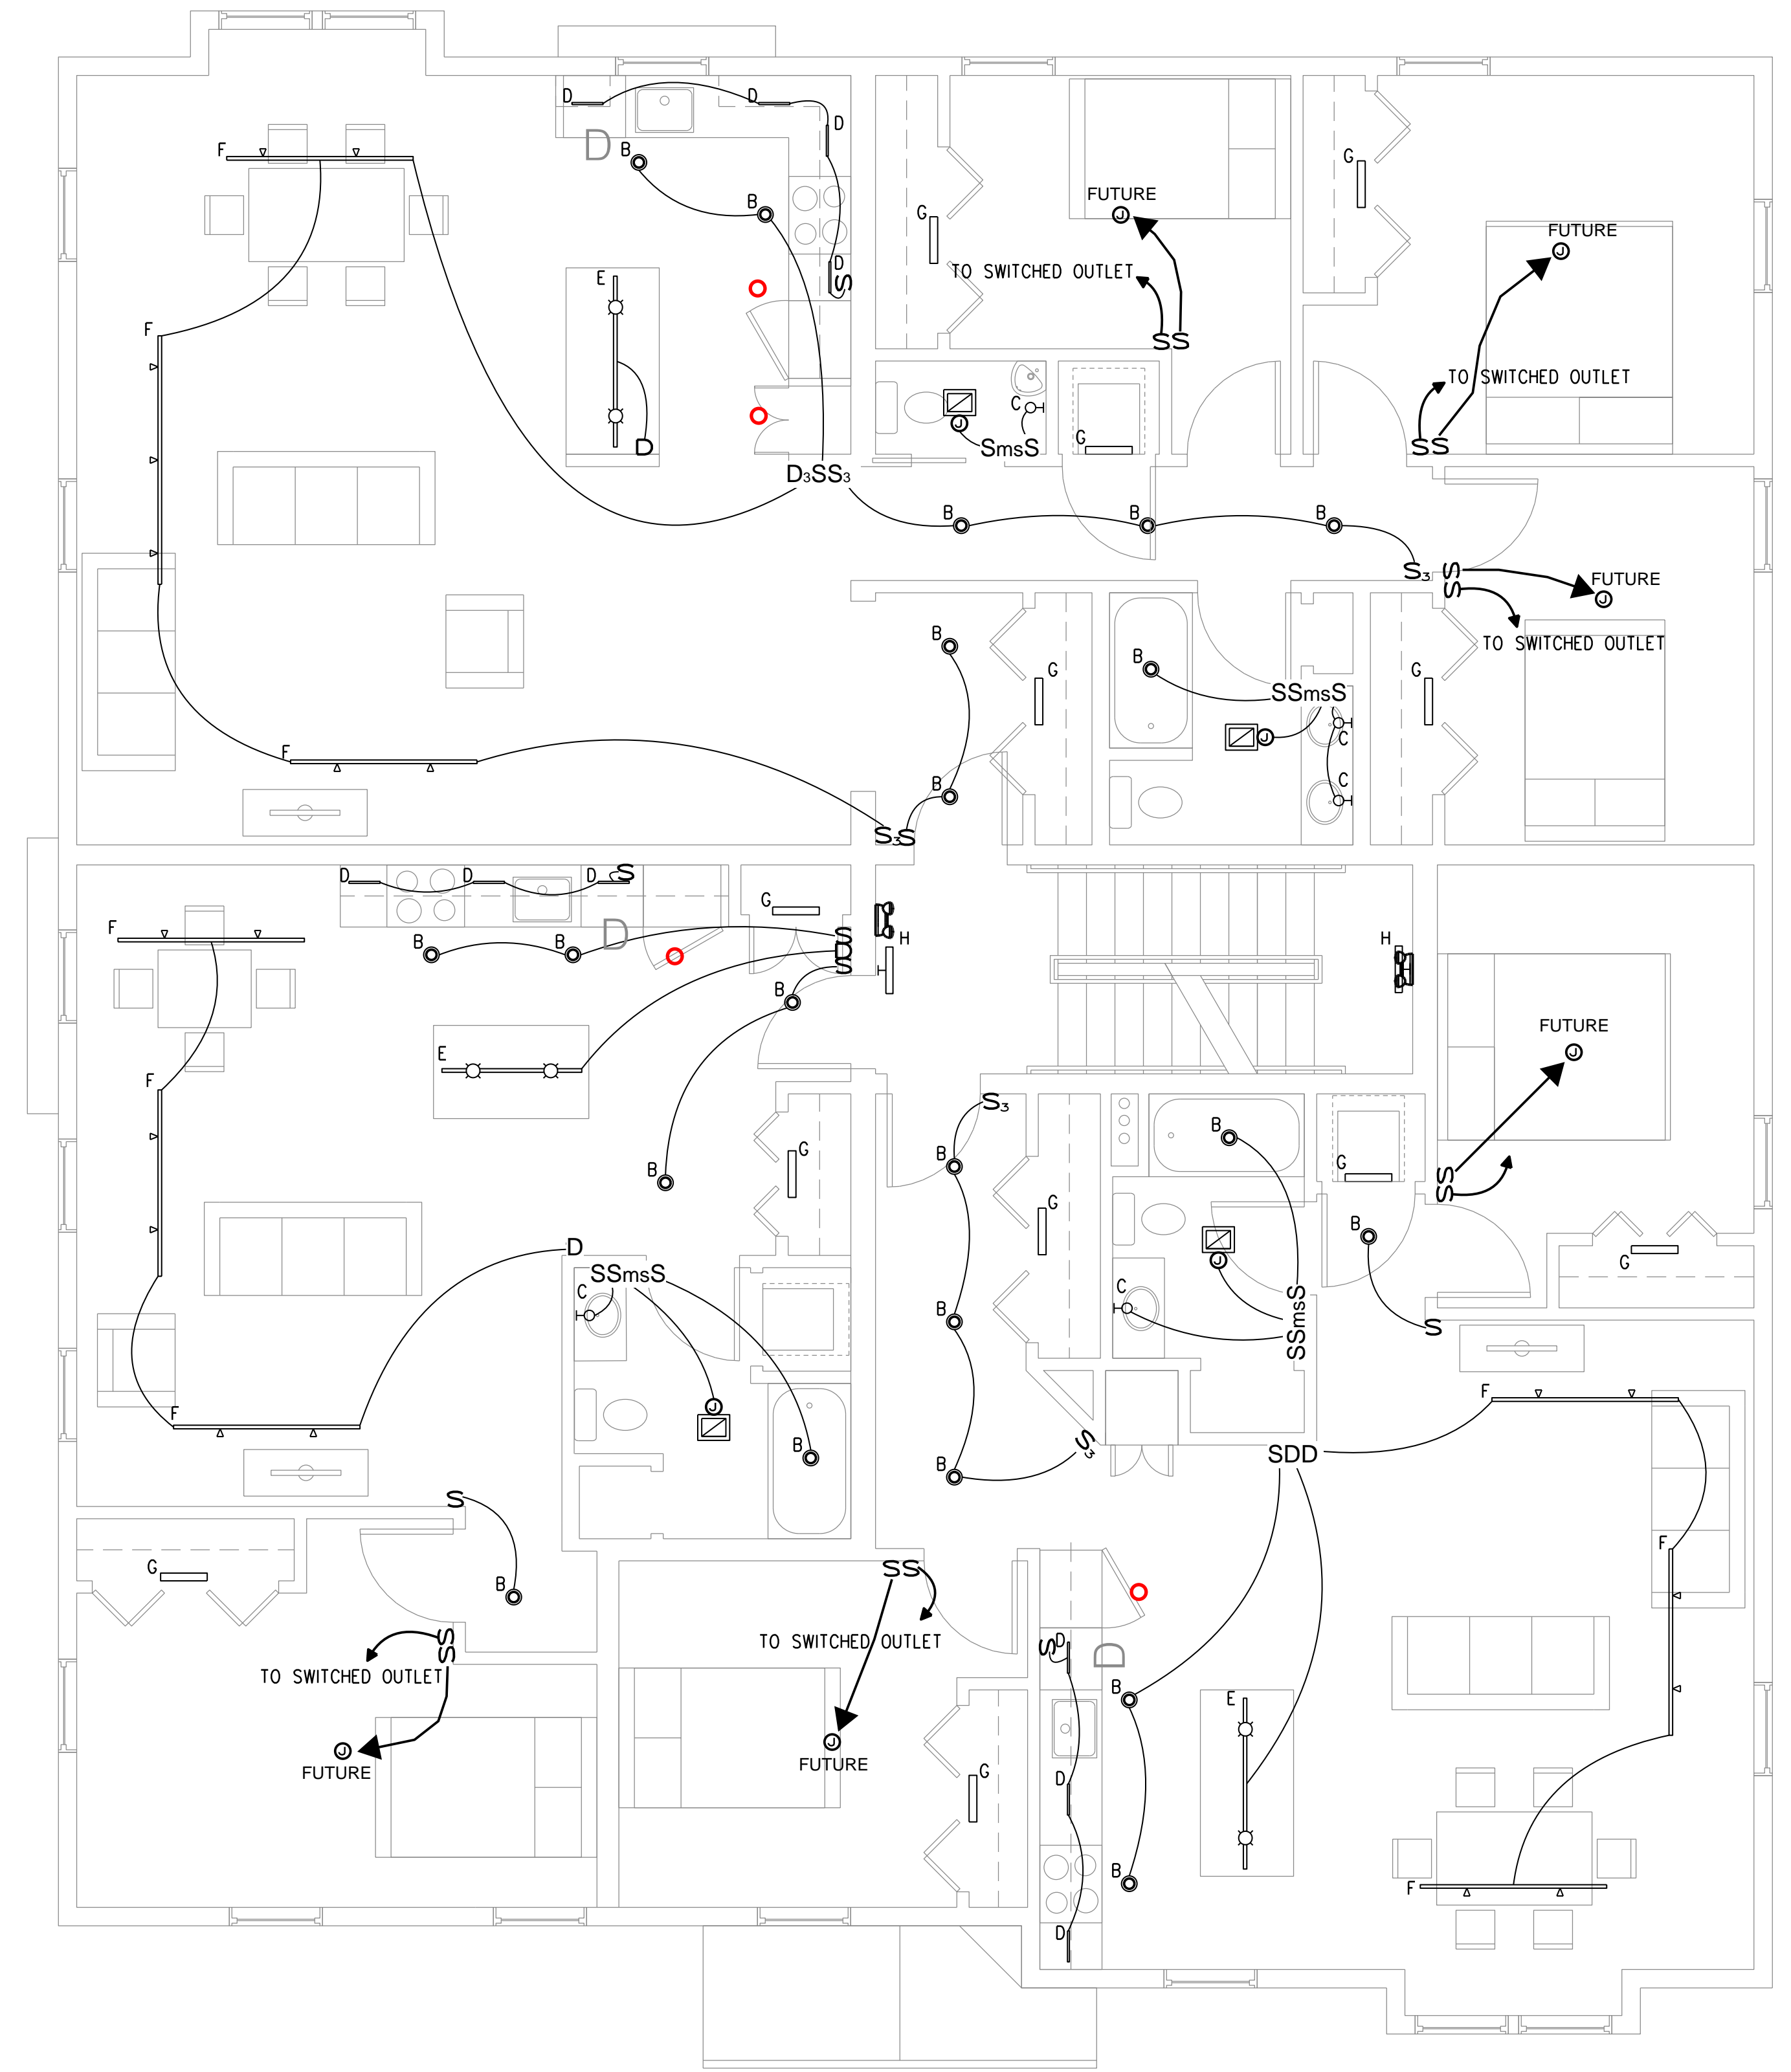

TYPICAL SECOND & THIRD FLOOR LIGHTING PLAN
SCALE: 1/4" = 1'-0"

Date Drawn: 09/16/2016

Drawn By: CAT

Checked By: SAJ

Revision:

1.
2.
3.
4.
5.
6.
7.

BEI Project No: 3936

Scale: AS NOTED

Sht Num: E1.1