



Calculation Summary							
Label	Avg	Max	Min	Avg/Min	Max/Min	PtSpcLr	PtSpcTb
INTERIOR GARAGE	2.30	4.7	0.5	4.60	9.40	5	5
property line	0.02	0.6	0.0	N.A.	N.A.	5	N.A.
site	0.52	4.9	0.0	N.A.	N.A.	5	5

Luminaire Schedule (note fixture catalogue numbers are not complete)						
Type	Symbol	Qty	Lum. Lumens	LLF	Lum. Watts	Description
W1		1	347	0.700	8.3	NS-LED-e23-WFL-12; AR-LED-TR-e
w2		5	568	0.900	11	CATALOG NO _ GL-6541-B-CC-R5-
B5R		1	5477	0.820	55.08	24NB-55-T5R-3k

- NOTES:
- 1) EXACT MOUNTING DETAILS TO BE DETERMINED AT JOBSITE BY OTHERS.
 - 2) CALCULATIONS MAY SHOW THE EFFECT OF SHADOWING CAUSED BY BUILDINGS AND OBJECTS WITHIN THE CALCULATED SPACE OR IN THE SITE AREA.
 - 3) READINGS SHOWN ARE INITIAL HORIZONTAL FOOTCANDLES ON A FLAT SITE UNLESS OTHERWISE INDICATED.
 - 4) THIS CALCULATION IS BASED ON LIMITED INFORMATION SUPPLIED BY OTHERS TO SWANEY LIGHTING ASSOCIATES AND STANDARD ASSUMPTIONS OF THE SPACE AND/OR SITE.
 - 5) CONFORMANCE TO CODES AND OTHER LOCAL REQUIREMENTS AS DETERMINED BY THE AHJ ARE THE RESPONSIBILITY OF THE OWNER AND/OR THE OWNER'S REPRESENTATIVE.
 - 6) THIS LAYOUT DRAWING MUST BE COORDINATED WITH THE SITE LOCATION FOR CORRECT FIXTURE ORIENTATION.
 - 7) CHECK GRAPHIC SCALE. DOCUMENTS PRINTED OR PLOTTED FROM ELECTRONIC FILES MAY OCCUR AT OTHER THAN THE DESIRED OR ASSUMED GRAPHIC SCALES. IT IS THE RESPONSIBILITY OF THE RECIPIENT TO VERIFY THAT THE PRINTED OR PLOTTED-TO-SCALE DRAWING IS PRINTED TO SCALE.

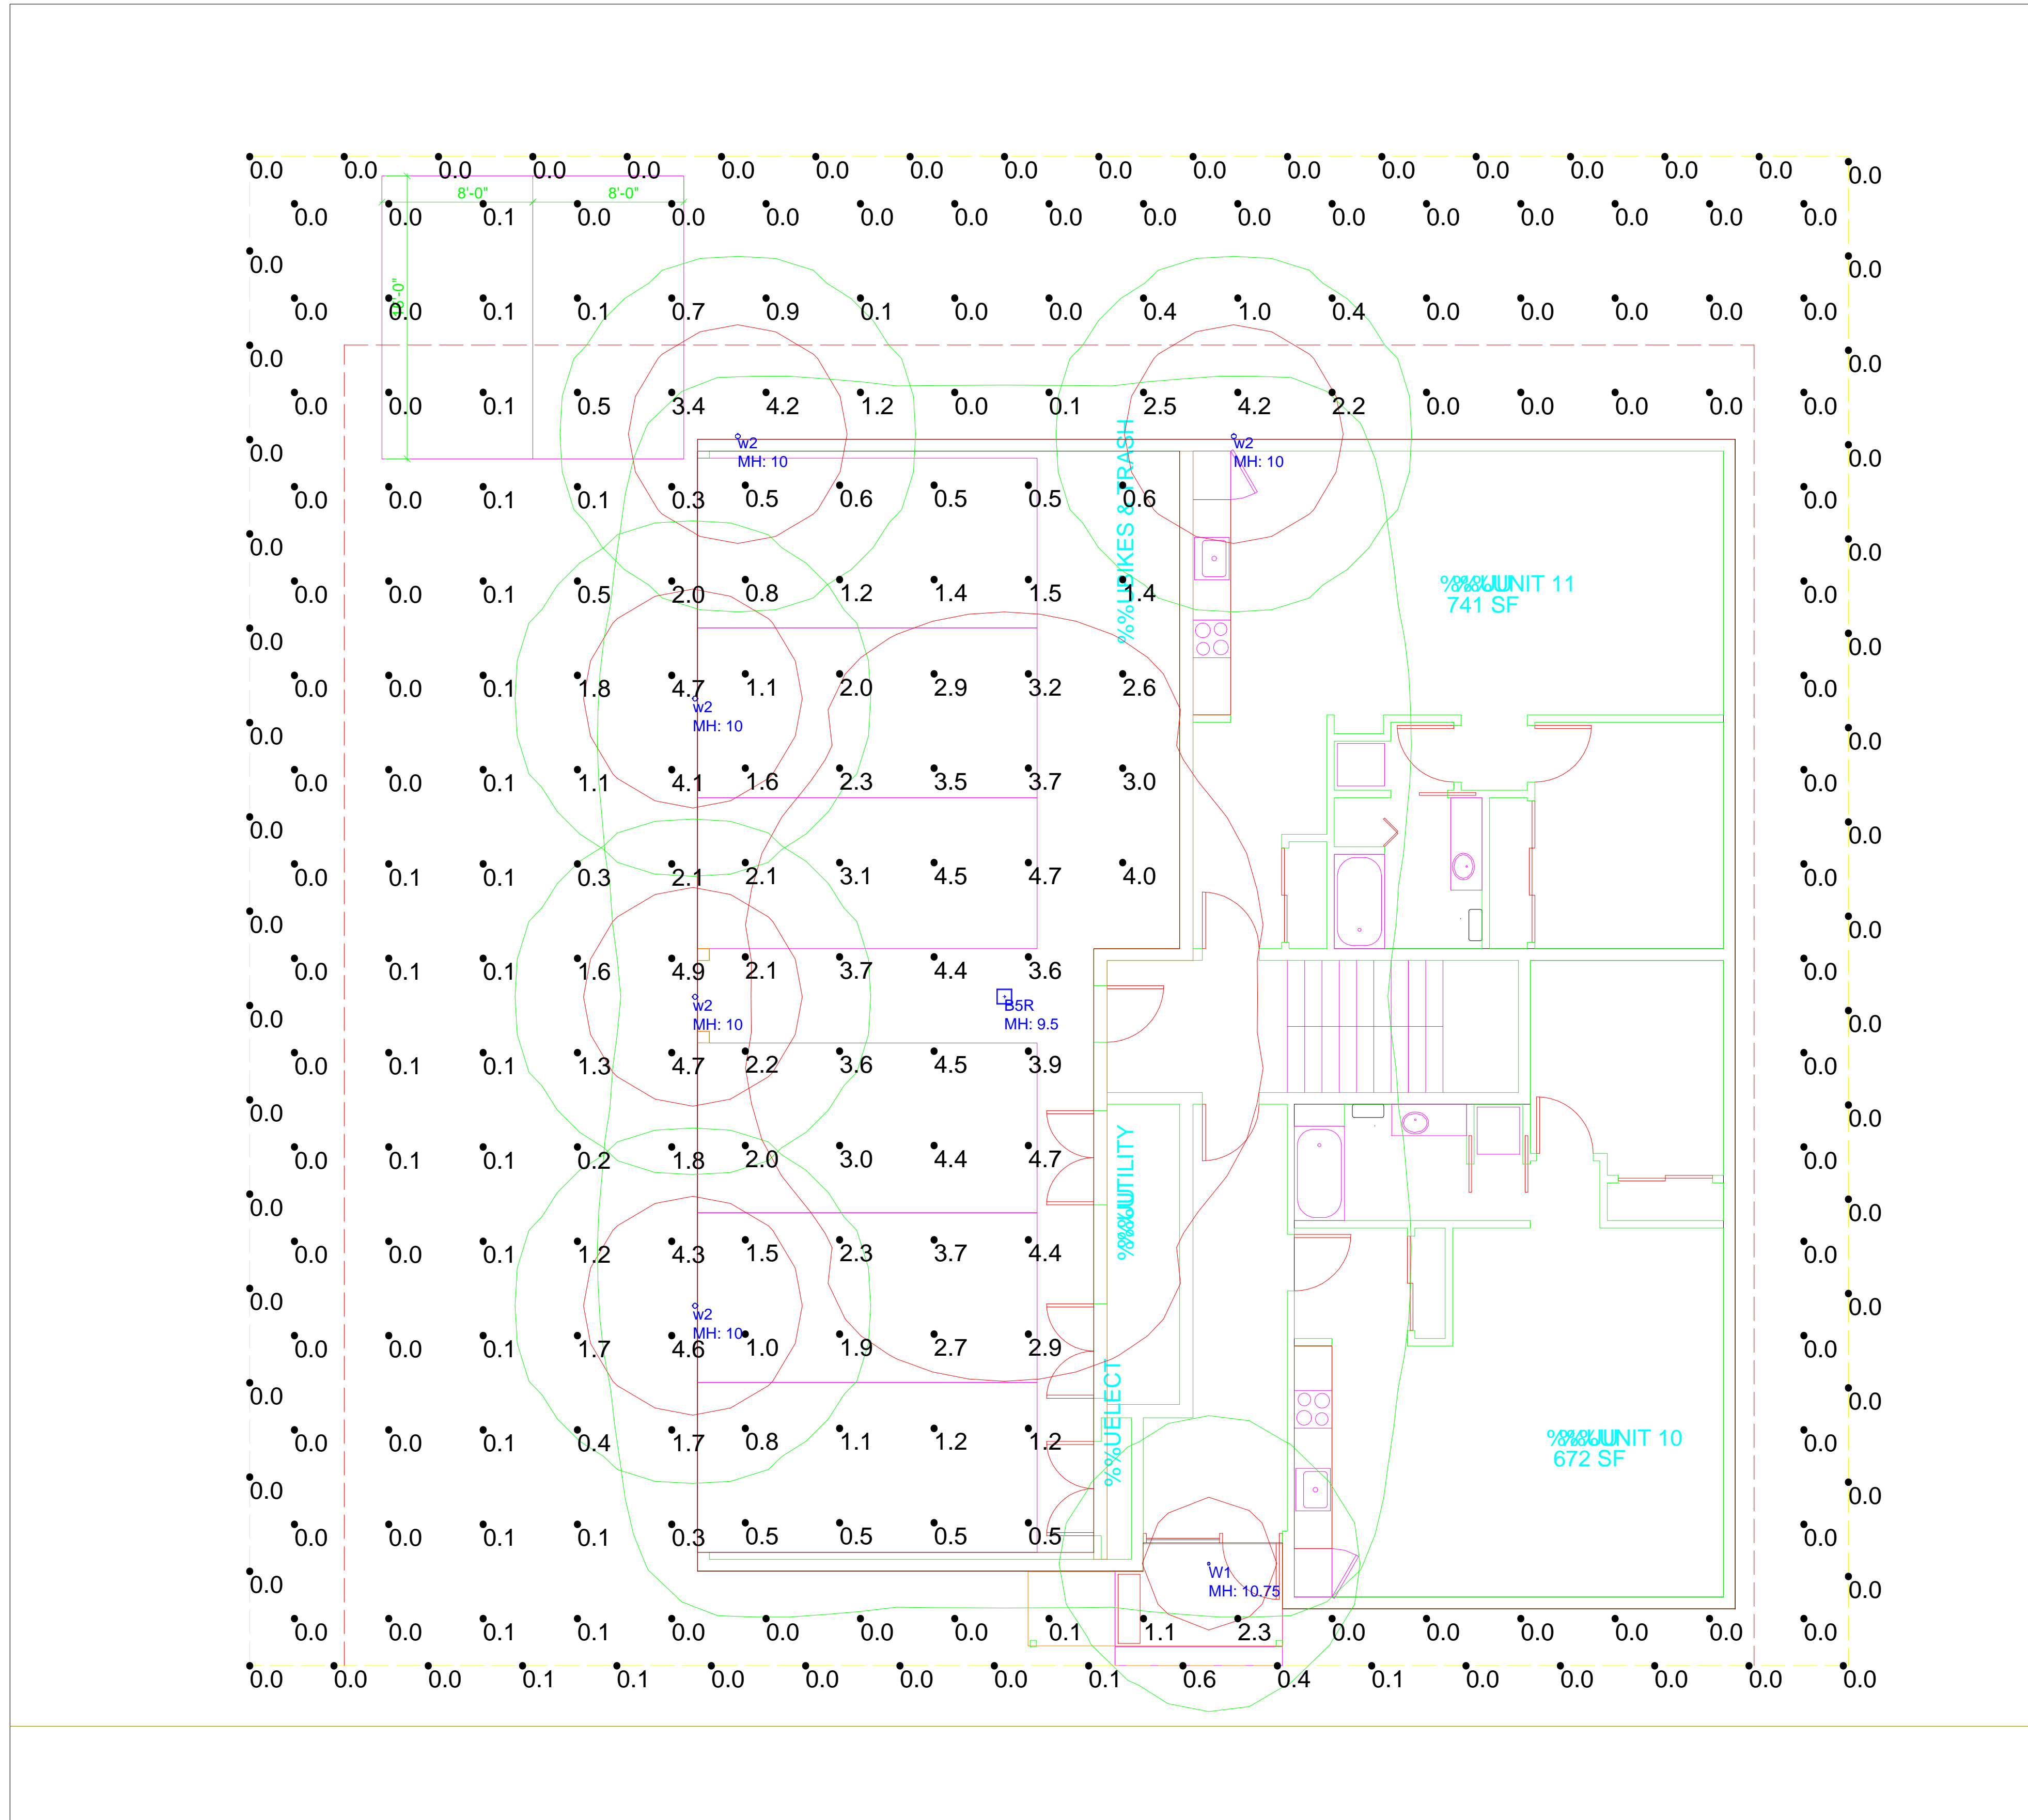

PLAN VIEW

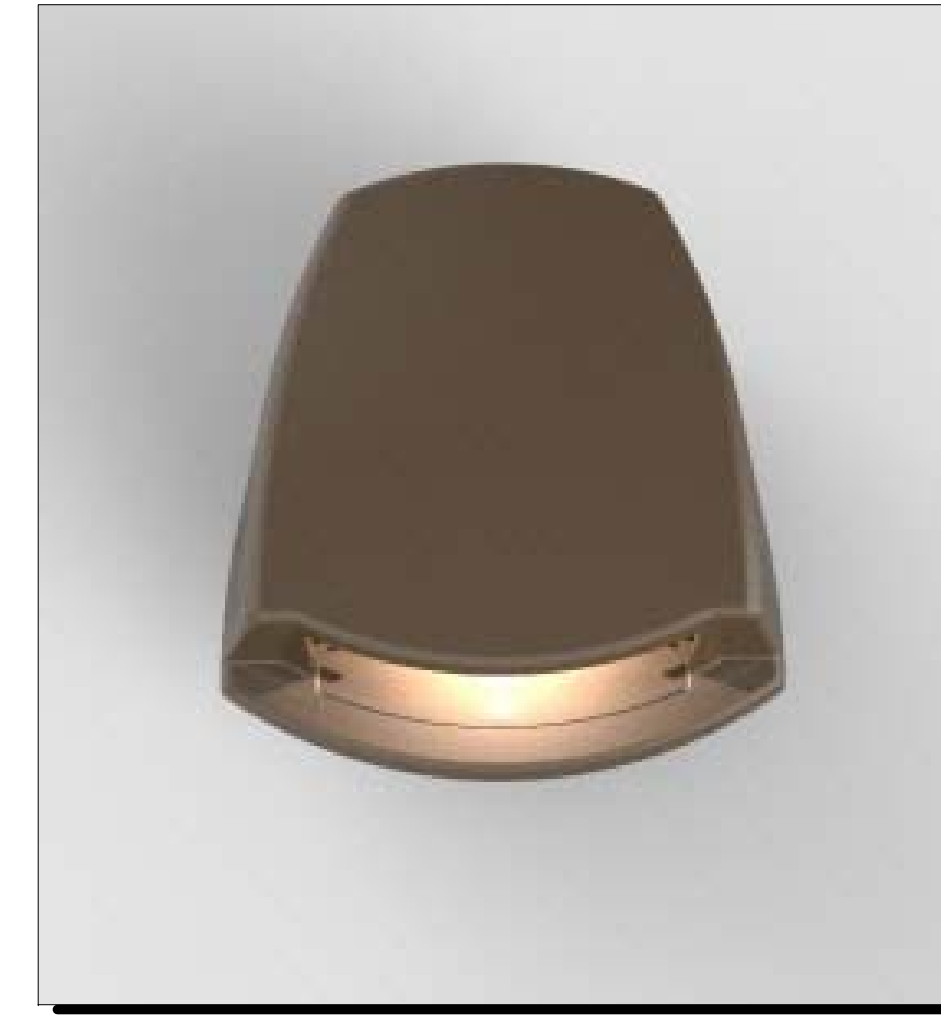

TYPE W2



TYPE B5R



TYPE W1

PRELIMINARY

MUNJOY STREET
PORTLAND, ME
SITE LIGHTING LAYOUT

DATE: 11/30/2015

GENERATED FOR:
BILD ARCHITECTURE
SCALE: NOT TO SCALE
FILE: im_site.dwg
Page 1 of 1



NOTICE: THIS DRAWING IS THE EXCLUSIVE PROPERTY OF SWANEY LIGHTING ASSOCIATES. IT IS NOT TO BE REPRODUCED, COPIED, OR TRANSMITTED IN ANY FORM OR BY ANY MEANS, ELECTRONIC OR MECHANICAL, WITHOUT THE WRITTEN PERMISSION OF SWANEY LIGHTING ASSOCIATES. THIS DRAWING IS TO BE USED FOR THE PROJECT AND SITE SPECIFICALLY IDENTIFIED IN THE TITLE BLOCK. IT IS NOT TO BE USED FOR ANY OTHER PROJECT OR SITE WITHOUT THE WRITTEN PERMISSION OF SWANEY LIGHTING ASSOCIATES. NOTICE: THE INTENT OF THIS LIGHTING LAYOUT IS TO SUGGEST THE BEST UTILIZATION OF LIGHTING FIXTURES AND NOT TO GUARANTEE THE BEST UTILIZATION. PERFORMANCE SHOWN IN THIS FILE IS NOT THE RESPONSIBILITY OF THE MANUFACTURER. IT'S USE FOR ANY OTHER PURPOSES IS NOT AUTHORIZED BY SWANEY LIGHTING ASSOCIATES.