



1ST FLOOR PLAN  
SCALE 1/4" = 1'-0"

NOTE: SMOKE ALARMS TO BE INSTALLED TO MEET 2014 IBC CODE REQUIREMENTS  
NOTE: CARBON MONOXIDE ALARMS TO BE INSTALLED TO MEET 2014 IBC CODE REQUIREMENTS

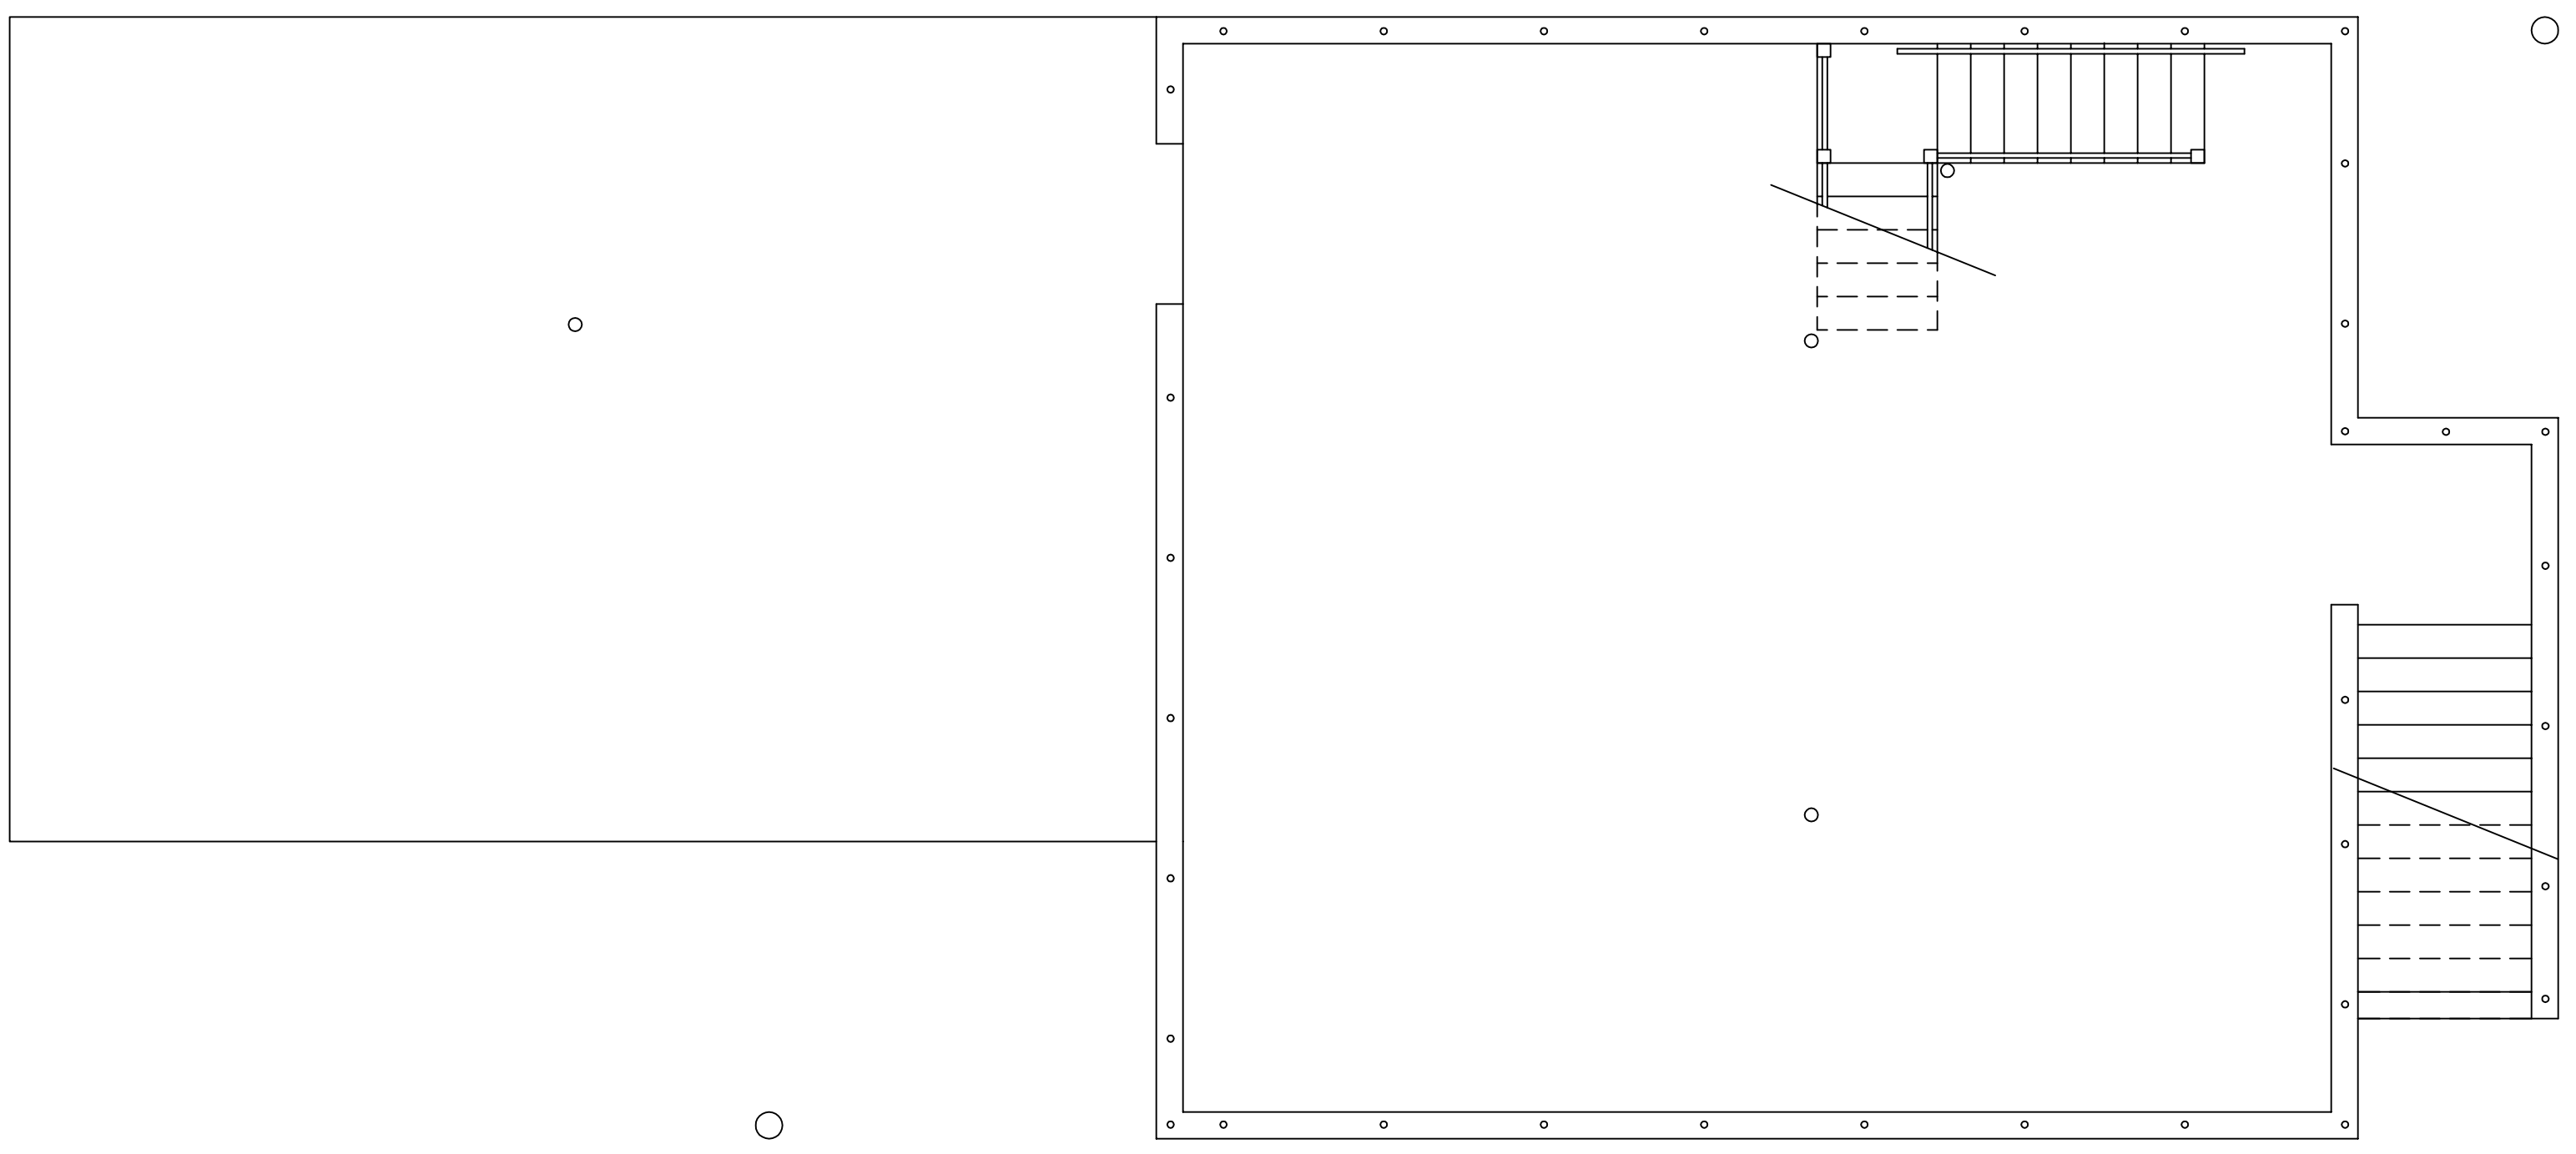

BASEMENT PLAN  
SCALE 1/4" = 1'-0"

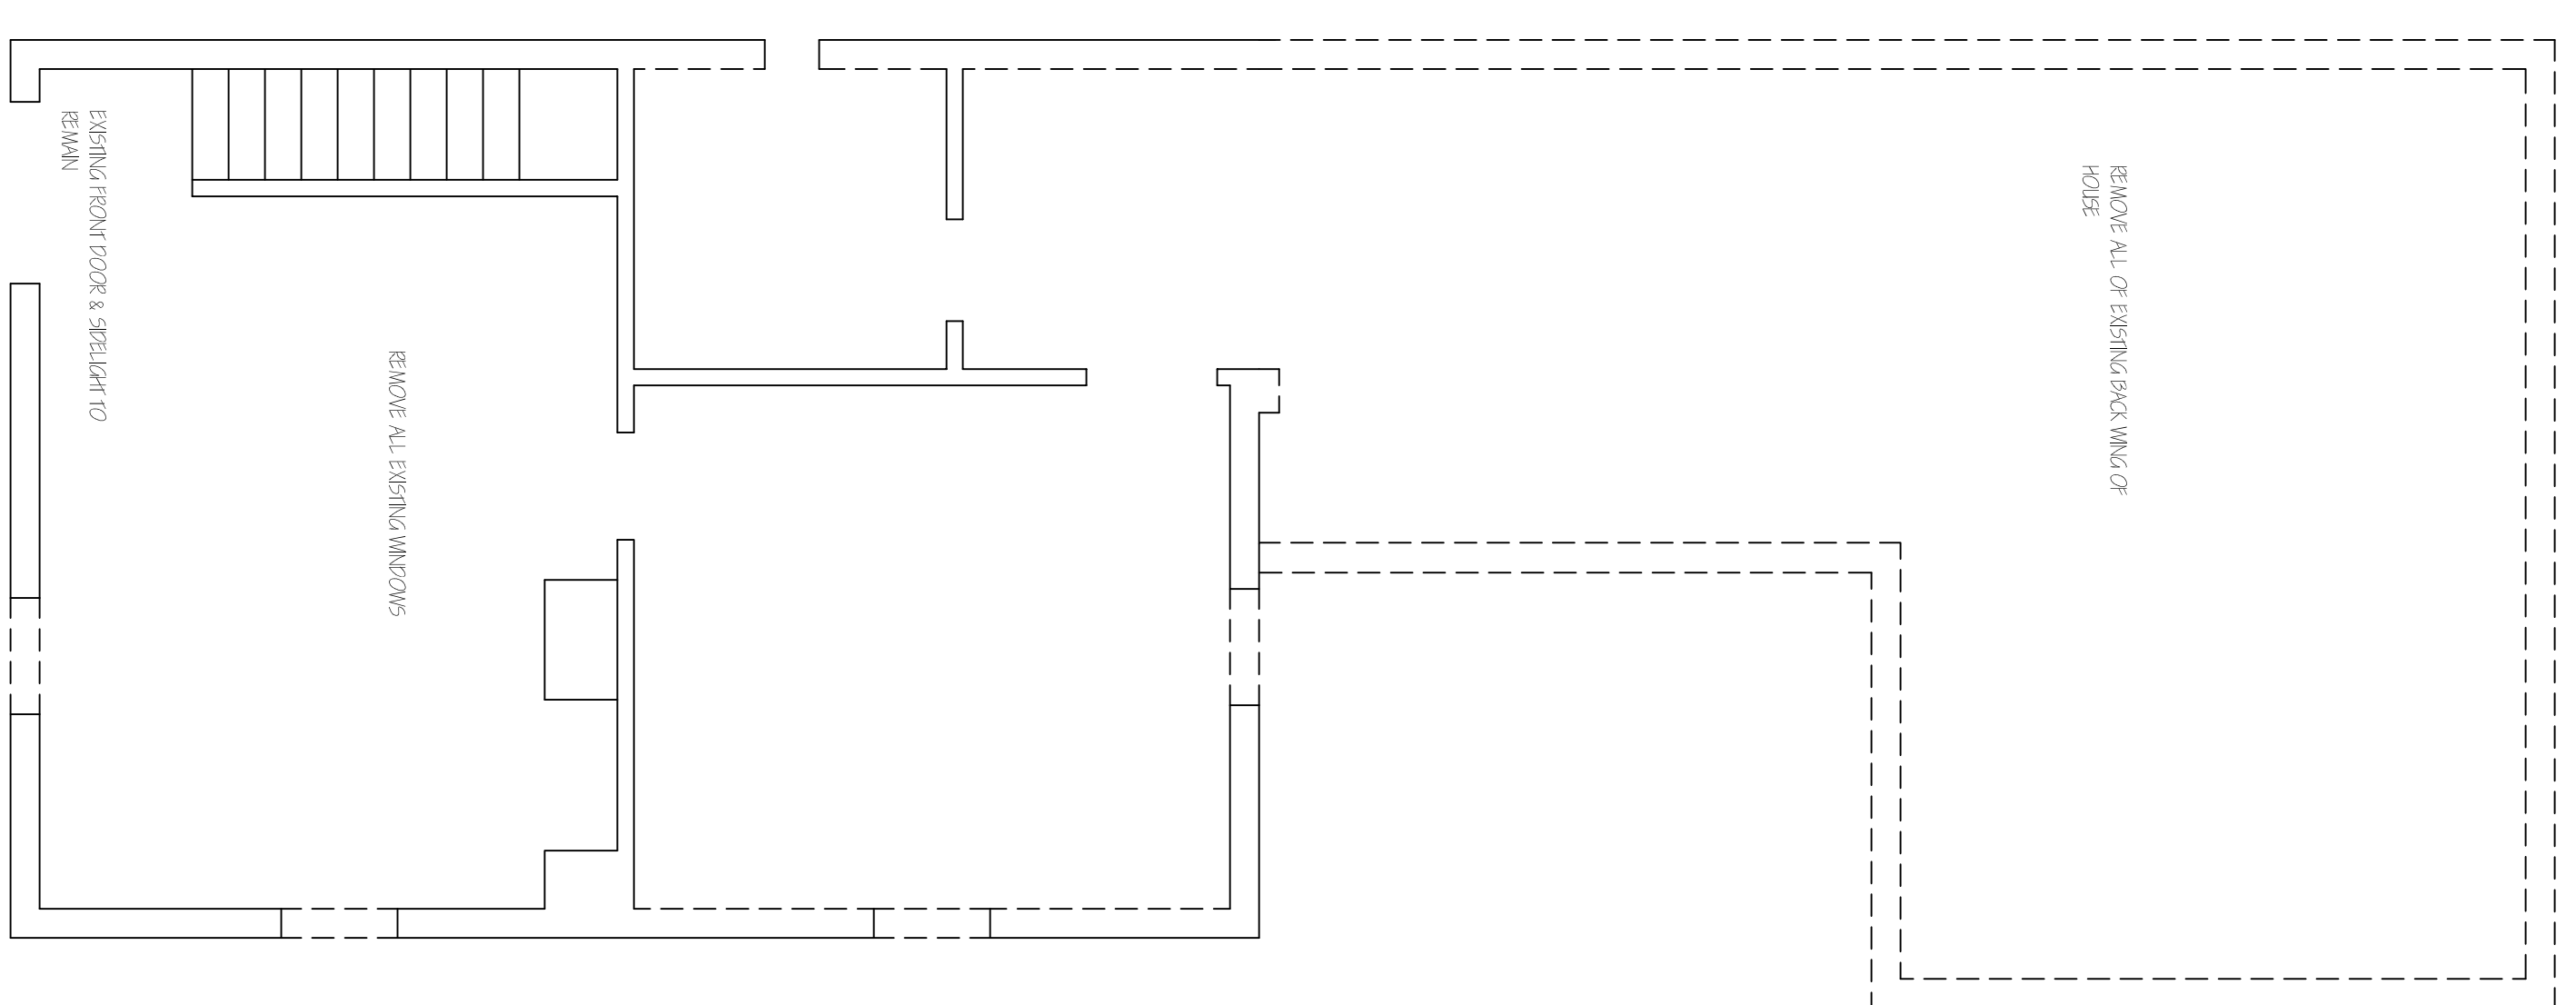

1ST FLOOR DEMOLITION PLAN  
SCALE 1/8" = 1'-0"