



2 SECOND FLOOR ELECTRICAL PLAN  
SCALE: 1/4" = 1'-0"


- LIFE SAFETY SYMBOLS**
- S SMOKE DETECTOR
  - CO CARBON MONOXIDE DETECTOR
  - E ELECTRICAL SYMBOLS- "E" BESIDE SYMBOL DENOTES EXISTING ROUGH ELECTRICAL WORK
  - ⊕ DUPLEX OUTLET 18" A.F.F. UNLESS NOTED OTHERWISE "WP" INDICATES WATERPROOF OUTLET PROVIDE GFI WHERE NOTED
  - ⊕⊕ DOUBLE DUPLEX OUTLET 18" A.F.F. UNLESS NOTED OTHERWISE "WP" INDICATES WATERPROOF OUTLET PROVIDE GFI WHERE NOTED
  - ⊕⊕ SPECIAL PURPOSE POWER OUTLET - CONSULT OWNER - RE STOVE, MICROWAVE, DISPOSAL
  - ▽ WALL PHONE JACK 18" A.F.F. UNLESS NOTED OTHERWISE
  - CTV CABLE TV IF REQ'D - ASK OWNER
  - SW SWITCH
  - 3SW THREE-WAY SWITCH
  - CI COMPUTER - CONSULT OWNER - RE INTERNET CONNECTION
  - ⊕ DUPLEX FLOOR OUTLET
  - ⊕ CEILING FAN
  - ⊕ LIGHT & EXHAUST FAN
  - DB DOOR BELL
- LIGHTING SYMBOLS**
- ⊕ RECESSED CAN FIXTURE- LED WARM LIGHT TYPICAL
  - 2 WALL SCONCE
  - 3 EXTERIOR WALL SCONCE
  - 4 UTILITY LIGHT
  - ⊕ SURFACE MOUNTED FIXTURE
  - ⊕ PENDANT
  - MOTION MOTION ACTIVATED STRIP LIGHT- CLOSET OR UNDERCOUNTER

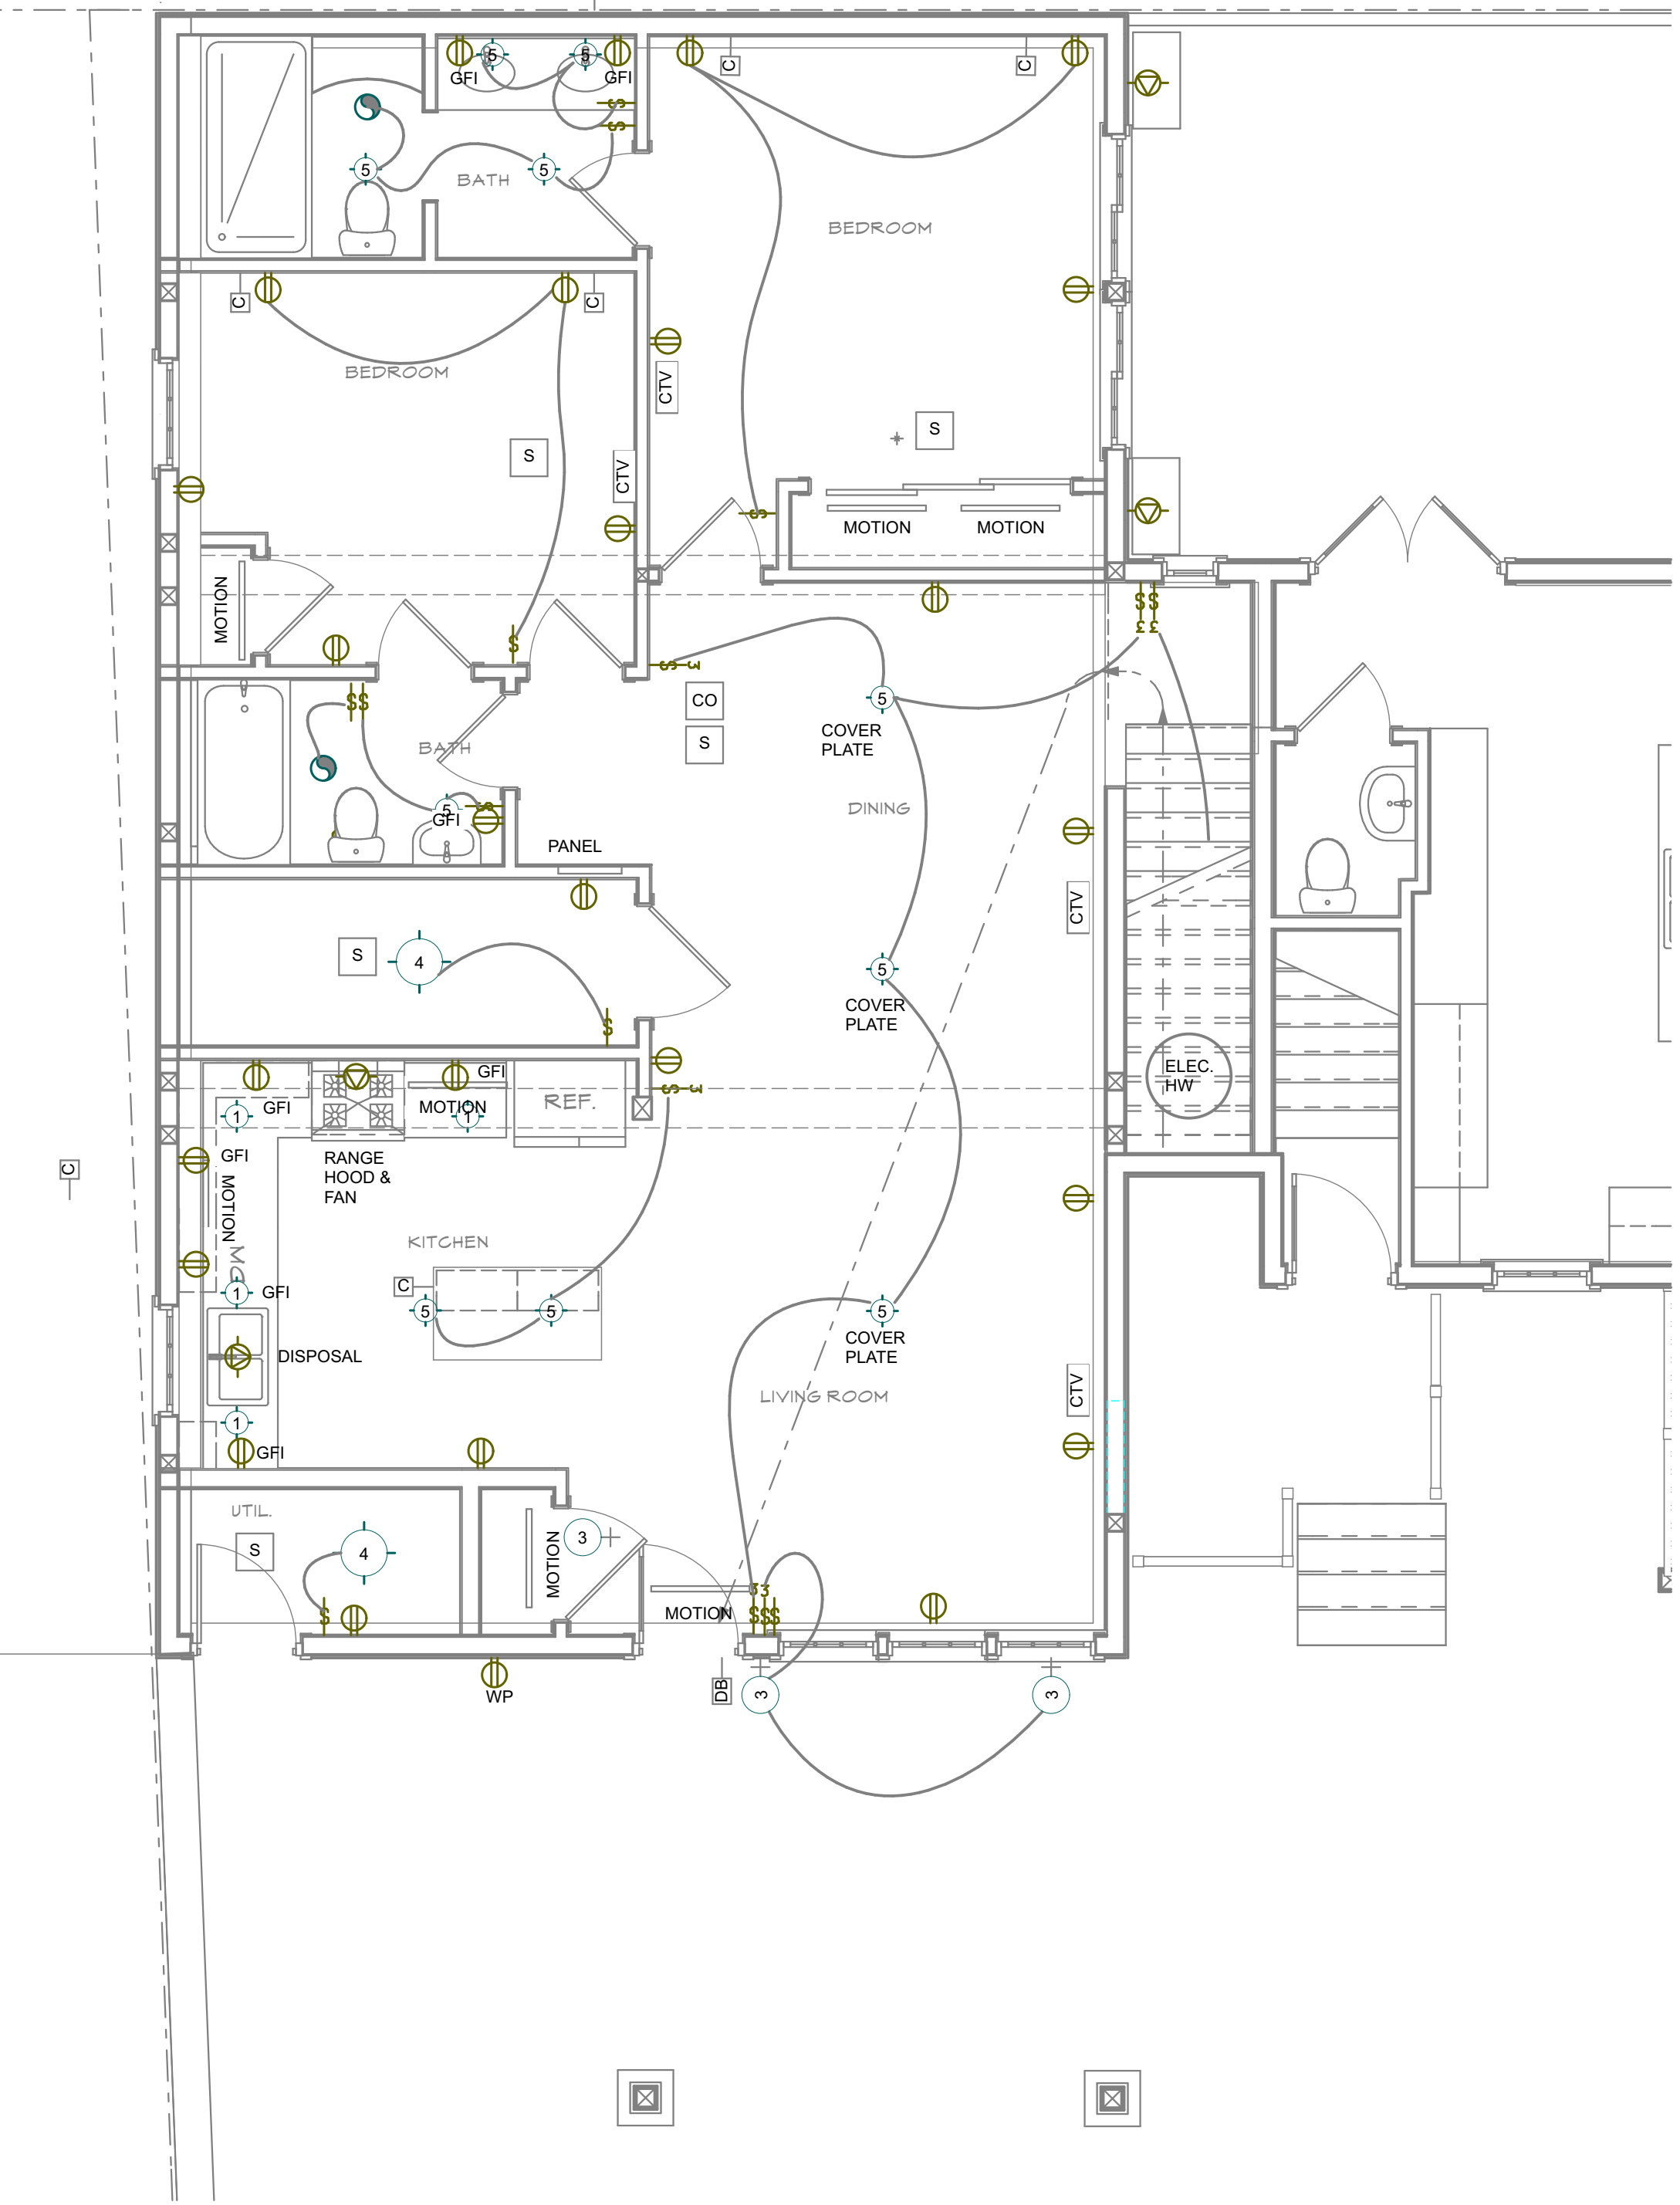

1 GROUND FLOOR ELECTRICAL PLAN  
SCALE: 1/4" = 1'-0"

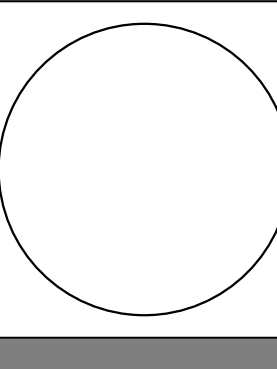

WHIPPLE  
CALLENDER  
ARCHITECTS

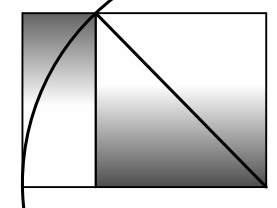

136 PLEASANT AVE.  
PORTLAND, ME 04103  
P 207.775.2696  
F 207.775.3631  
www.whipplecallender.com

MARK	DATE	DESCRIPTION
1	11.13.17	REVISION #1 - PERMIT REV.

DATE: 1/8/18  
CHECKED BY: JAD  
DRAWN BY: CLBC  
JOB: EAP 2017  
SHEET TITLE:

ELECTRICAL  
PLANS

CITY OF PORTLAND PERMIT REVIEW  
SET- (REVISED 11/13/17)

THIS DRAWING IS AN INSTRUMENT OF SERVICE AND SHALL REMAIN THE PROPERTY OF WHIPPLE CALLENDER ARCHITECTS. IT SHALL NOT BE USED FOR ANY OTHER PURPOSE THAT FOR WHICH IT IS SPECIFICALLY FURNISHED.