


GENERAL NOTES:

- REFER TO SHEET E60.01 FOR LIGHTING FIXTURE SCHEDULE.
- COORDINATE FINAL LOCATION OF NEW FIXTURES WITH OTHER DISCIPLINES AND INSTALLATION OF OVERHEAD OBSTRUCTIONS. (TYP)
- FIXTURES SHOWN WITH "X" SHALL BE PROVIDED WITH EMERGENCY BATTERY PACK. REFER TO SCHEDULE ON SHEET E60.01 FOR DETAILS. WIRE UNSWITCHED LEG OF LIGHTING CKT TO BATTERY PACK.


 
KEYED NOTES:

- COORDINATE FINAL LOCATION OF ALL LIGHT FIXTURES W/FINAL LOCATION OF EQUIPMENT, HVAC DUCT WORK, CONDUIT AND PIPING. FIXTURES SHALL BE HUNG AT MAXIMUM UNIFORM HEIGHT AFF.
- CONNECT EXIT SIGN TO UNSWITCHED SIDE OF LOCAL LIGHTING CIRCUIT. MOUNT ABOVE DOORWAYS. (TYP. OF 2)

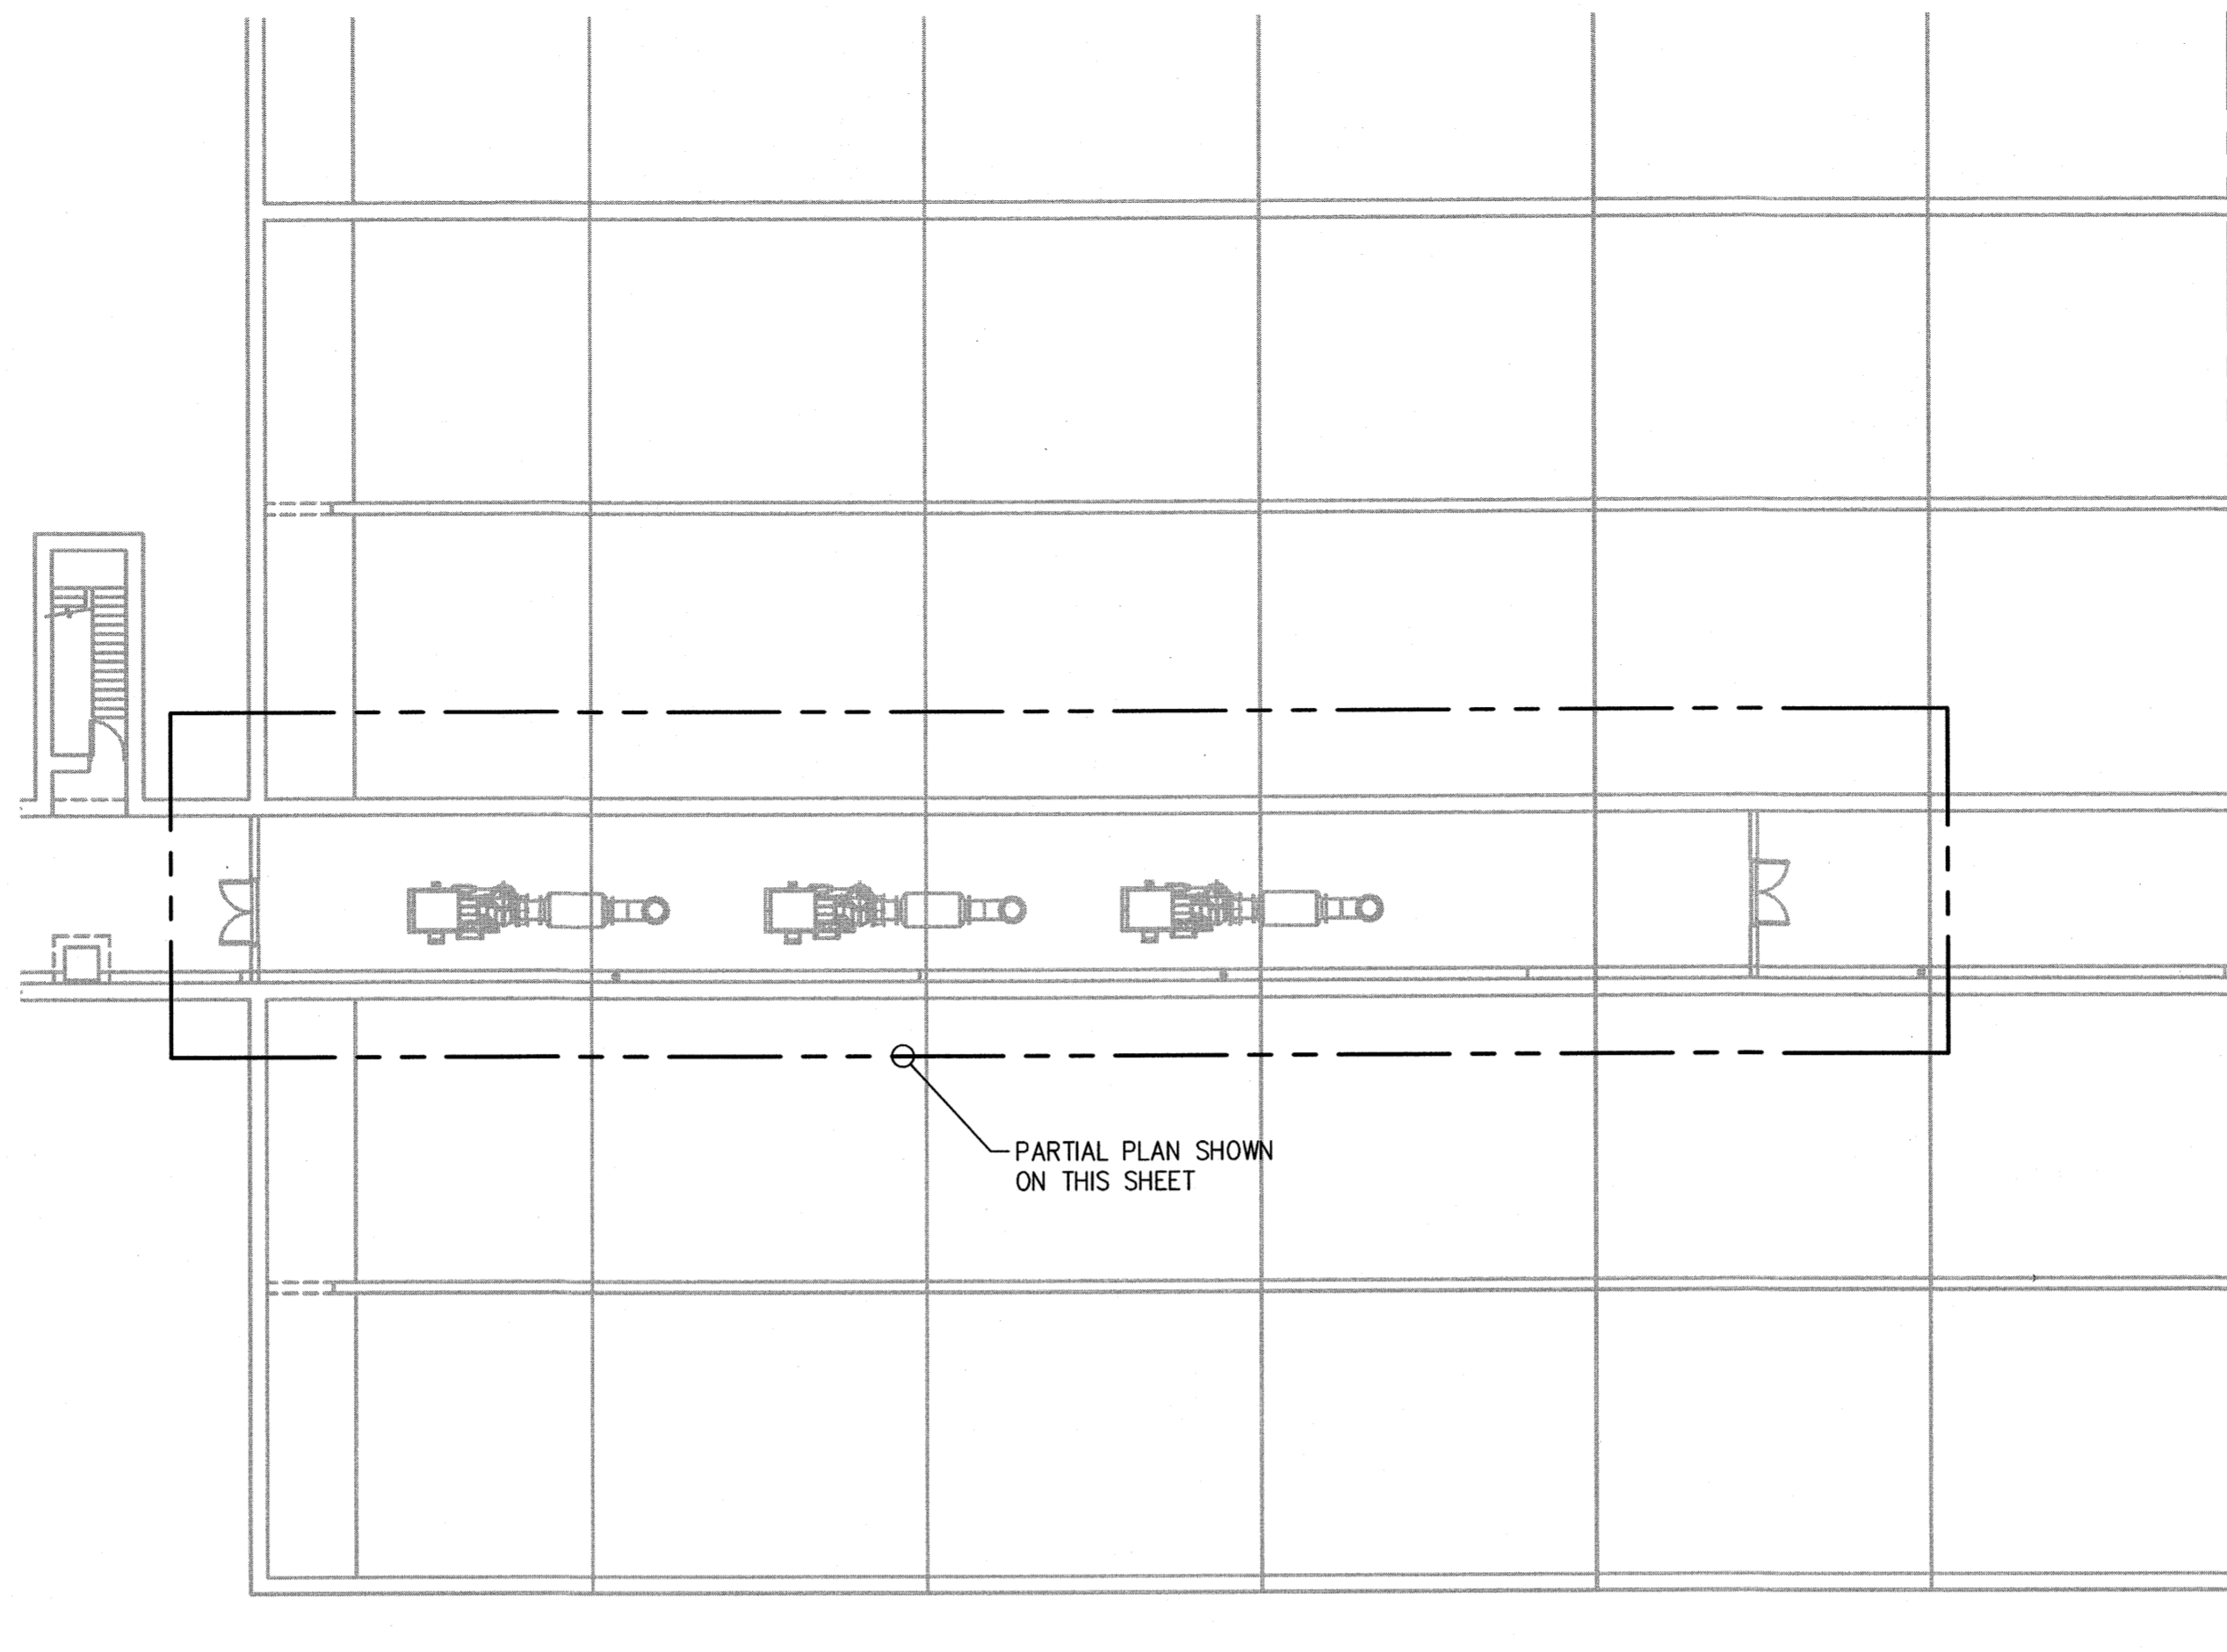


SEE SHT. E20.01

TUNNEL BLOWER ROOM
1/16" = 1'-0"

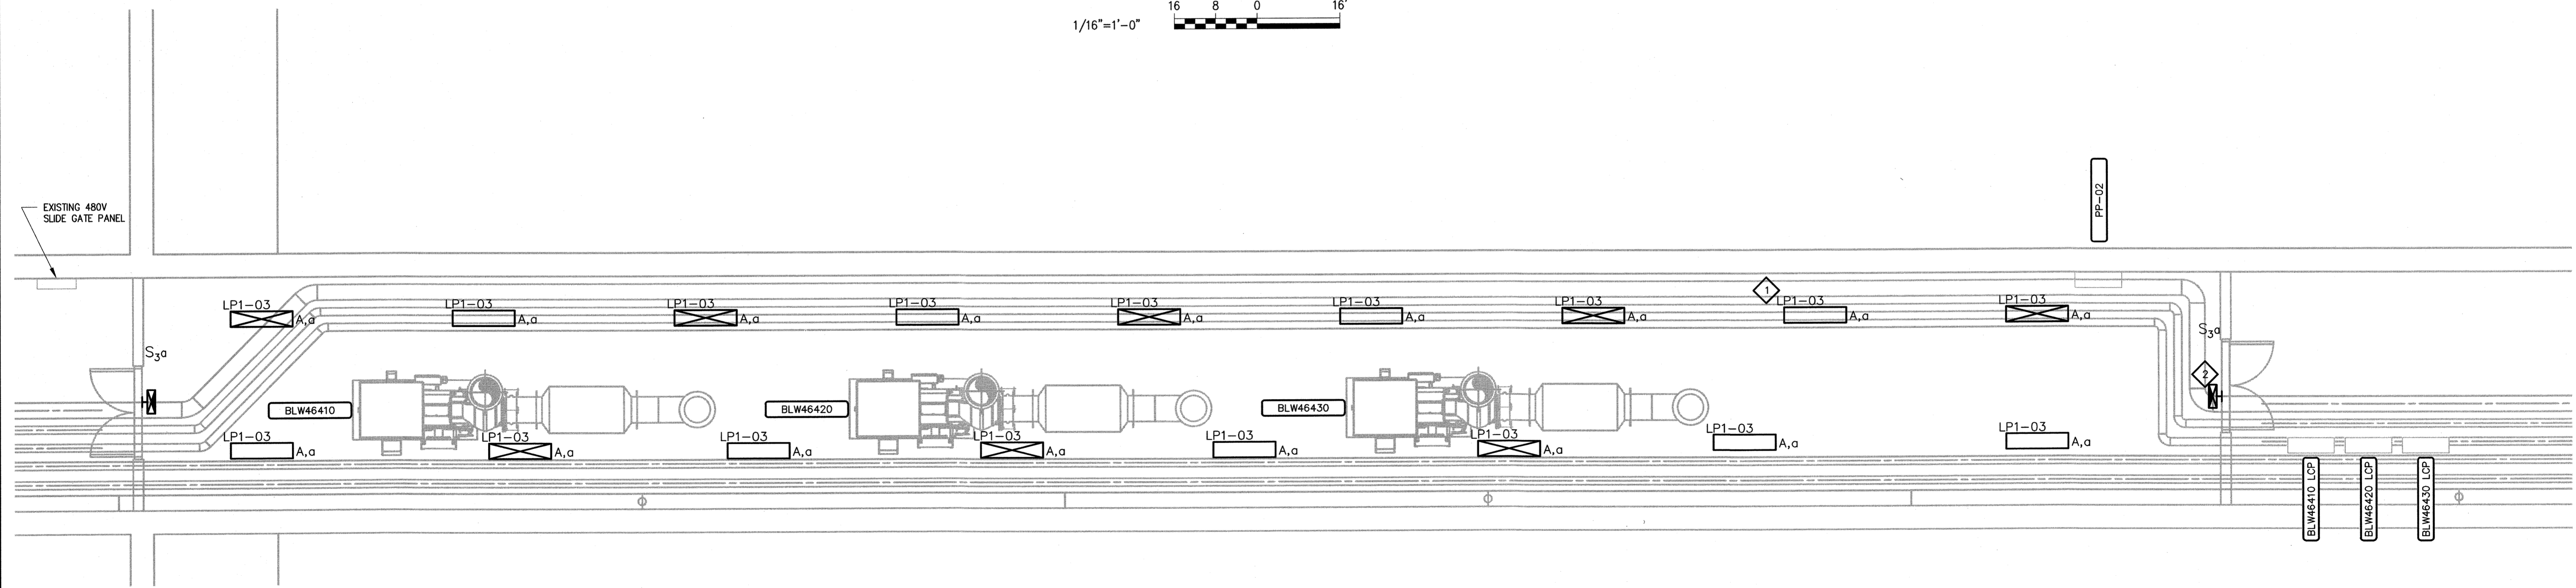

 TUNNEL BLOWER ROOM PARTIAL PLAN
3/16" = 1'-0"




P:\PROJECTS\227790\Drawings\Electrical\227790 E20.02.dwg
 LAST SAVED By: adams
 PLOT DATE: May 19, 2015 5:21pm By: SADMMS

DESIGNED	PFH		
DRAWN	SAA		
CHECKED	AJF		
PROJ. ENGR.	BIL		
NO.	DATE	ISSUED FOR	BY
1	MAY 2015	CONSTRUCTION	BIL

HAZEN AND SAWYER
Environmental Engineers & Scientists
HAZEN AND SAWYER, P.C.
24 FEDERAL STREET 5TH FLOOR - BOSTON, MA 02110

WOODARD & CURRAN
41 Hutchins Drive | Portland, Maine 04102
800.426.4262 | www.woodardcurran.com
COMMITMENT & INTEGRITY
DRIVE RESULTS

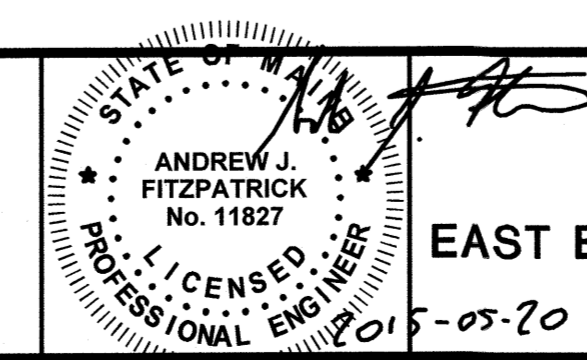

PORTLAND WATER DISTRICT
PORTLAND, MAINE
EAST END WASTEWATER TREATMENT FACILITY
AERATION UPGRADE

ELECTRICAL
TUNNEL BLOWER ROOM
LIGHTING PLAN

DATE	MAY 2015
DWG. NO.:	E20.02
SHEET NO.:	82
FILE NAME:	227790 E20.02