



FIRST FLOOR — SCREENINGS ROOM  
POWER PLAN  
SCALE: 1/8" = 1'-0"

**NOTES:**

1. FOR LEGEND AND GENERAL NOTES, SEE DRAWING E-1.
2. REFER TO DRAWING E-14 FOR PANELBOARD SCHEDULE.

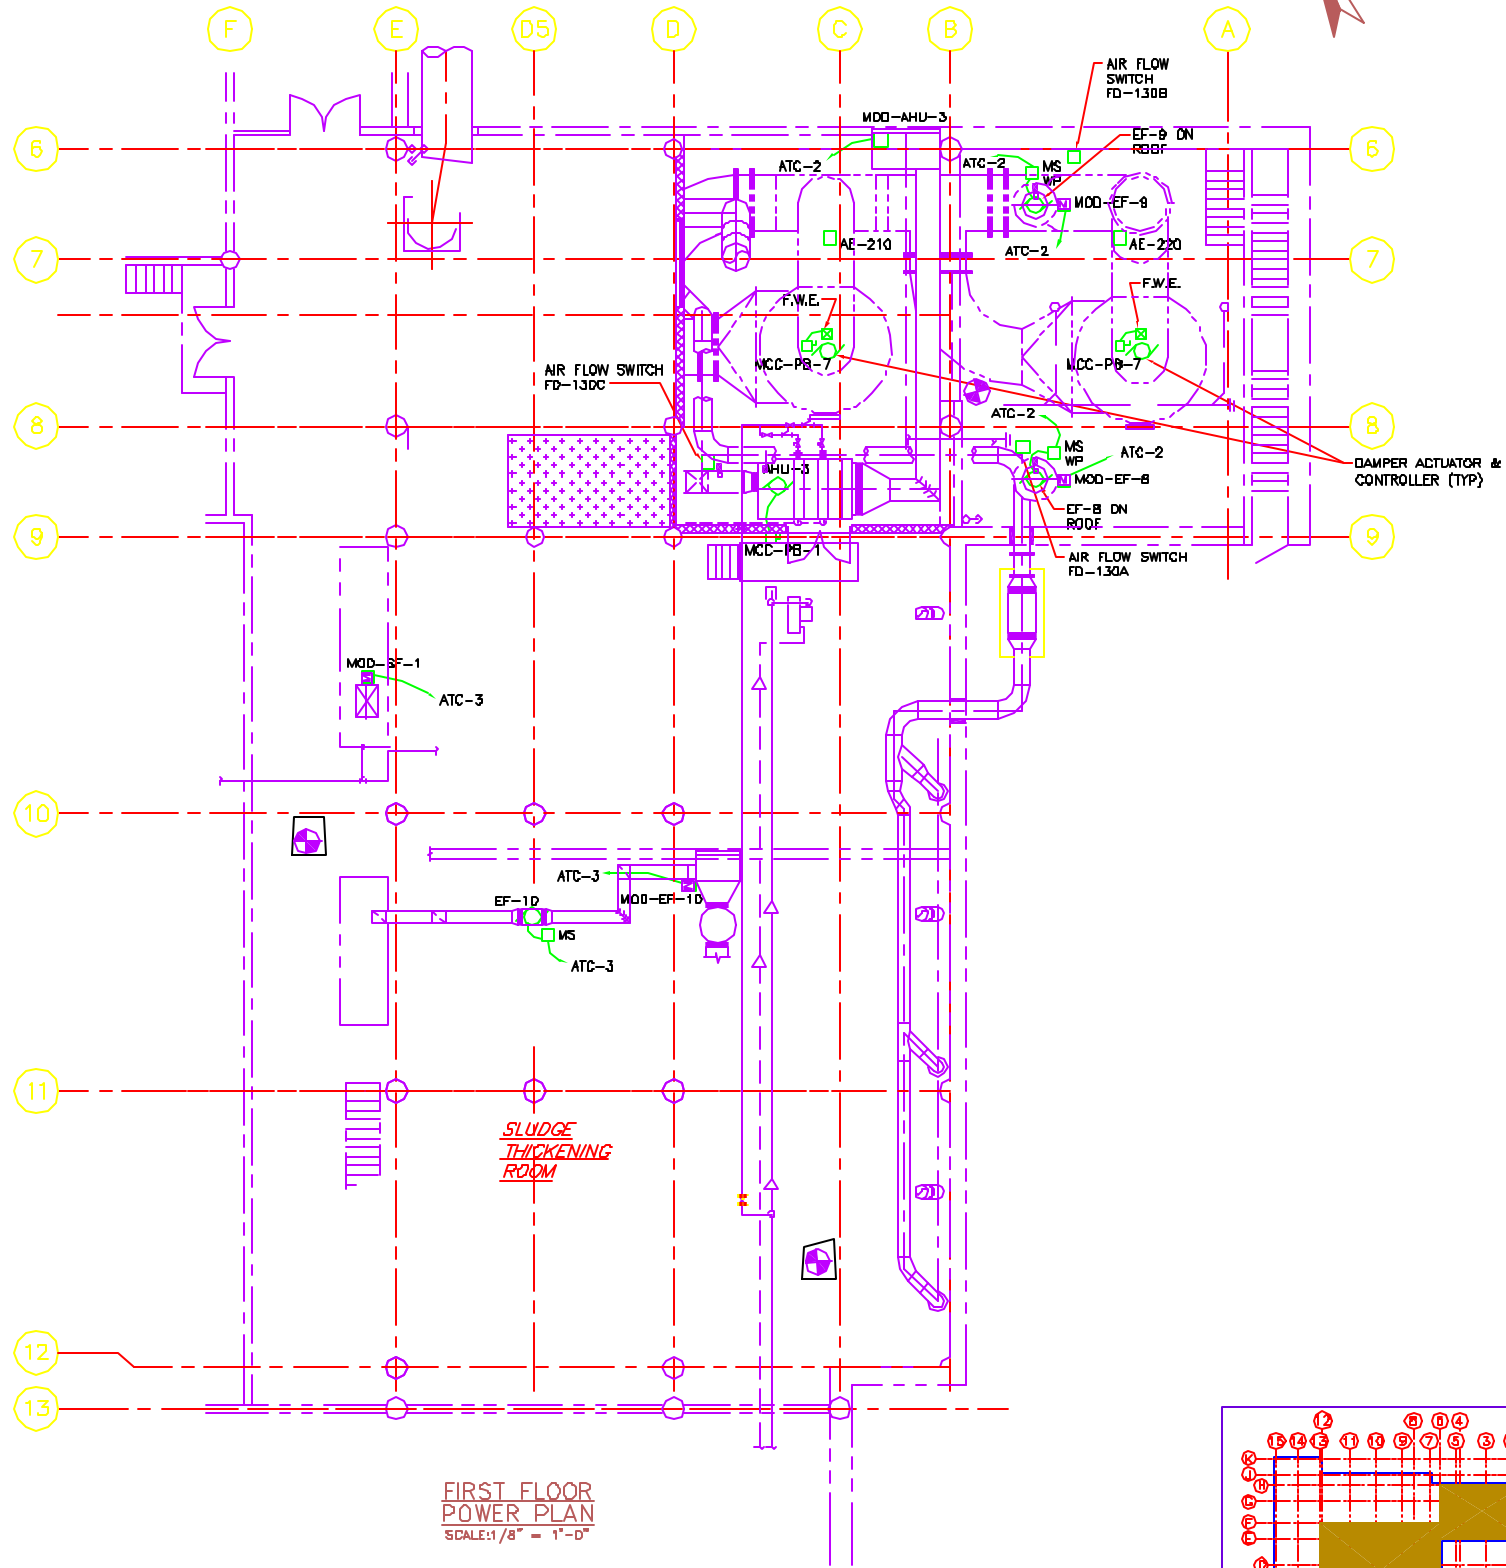

FIRST FLOOR  
POWER PLAN  
SCALE: 1/8" = 1'-0"

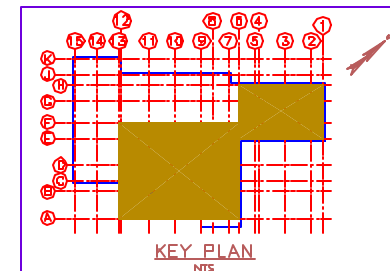

| NO. | REVISIONS | DATE | BY | DESCRIPTION |
|-----|-----------|------|----|-------------|
| 1   |           |      |    |             |
| 2   |           |      |    |             |
| 3   |           |      |    |             |
| 4   |           |      |    |             |
| 5   |           |      |    |             |
| 6   |           |      |    |             |
| 7   |           |      |    |             |
| 8   |           |      |    |             |
| 9   |           |      |    |             |
| 10  |           |      |    |             |
| 11  |           |      |    |             |
| 12  |           |      |    |             |
| 13  |           |      |    |             |

|                    |                     |
|--------------------|---------------------|
| DRAWN BY: S.M.     | PROJECT NO.: 27553A |
| CHECKED BY: J.P.   | DATE: 3-1-01        |
| DATE: 3-1-01       | SCALE: AS NOTED     |
| APPROVED BY: J.P.  |                     |
| DATE: 3-1-01       |                     |
| BOOK NO.: 75 OF 79 |                     |
| DATE: 3-1-01       |                     |
| FILE NO.: 75 OF 79 |                     |
| DATE: 3-1-01       |                     |
| FILE NAME:         |                     |

|  |  |
|--|--|
| PORTLAND WATER DISTRICT<br>PORTLAND, MAINE<br>PRIMARY SEDIMENTATION BASINS<br>UPGRADE WITH ODOR CONTROL FACILITIES<br>EXISTING PROCESS BUILDING<br>FIRST FLOOR POWER PLANS | Wright-Pierce<br>99 Main Street<br>Topsham, Maine USA 04086<br>TEL (207) 725-8721 FAX (207) 725-8414 |
|--|--|