



NOTES:

1. SEE E0.0 FOR LEGEND, ABBREVIATIONS AND GENERAL NOTES.

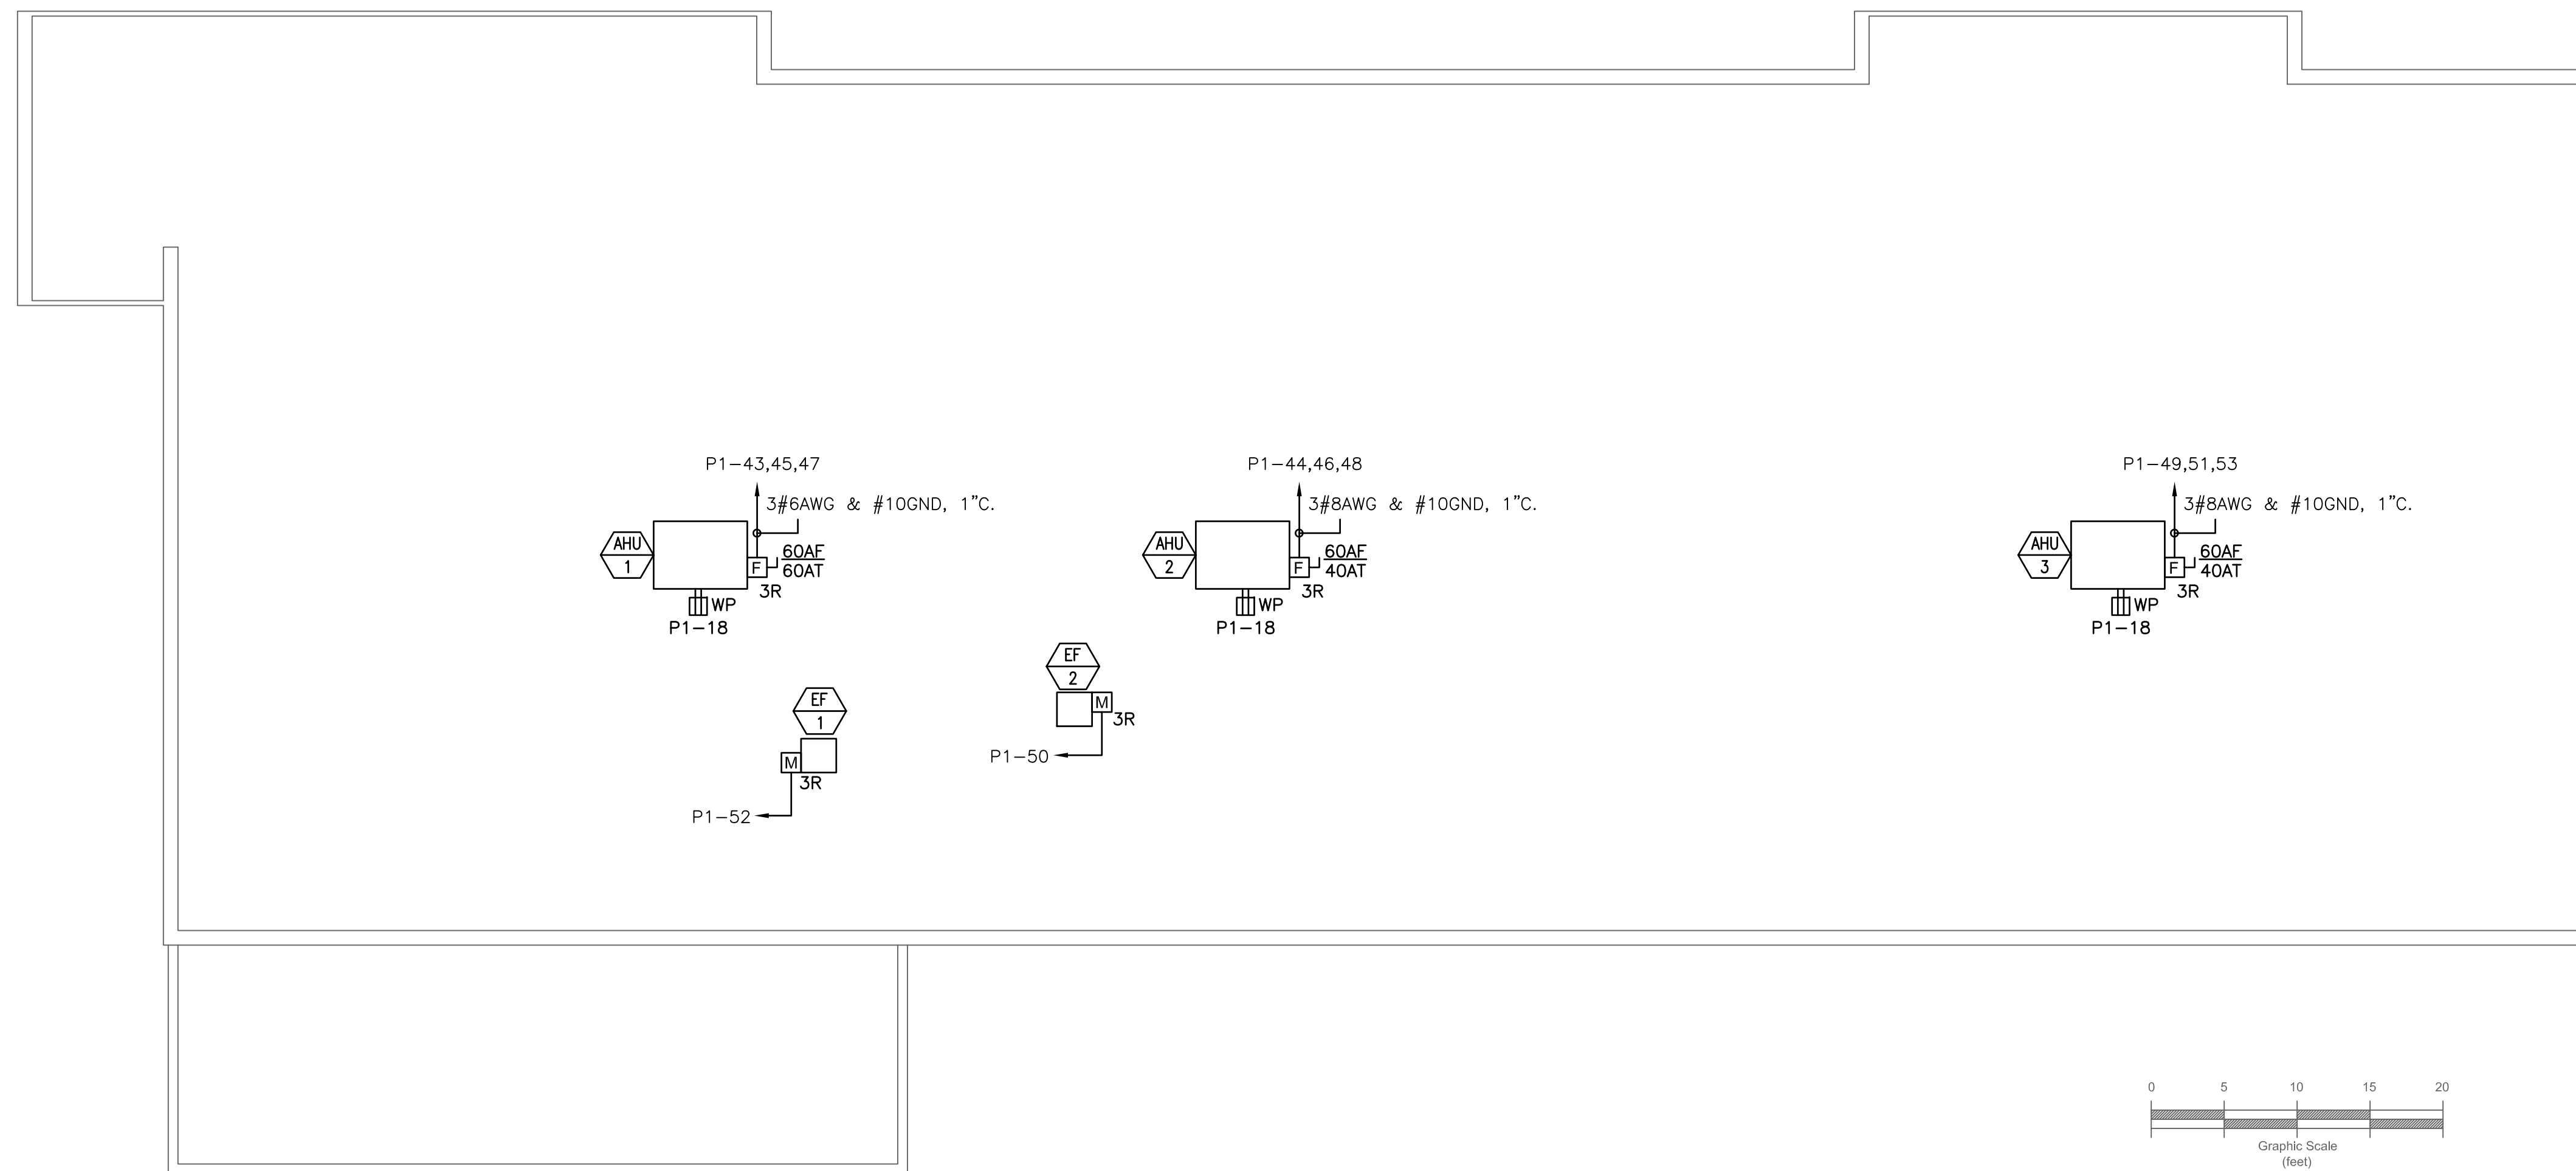

1 ELECTRICAL POWER & SYSTEMS – ROOF PLAN
SCALE: 1/8" = 1'-0"

ISSUE FOR CONSTRUCTION

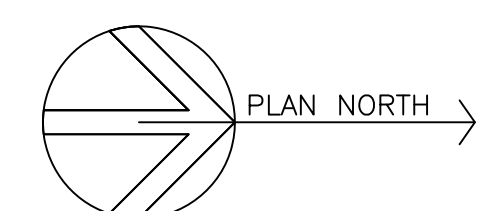

<p>9/4/14</p>	<p>ROBERT J. FOSTER ARCHITECT 36 Groveside Road, Portland, Maine 04102 (207) 761-3822</p>	<p>U-HAUL MOVING & STORAGE 425 MARGINAL WAY Portland, Maine</p>	<table border="1"> <tr> <td>09 - 1 - 14</td> <td>ISSUE FOR CONSTRUCTION</td> </tr> <tr> <td>07 - 18 - 14</td> <td>PROGRESS DRAWING</td> </tr> <tr> <td>Mark</td> <td>Date</td> <td>Description</td> </tr> <tr> <td colspan="3">Issue Dates</td> </tr> </table>	09 - 1 - 14	ISSUE FOR CONSTRUCTION	07 - 18 - 14	PROGRESS DRAWING	Mark	Date	Description	Issue Dates			<p>Drawing Title</p> <p>ELECTRICAL POWER & SYSTEMS - ROOF PLAN</p>
				09 - 1 - 14	ISSUE FOR CONSTRUCTION									
07 - 18 - 14	PROGRESS DRAWING													
Mark	Date	Description												
Issue Dates														
			<p>Drawing Number</p> <p>E1.1</p>											