




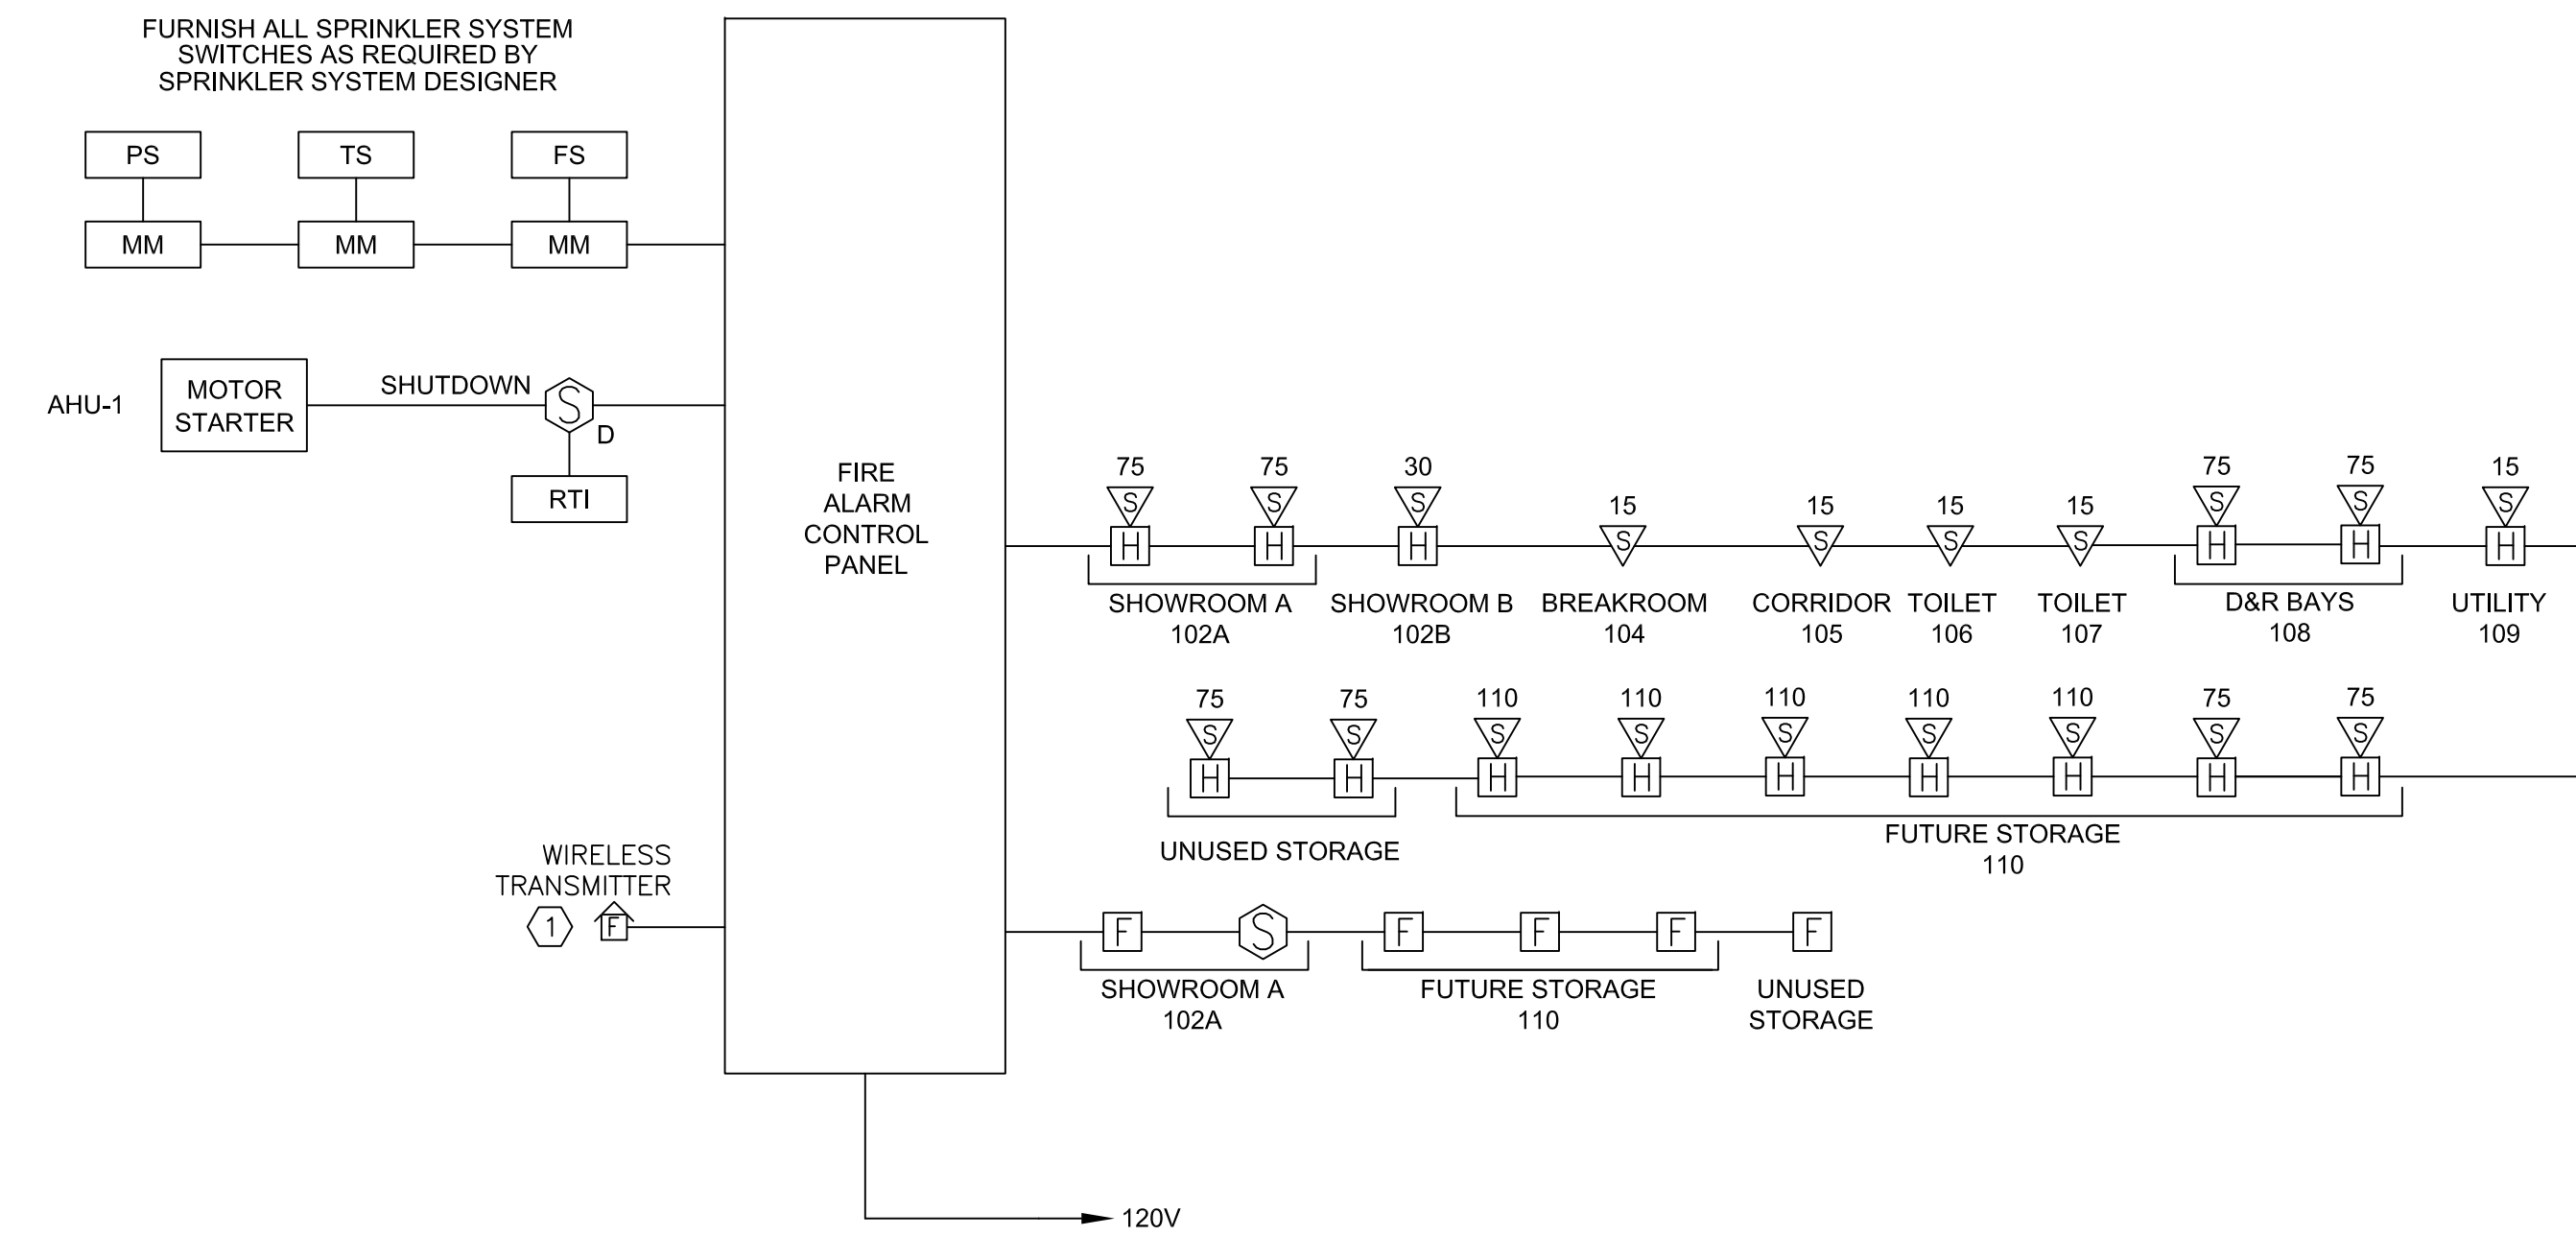


KEYED NOTES:



① CONTRACTOR TO FURNISH AES WIRELESS TRANSMITTER MODEL 7788, 12V/7AH STANDBY BATTERY, 1640 PLUG-IN TRANSFORMER, SENTROL TAMPER SWITCH TO ALLOW SERVICING WITHOUT SENDING SYSTEM INTO ALARM. SYSTEM SHALL BE TO CITY OF PORTLAND STANDARD AND COORDINATED WITH DICK ANDREWS, PORTLAND FIRE DEPARTMENT.

LIGHTING SCHEDULE					
TYPE	DESCRIPTION	MANUFACTURER	LAMPS	MOUNTING	NOTES
A	2'X4' FLUORESCENT LENSED TROFFER 120V	COLUMBIA LIGHTING	(2)-T8 32W	CEILING GRID	MODEL #: JT824-232G-FSA12-EU
B	8' FLUORESCENT WITH REFLECTOR 120V	COLUMBIA LIGHTING	(2)-T8 32W	CEILING SUSPENDED	MODEL #: CSR8-232-ST-EU
C	6" LED DOWNLIGHT CLEAR ALZACK REFLECTOR & WHITE TRIM 120V	PRESCOLITE	32W LED 3500K 2000 LUMENS	CEILING RECESSED	MODEL #: HOUSING: LF6LED TRIM: 6LFLED7-35K-WT
AA	6" WET LOCATION LED DOWNLIGHT WITH WHITE REFLECTOR & WHITE TRIM. 120V	PRESCOLITE	32W LED 4000K 2000 LUMENS	CEILING RECESSED	MODEL #: HOUSING: LF6LEDG4 TRIM: 6LFLED7G4-40K-WH-WT
BB	18" ARCHITECTURAL WALLPACK 120V	SPAULDING	36W LED 4700K 2500 LUMENS	WALL SURFACE	MODEL #: RTP-20LU-5K-2-050-WH-PC1
CC	16" WALLPACK WITH FORWARD THROW 120V	SPAULDING	71W LED 4000K 4673 LUMENS	WALL SURFACE	MODEL #: LMC-30LU-4K-3-4-PC(1)
DD	EXTERIOR DOOR LIGHT W/ BATTERY BACK-UP FOR EMERGENCY EGRESS. WET LOCATION LISTED & COLD WEATHER PACKAGE. BLACK FINISH. 120V	MULE LIGHTING	12W LED 5000K 425 LUMENS	WALL SURFACE	MODEL #: MAKO-LED-ACEM-BK-IH
 C	CEILING MOUNTED DUAL TECHNOLOGY ULTRASONIC AND PASSIVE INFRARED OCCUPANCY SENSOR 120V	HUBBELL	N/A	CEILING SURFACE	MODEL #: OMNIDT500 FURNISH RELAYS/POWER PACKS AS REQUIRED FOR A COMPLETE AND OPERABLE INSTALLATION
 W	WALL MOUNT PASSIVE INFRARED OCCUPANCY SENSOR 120V	HUBBELL	N/A	WALL	MODEL #: LHIRS11
	EMERGENCY BATTERY UNIT 120V	DUAL-LITE	(2) 10 WATT HALOGEN	WALL SURFACE	MODEL #: LZ2N
 WP	WEATHER PROOF REMOTE HEAD 120V	DUAL-LITE	(1) 10 WATT HALOGEN	WALL SURFACE	MODEL #: LZRSW0610
	LED EXIT SIGN EMERGENCY BATTERY UNIT COMBINATION 120V	DUAL-LITE	(2) 5 WATT HALOGEN	CEILING SURFACE	MODEL #: LTRW3




1 FIRE ALARM RISER DIAGRAM  
SCALE: NOT TO SCALE

ISSUE FOR CONSTRUCTION

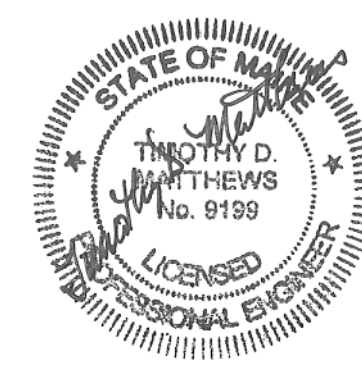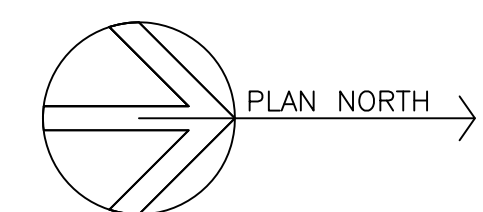

9/4/14

ROBERT J. FOSTER ARCHITECT  
36 Groveside Road, Portland, Maine 04102  
(207) 761-3822

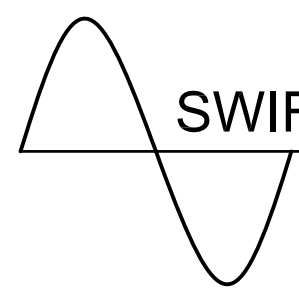 SWIFTCURRENT  
Engineering Services  
10 Forest Falls Drive, Unit 4B  
Yarmouth, ME 04096  
Tel: (207) 847-9280

Project Title  
**U-HAUL MOVING & STORAGE**  
425 MARGINAL WAY  
Portland, Maine

Mark	Date	Description
	09 - 1 - 14	ISSUE FOR CONSTRUCTION
	07 - 18 - 14	PROGRESS DRAWING
Issue Dates		

Drawing Title  
**LIGHTING SCHEDULE  
FIRE ALARM RISER**

Drawing Number  
**E2.1**