


NOTES:

1. SEE E.O.0 FOR LEGEND, ABBREVIATIONS AND GENERAL NOTES.


MARGINAL WAY

PLOWMAN STREET

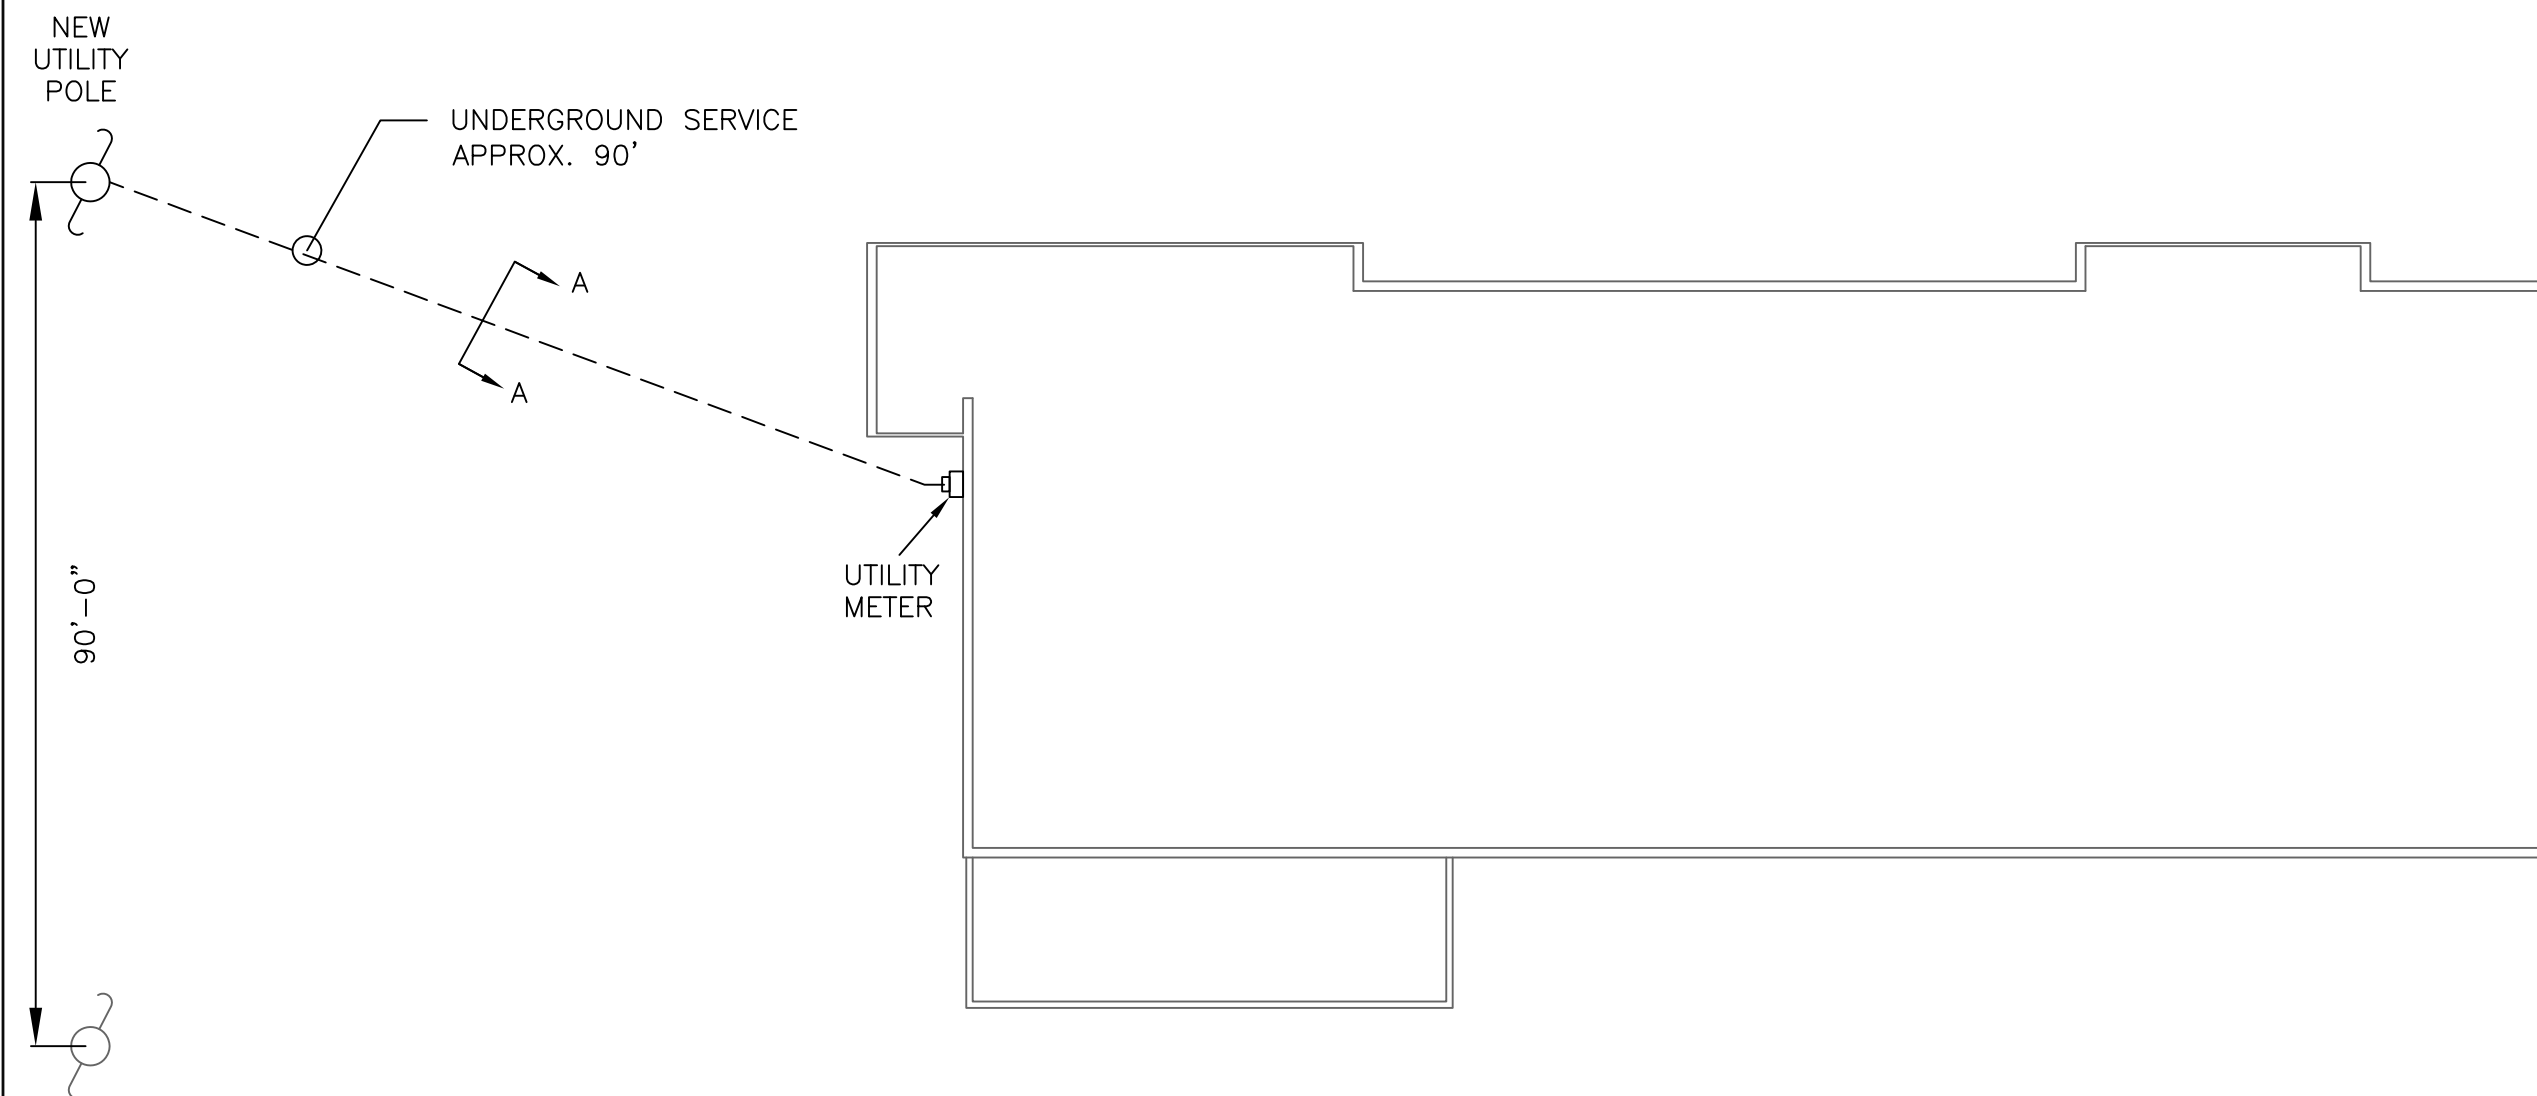


DUCT BANK KEY:

- C - CABLE TV
- PP - PRIMARY POWER
- T - TELEPHONE

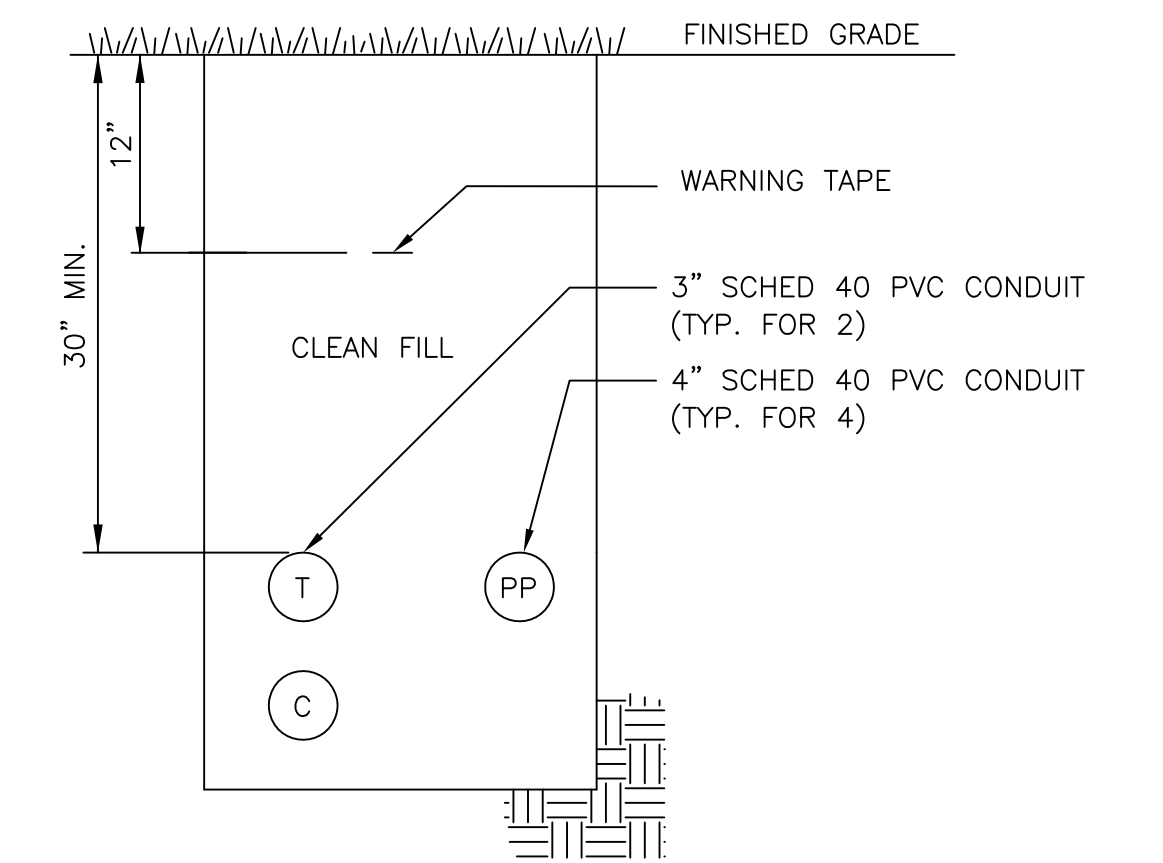

2 DUCT BANK SECTION A-A
SCALE: NOT TO SCALE

ISSUE FOR CONSTRUCTION

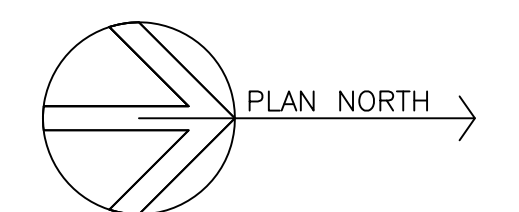

1 ELECTRICAL SITE PLAN
SCALE: 1"=10'



9/4/14

ROBERT J. FOSTER ARCHITECT
36 Groveside Road, Portland, Maine 04102
(207) 761-3822

SWIFTCURRENT
Engineering Services
10 Forest Falls Drive, Unit 4B
Yarmouth, ME 04096
Tel: (207) 847-9280

Project Title
U-HAUL MOVING & STORAGE
425 MARGINAL WAY
Portland, Maine

Mark	Date	Description
	09 - 1 - 14	ISSUE FOR CONSTRUCTION
	07 - 18 - 14	PROGRESS DRAWING
Issue Dates		

Drawing Title
ELECTRICAL SITE PLAN

Drawing Number
ES1.0