



49A SECTION DETAIL
A313 SCALE 3/4" = 1'-0"

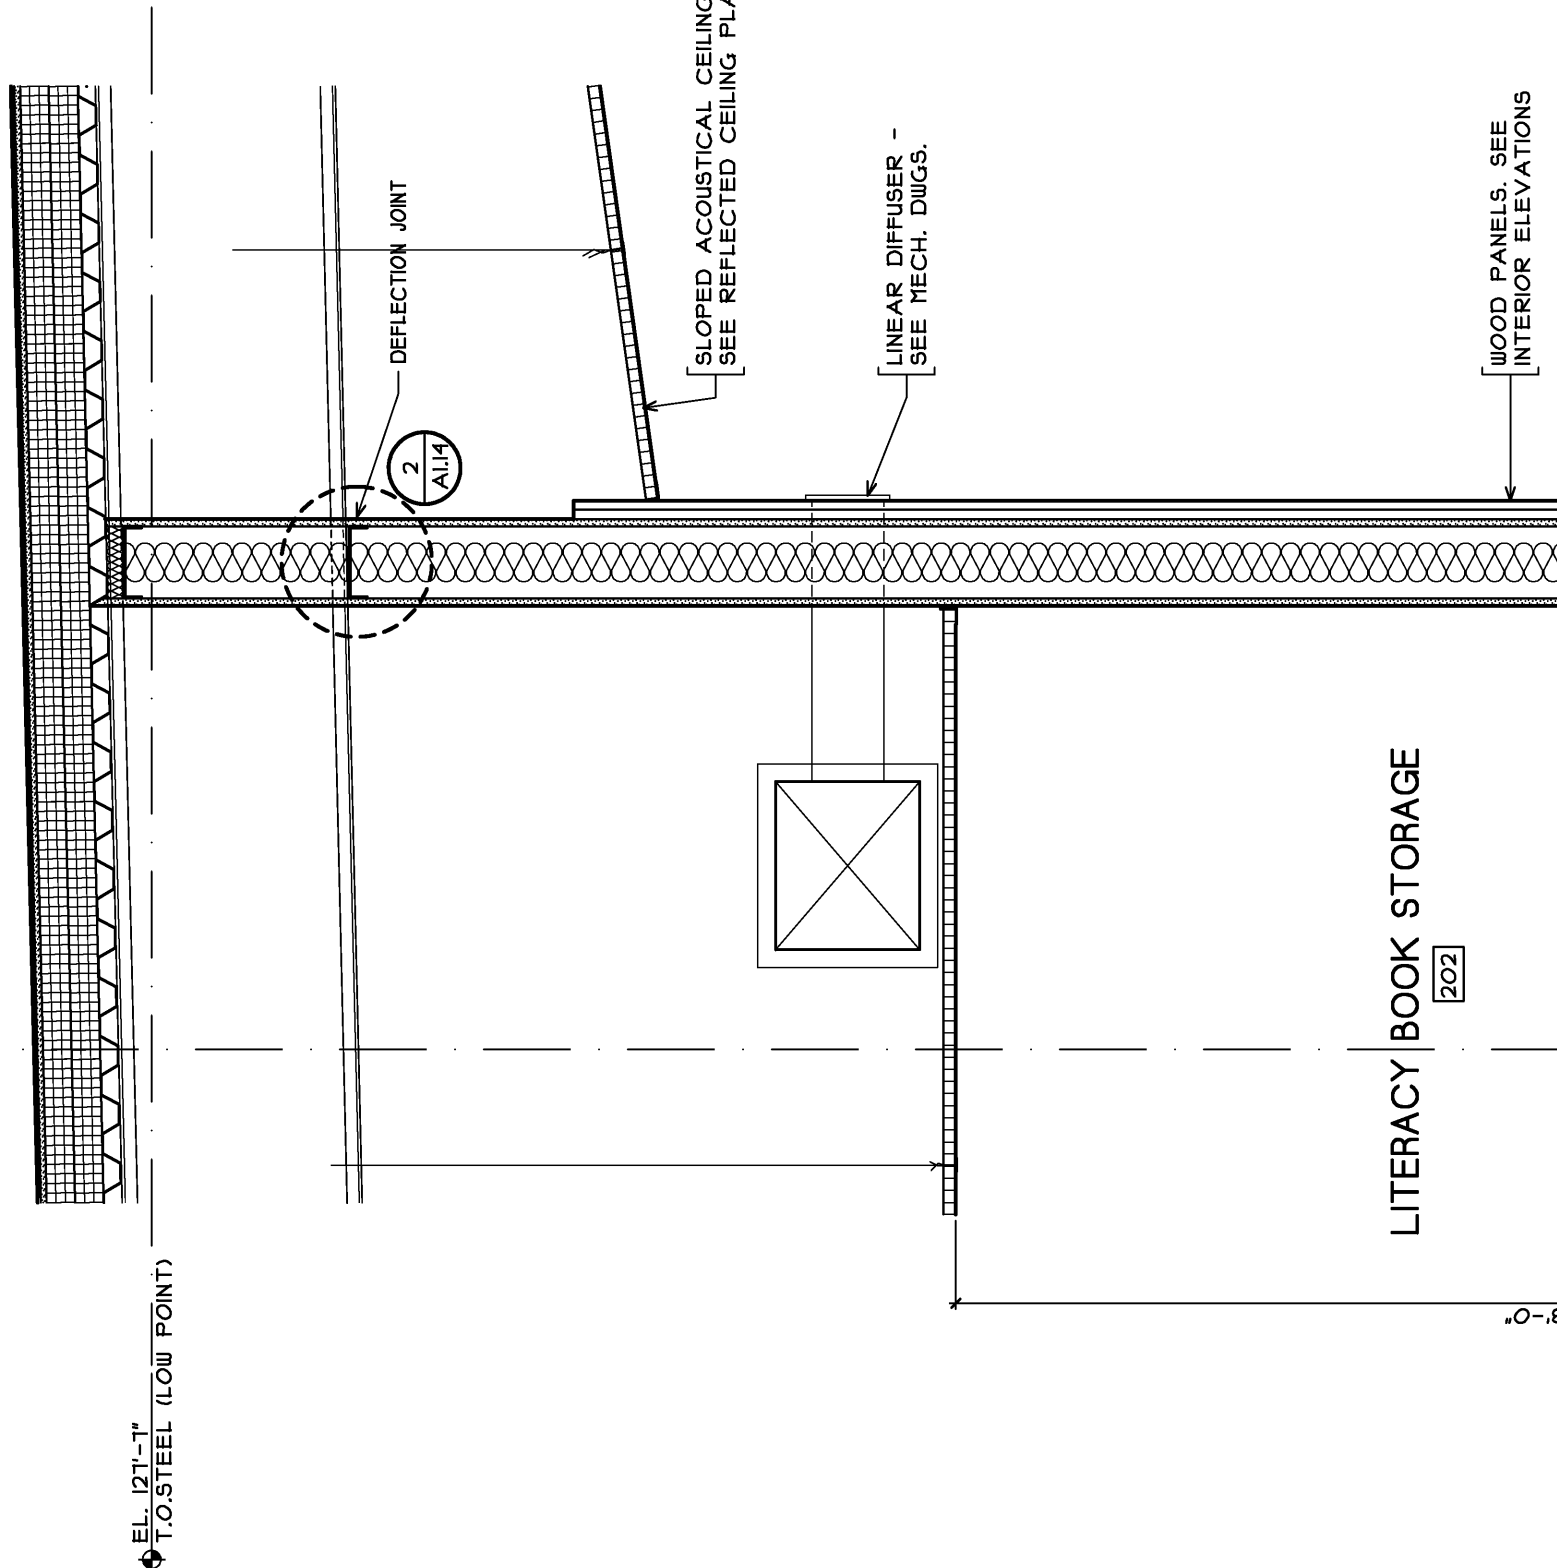


48 WALL SECTION
A313 SCALE 3/4" = 1'-0"



47 WALL SECTION
A313 SCALE 3/4" = 1'-0"

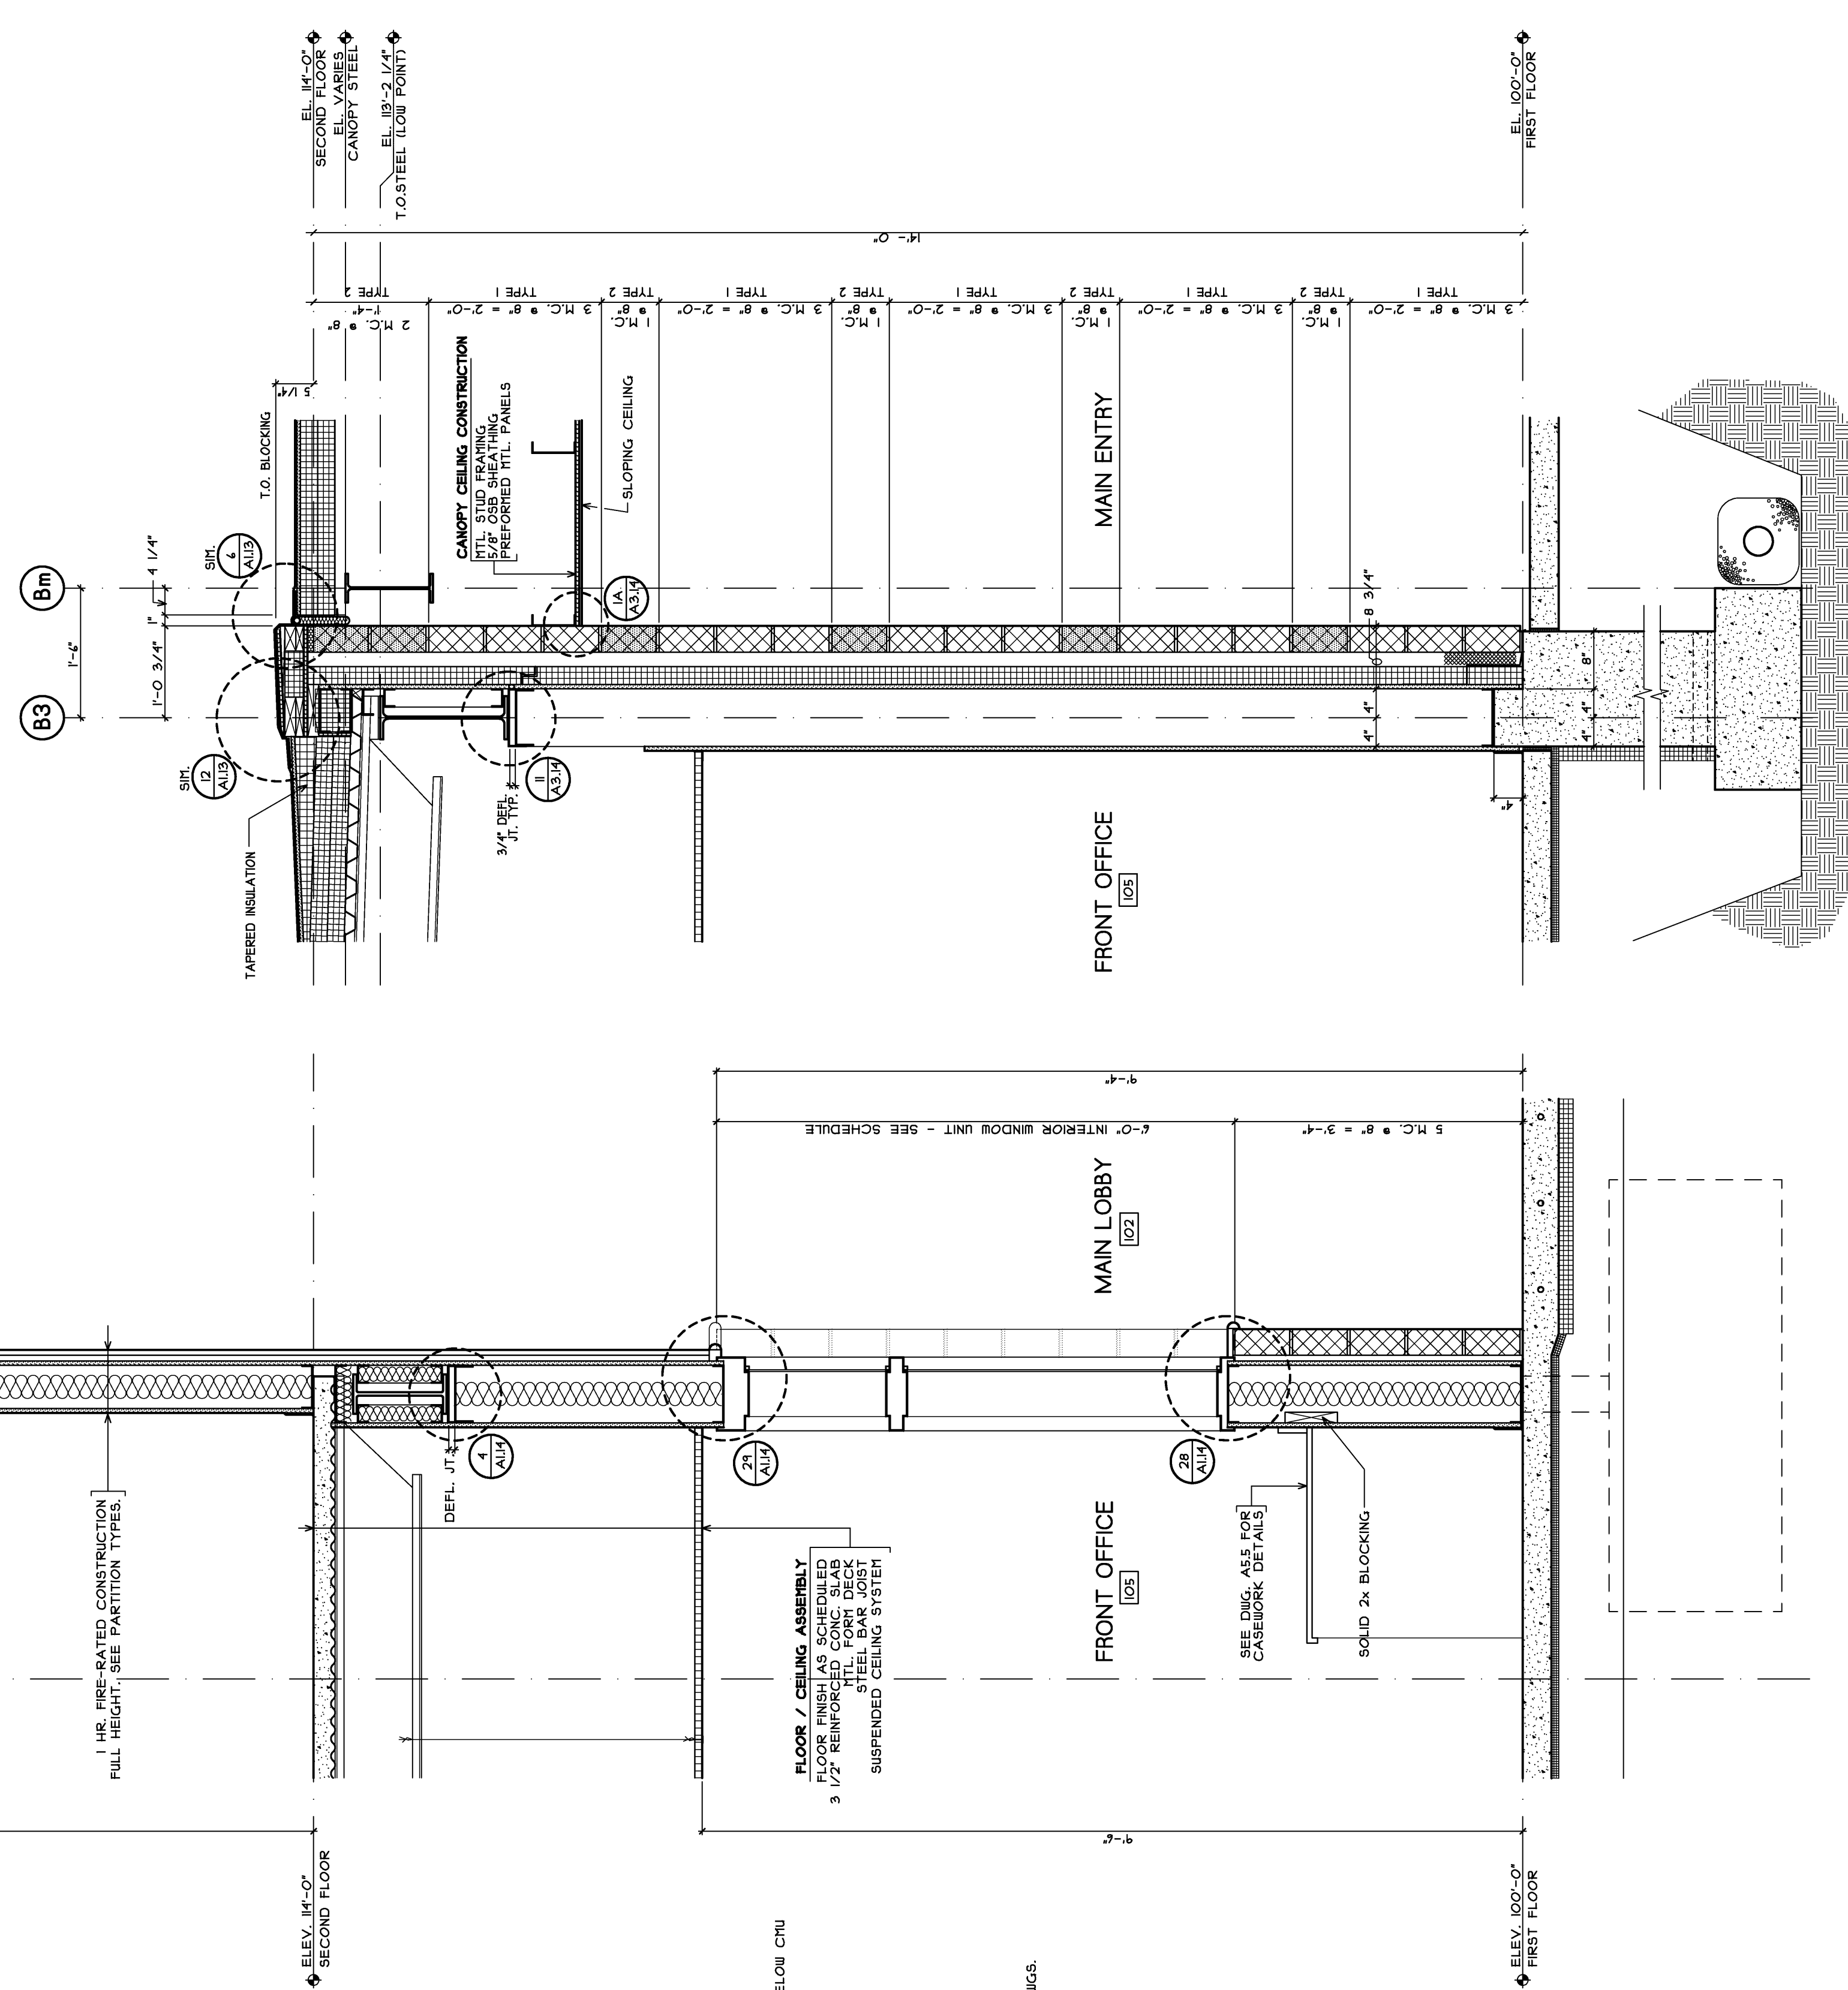

49 WALL SECTION
A313 SCALE 3/4" = 1'-0"

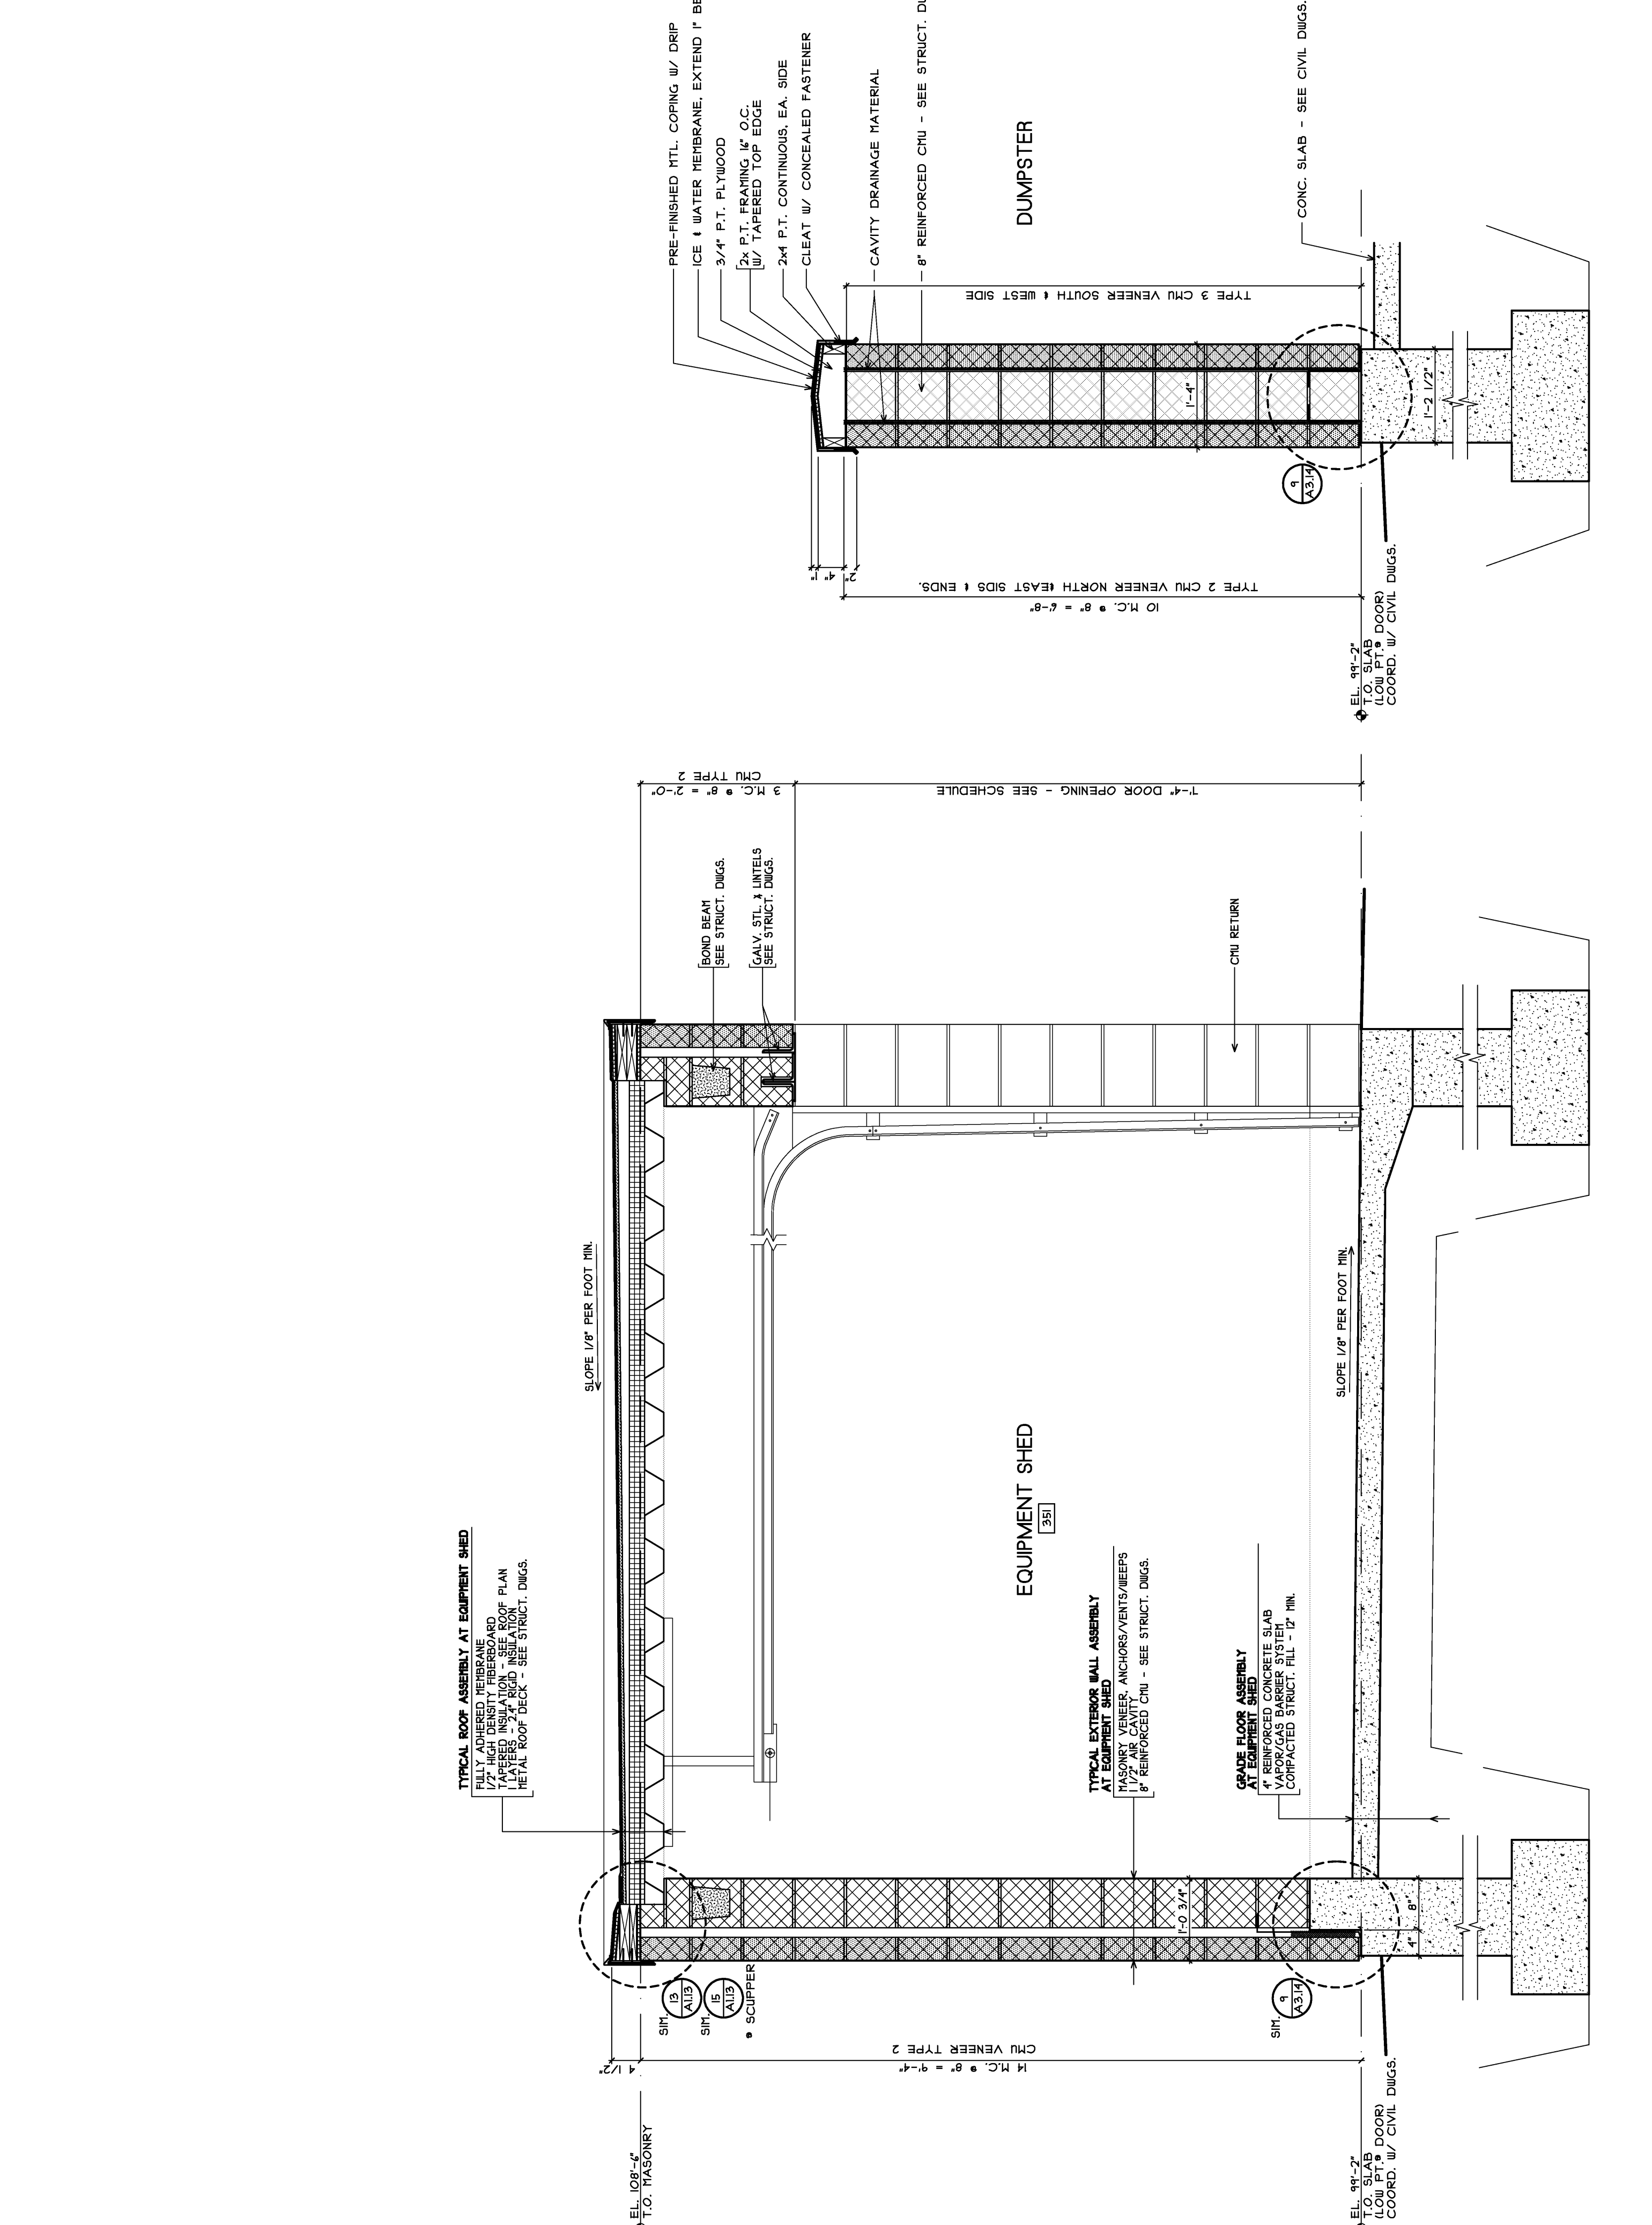

46 WALL SECTION
A313 SCALE 3/4" = 1'-0"

SEE ADD ALTERNATE NO. 4 FOR EQUIPMENT SHED

NOTE: SCREEN WALL IN BASE BID

SEE A31 FOR TYPICAL WALL, ROOF, FLOOR & CEILING ASSEMBLIES

East End Elementary School Portland Public Schools Portland, Maine		JOB NO: 0096_2004 Scale: 3/4" = 1'-0" Drawn by: ah Checked by: jh Drawing Title: Wall Sections	<h1>A3.13</h1>
Consultants Deluca-Hoffman Associates Structural Engineer Landscape Architect Carroll Associates Special Engineer Pinham & Greer Mechanical Engineer Bennett Engineering Electrical Engineer Bartlett Design Interior Design TJM Consulting Fire Solutions		ARCHITECTS 10 Dunbar Street Portland, ME 04103 207.783.9511 FAX: 207.783.2005 2017.82.2105 Email: delucahoffman.com	