


CLOCK & SOUND SYSTEM RISER
NO SCALE

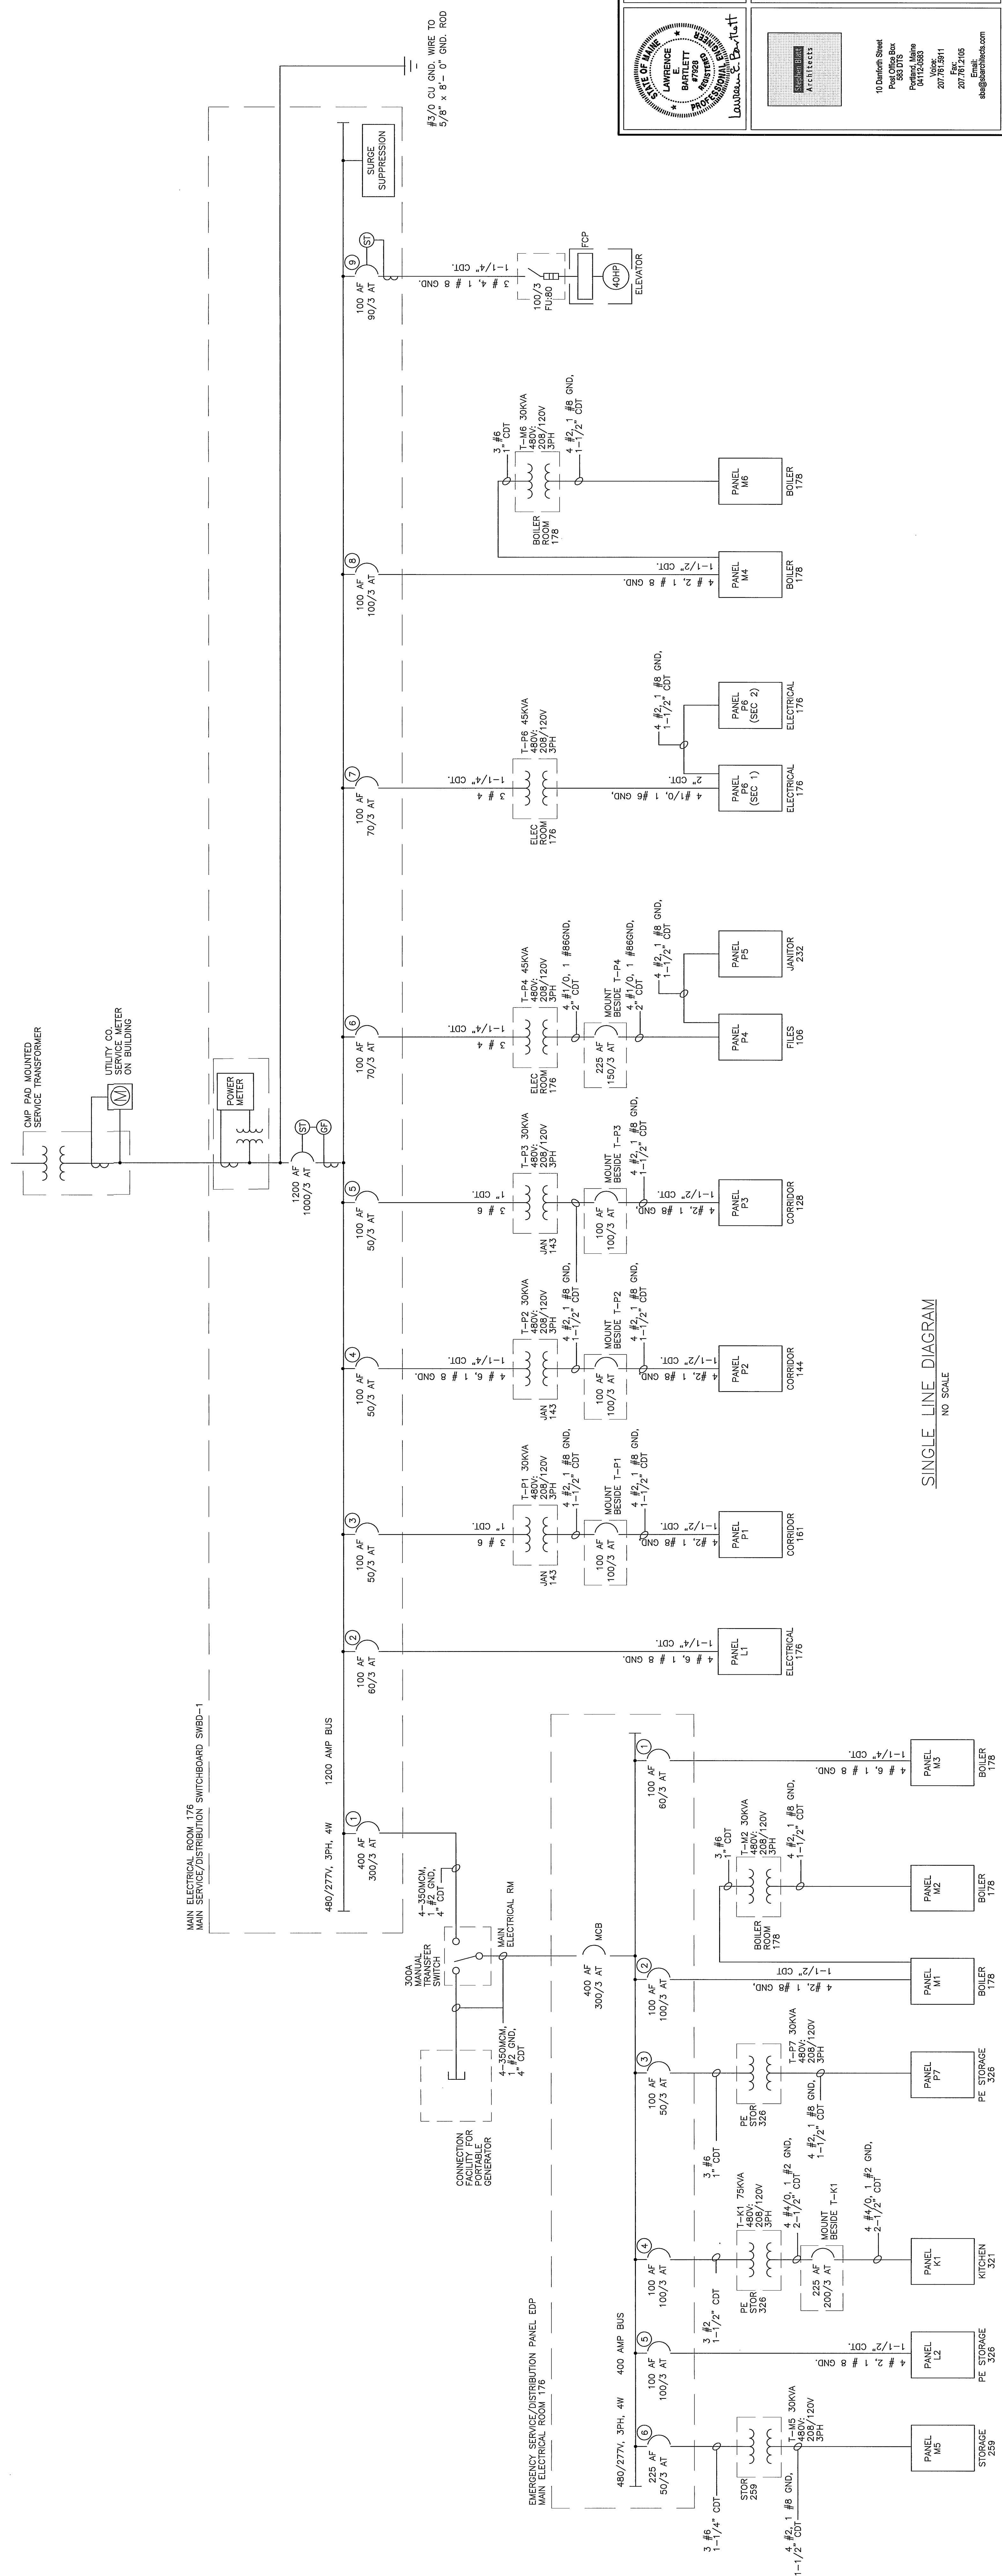

East End Elementary School
Portland Public Schools
Portland, Maine

Job No: 0308
Date: June 28, 2004
Scale: No Scale
Drawn by: JG
Checked by: JB

**Single Line Diagram
Sound System Riser**

E4.1

Consultants
Civil Engineer
DeLuca-Hoffman Associates
Landscape Architect
Carroll Associates
Structural Engineer
Prinham & Greer
Mechanical Engineer
Bennett Engineering
Electrical Engineer
Architectural Design
J.M. Consulting
Green Consulting
Fire Solutions

Architects
10 Duane Street
Post Office Box
585 DTS
Portland, ME
04112-6383
Voice: 207.781.1111
Fax: 207.781.1108
Email: eoa@eastendps.com

Lawrence B. Bartlett Architects
10 Duane Street
Portland, ME 04112-6383
Voice: 207.781.1111
Fax: 207.781.1108
Email: eoa@eastendps.com

Revisions:

SINGLE LINE DIAGRAM
NO SCALE