


RESERVED FOR CITY STAMP

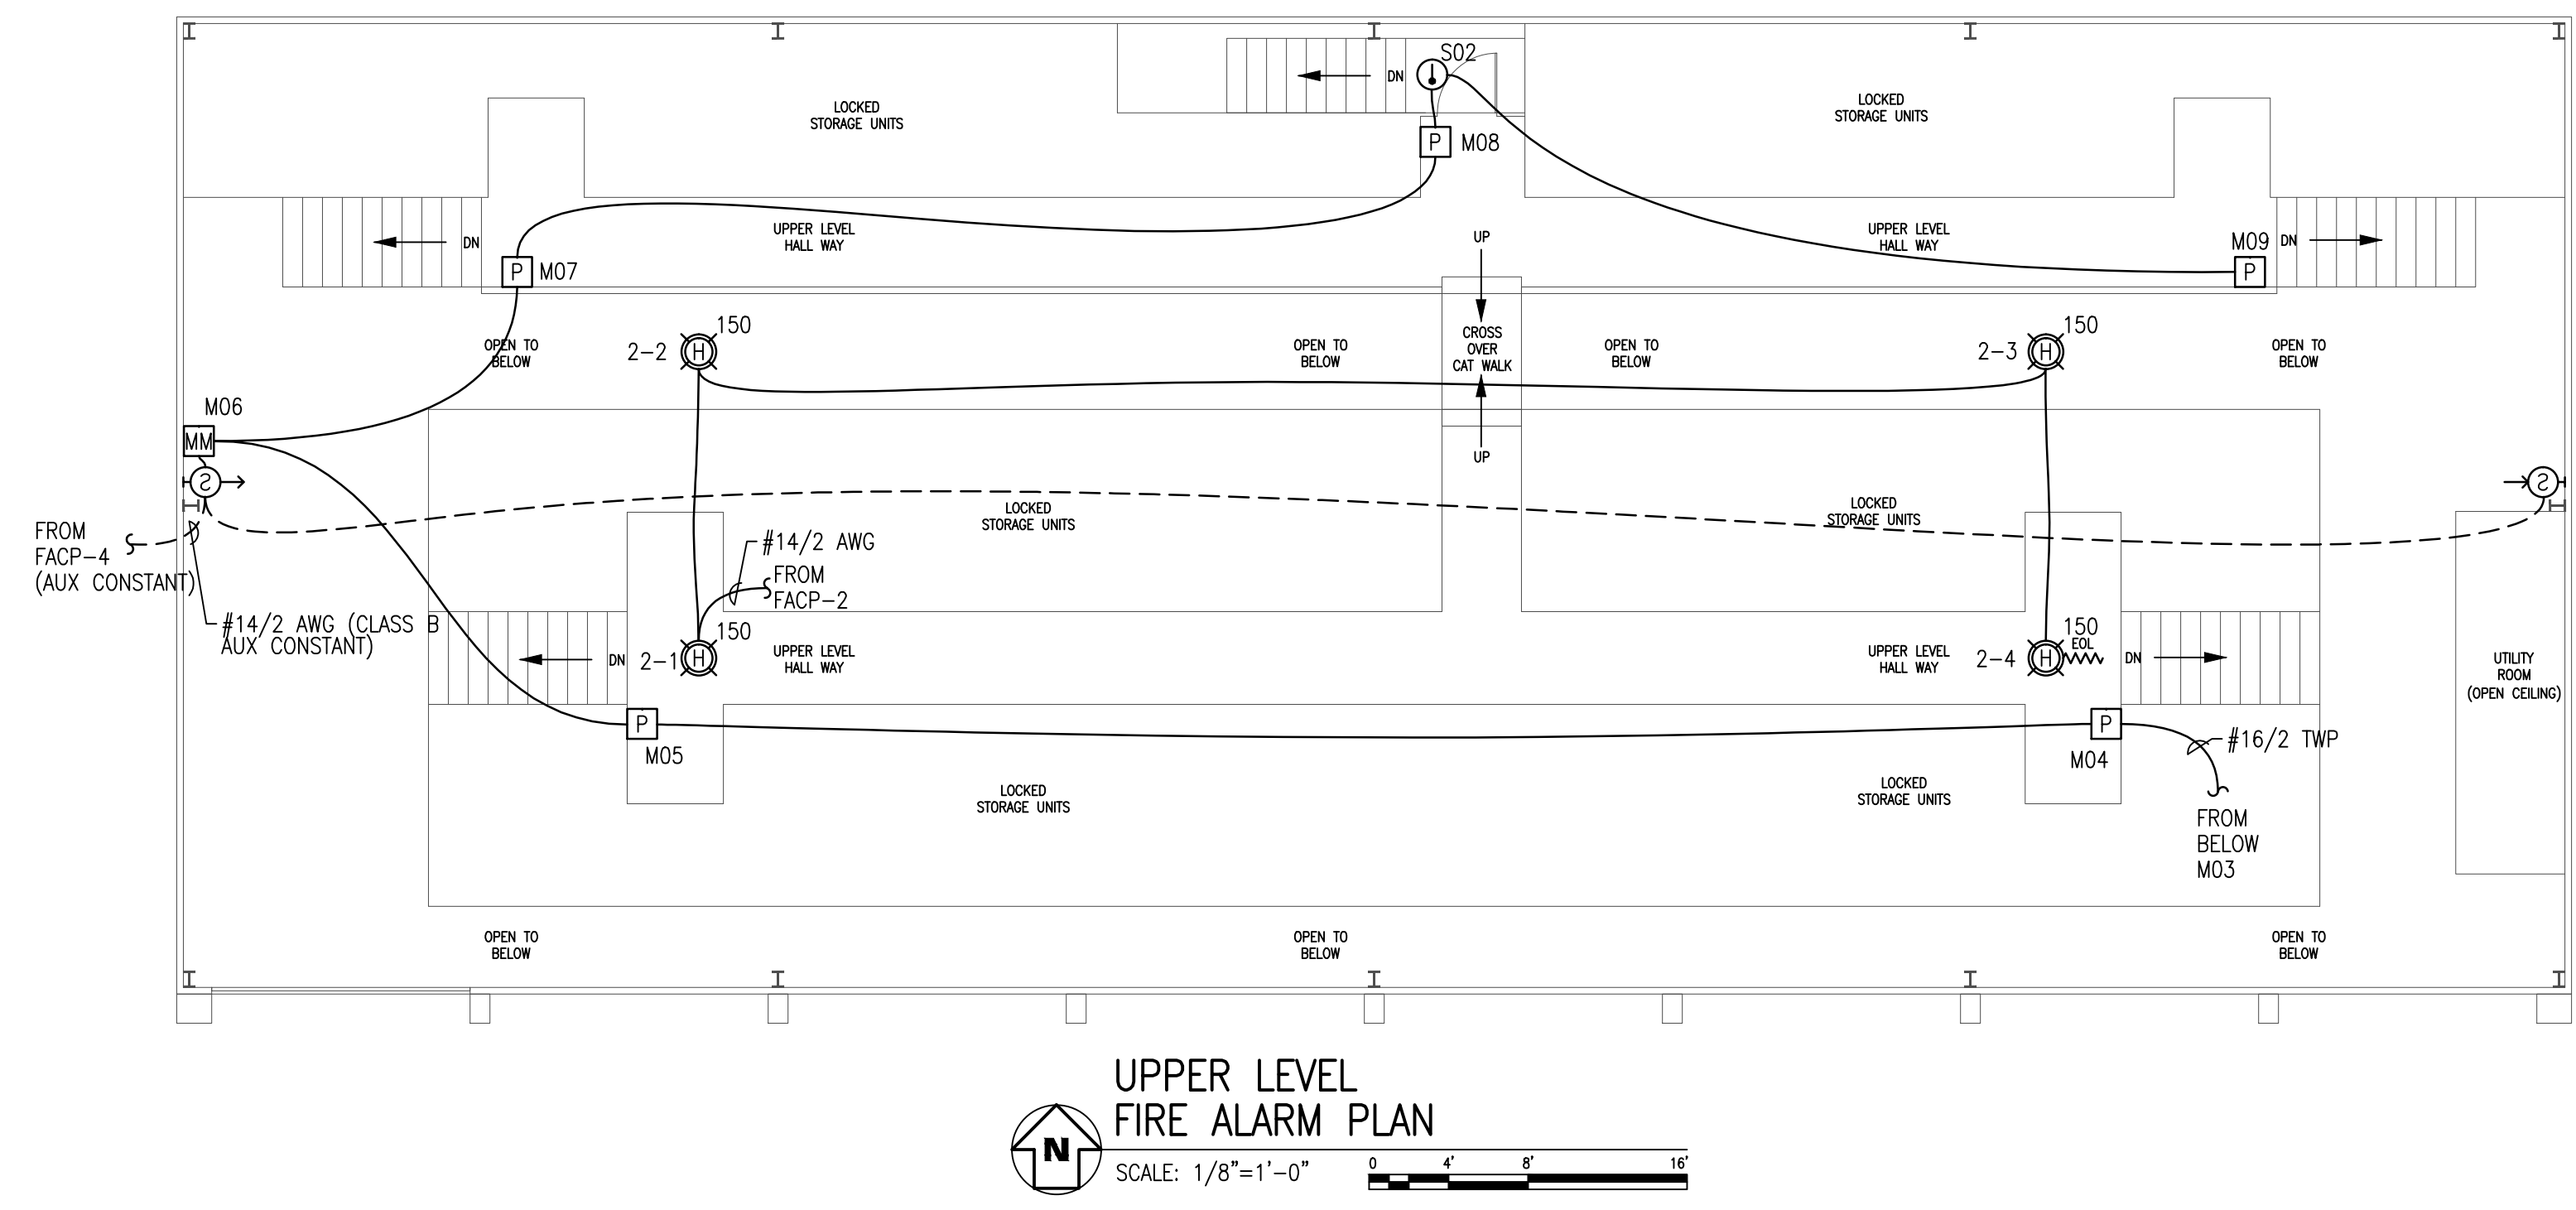

UPPER LEVEL
FIRE ALARM PLAN
SCALE: 1/8"=1'-0"

CUNNINGHAM
Security Systems
10 Princes Point Road, Yarmouth, Maine 04096
Office: 207.846.3350 • Fax: 207.846.6080

U-HAUL OF MAINE
411 MARGINAL WAY
PORTLAND, ME
UPPER LEVEL FIRE ALARM PLAN

REVISION	DESCRIPTION	DATE
0	ISSUED FOR REVIEW & APPROVAL	11/15/2017

NICET IV
Fire Alarm Systems
Wayne B. Haws
Wayne B. Haws / Signature
Date: 11/15/17
Fire Protection Engineering
Technology
Fire Alarm Systems
Cert. No. 90496
Exp. 5/1/2020

DRAWN	CWS UNICAD JOB #17700
CHECKED	WAYNE B. HAWS NICET IV 90496
DATE	11/15/2017
REVISION	0
SCALE	1/8"=1'-0"

shop drawings created by
5794 W. 4600 St.
Hingham, UT 84313
Office: 801.985.0410
UNICAD inc.
www.unicad.net Fire Alarm Design & Drafting Services

FA-2