

REVISION	0	ISSUED FOR REVIEW & APPROVAL	6/5/2013
DESCRIPTION			
DATE			

RESERVED FOR CITY STAMP



**CUNNINGHAM**  
Security Systems  
10 Princes Point Road, Yarmouth, Maine 04096  
Office: 207.846.3350 • Fax: 207.846.6080

**RUNNING WITH SCISSORS  
250 ANDERSON STREET  
PORTLAND, MAINE 04101  
FIRE ALARM PLAN**

DRAWN	JPB UNICAD JOB #13273
CHECKED	WAYNE B. HAWES NICET # 90496
DATE	6/4/2013
REVISION	0
SCALE	1/8"=1'-0"

**FA-2**

**SHEET NOTES:**  
 ◆ ADDRESSABLE MONITOR MODULE(S) PROVIDED TO MONITOR ALL WATER FLOW, PRESSURE SWITCHES, TAMPER SWITCHES AND POST INDICATING VALVES ASSOCIATED WITH THE FIRE SPRINKLER SYSTEM. INSTALLING CONTRACTOR SHALL FIELD VERIFY EXACT MOUNTING, CIRCUITING AND PROGRAMMING REQUIREMENTS. FIELD VERIFY EXACT QUANTITY AND LOCATION(S).

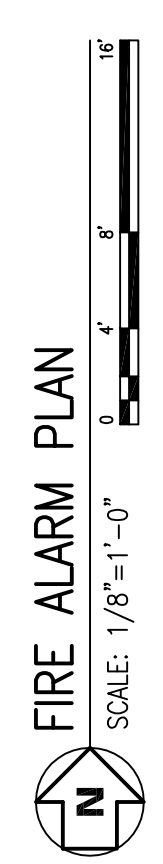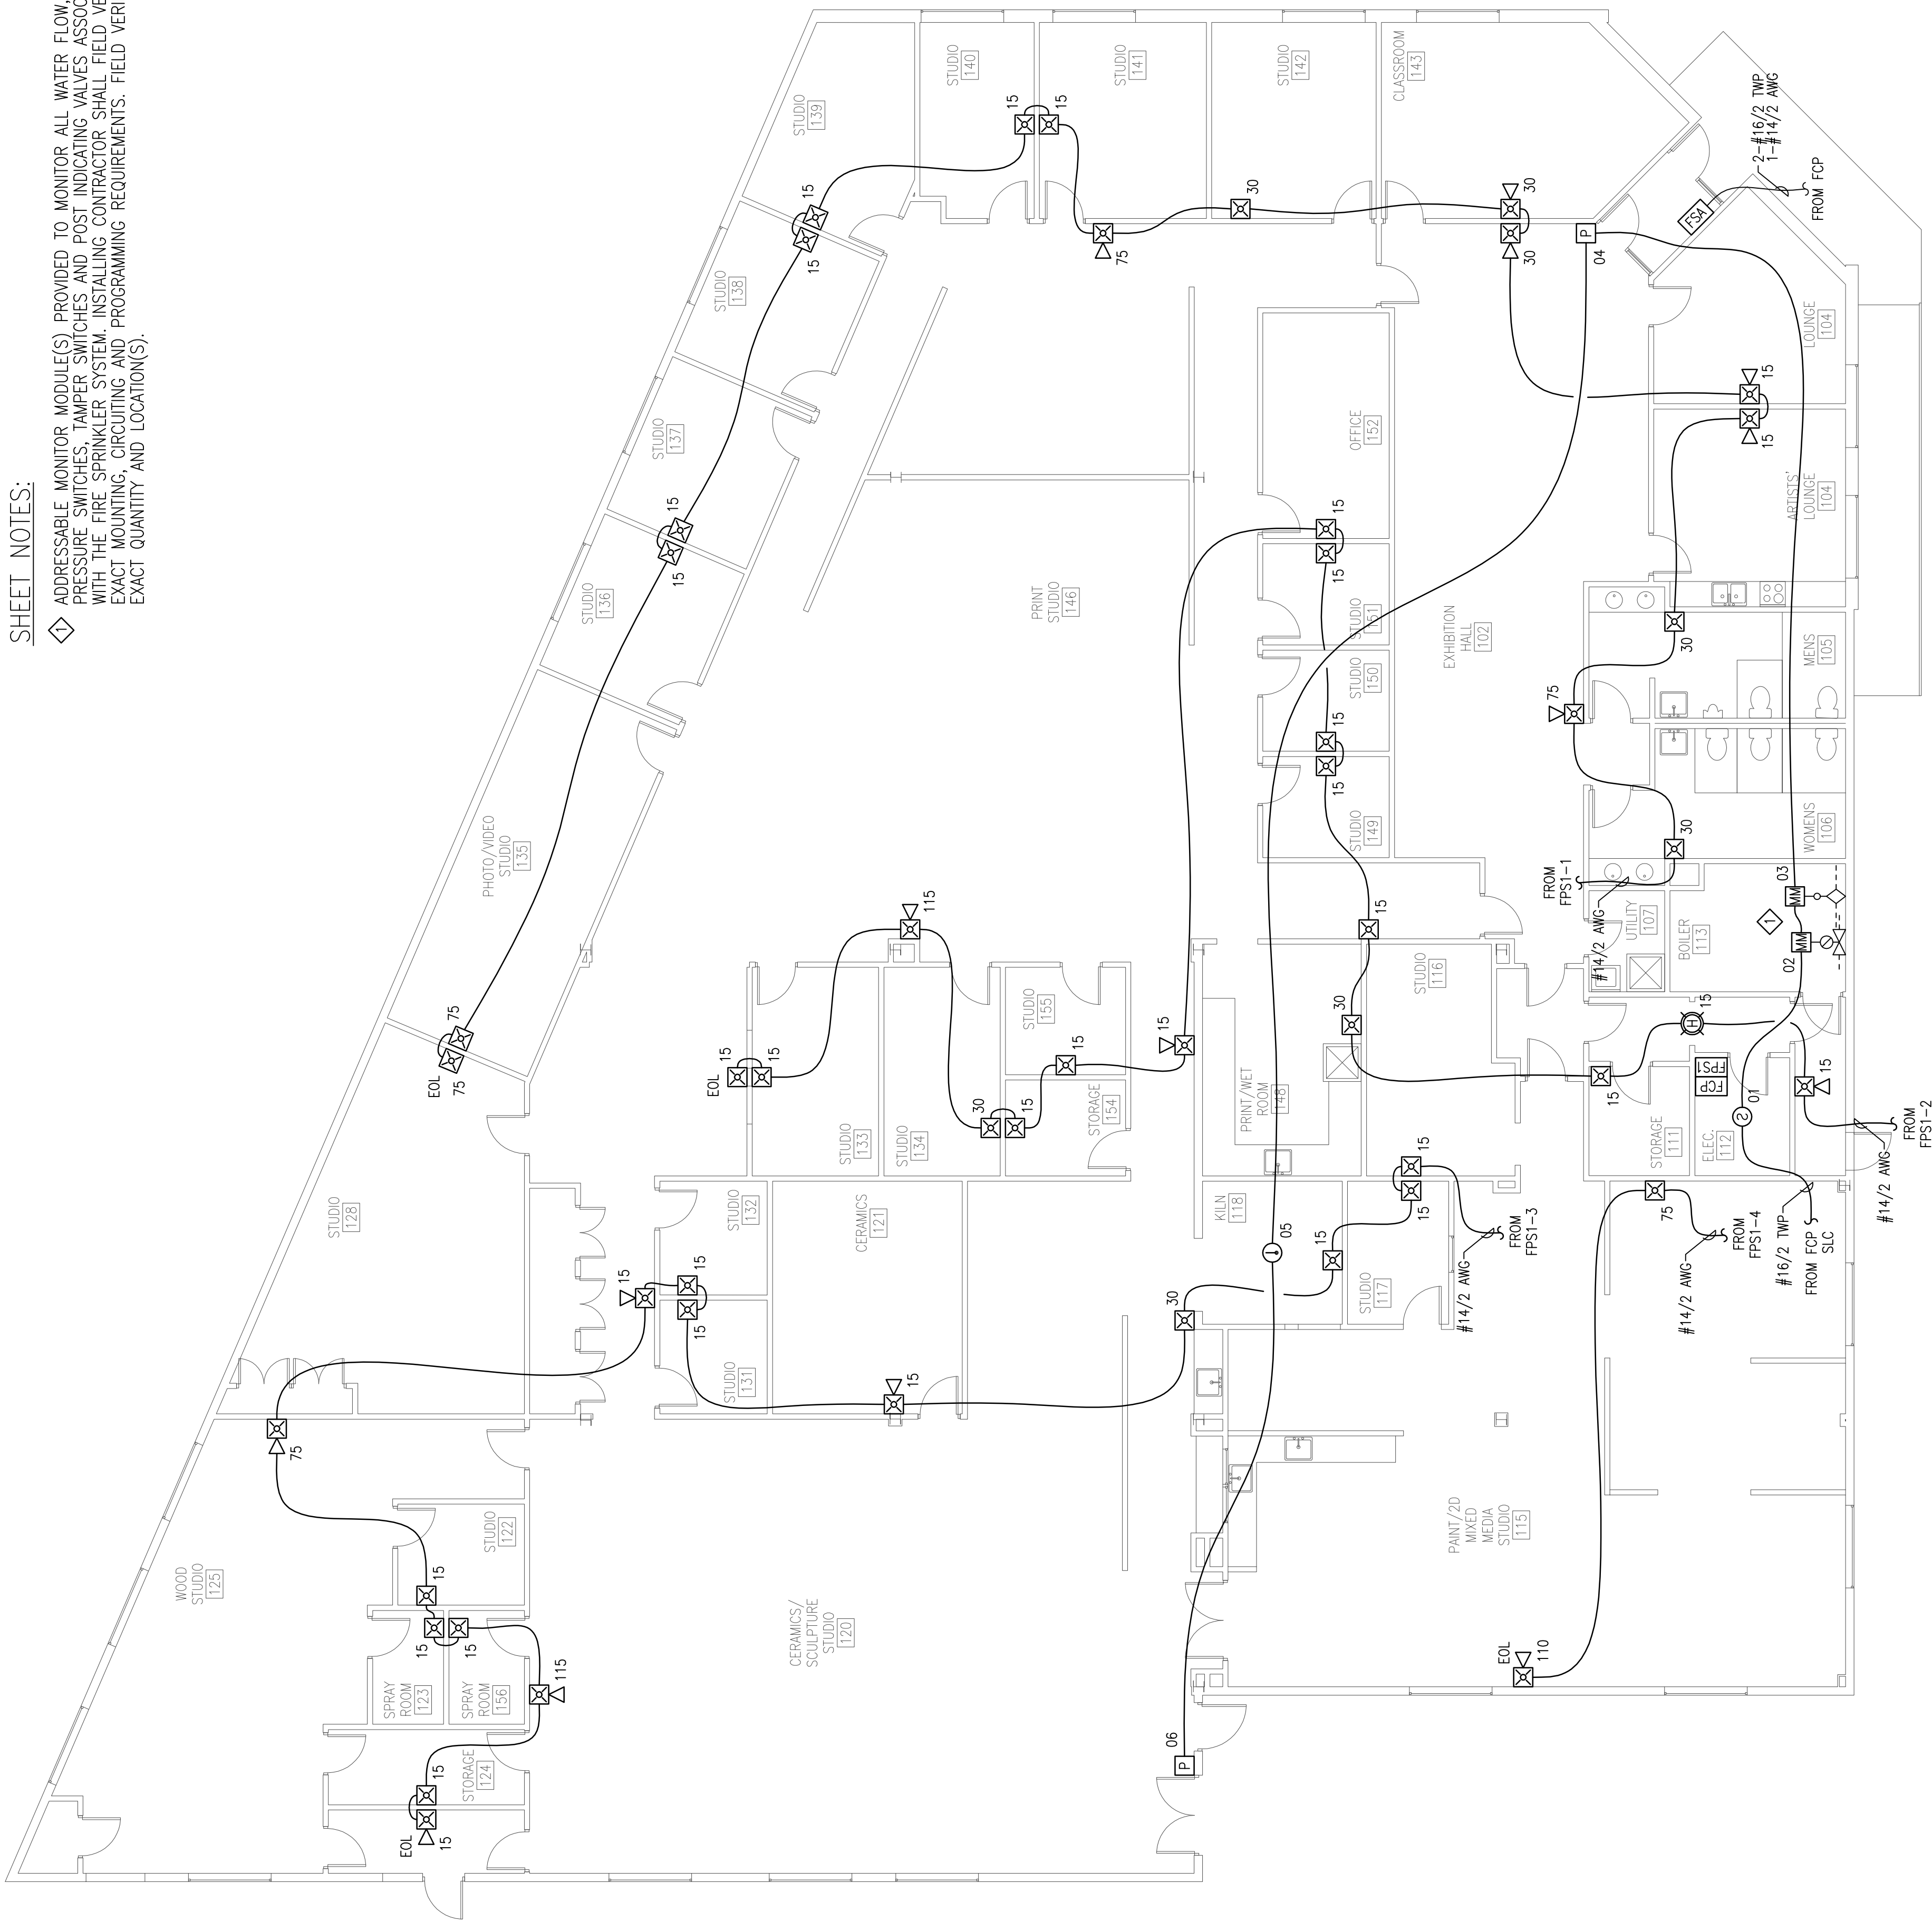

**UNICAD** Inc.  
Fire Alarm Design & Drafting Services  
www.unicad.net  
578 W. 40th St.  
Portland, ME 04101  
Office: 801.865.0410