


**UPPER LEVEL**  
**CEILING PLAN**

2

SCALE: 1/4"=1'-0"

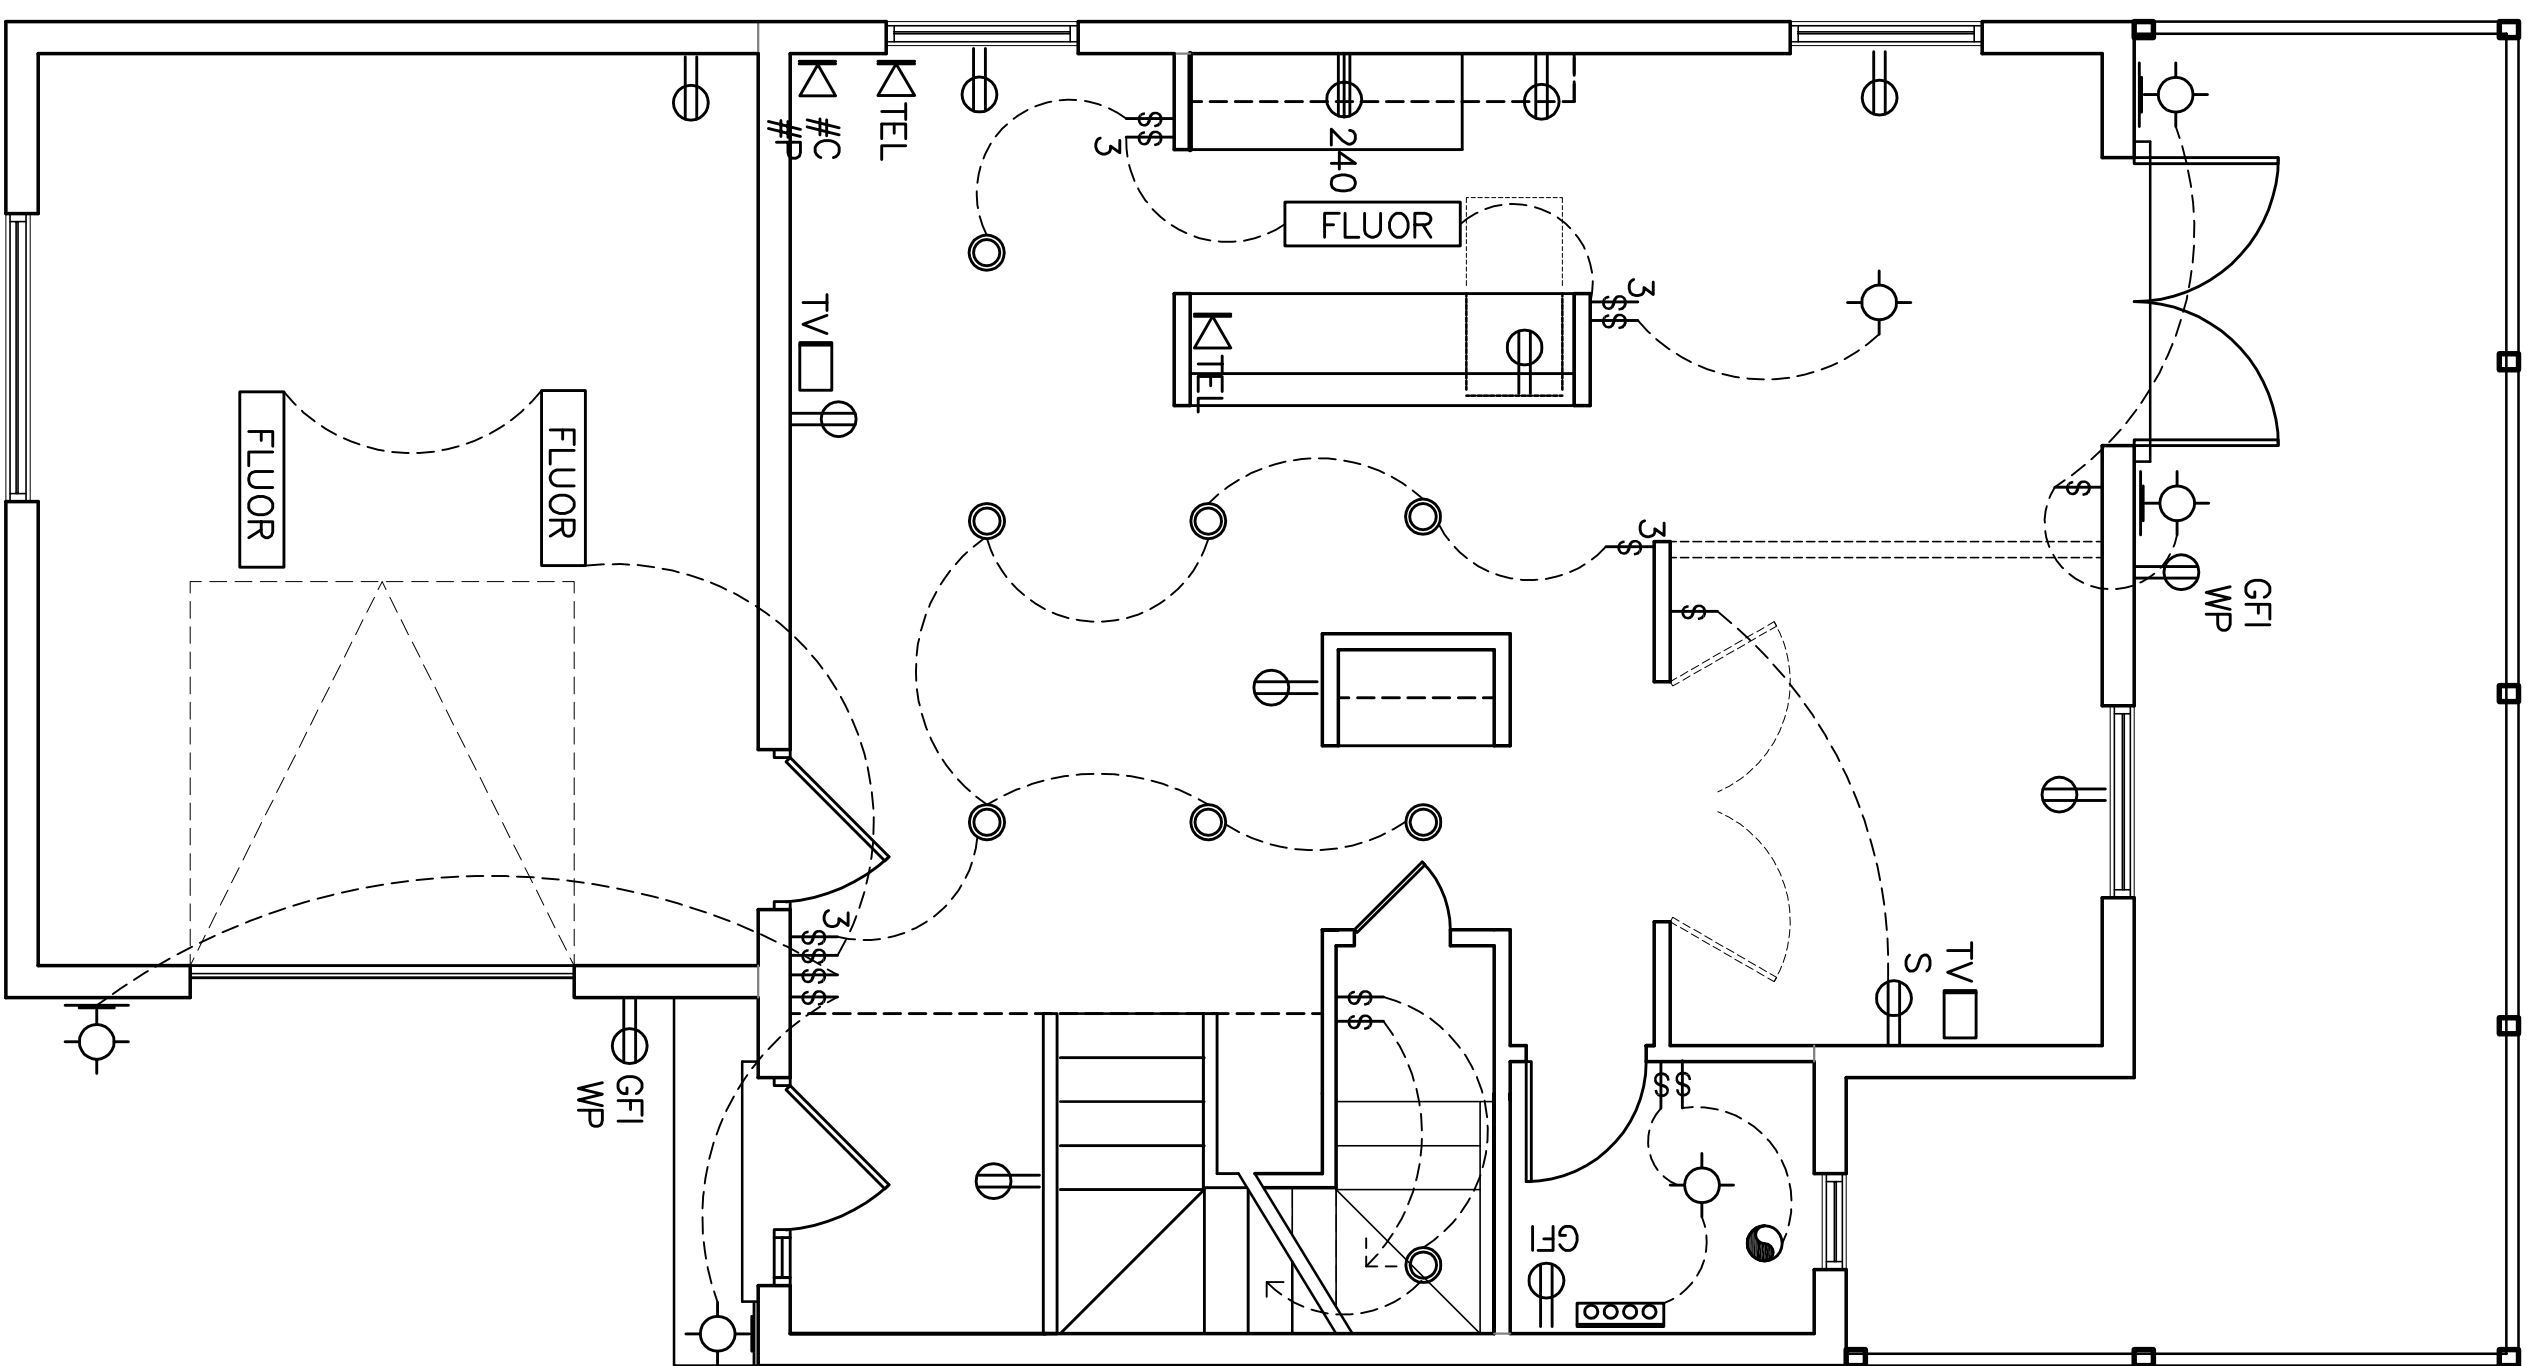

**ENTRY LEVEL**  
**CEILING PLAN**

1

SCALE: 1/4"=1'-0"

**PLEASE NOTE:**

1. LUBULA D. KANYINDA ASSUMES NO LIABILITY FOR ANY HOME CONSTRUCTED FROM THIS PLAN. IT IS THE RESPONSIBILITY OF THE PURCHASER OF THIS PLAN TO PERFORM THE FOLLOWING BEFORE BEGINNING ACTUAL CONSTRUCTION.
1. BUILDER OR CONTRACTOR MUST VERIFY ALL DIMENSIONS PRIOR TO PROCEEDING WITH CONSTRUCTION.
2. CONTRACTOR MUST VERIFY COMPLIANCE WITH ALL LOCAL CODES IN THE AREA WHERE THE HOME IS TO BE CONSTRUCTED.
3. PLANS INDICATE LOCATIONS ONLY. ENGINEERING AGREES SHOULD INCORPORATE ACTUAL SITE CONDITIONS.
4. PURCHASER OF THIS PLAN ASSUMES LIABILITY FOR ANY MODIFICATIONS MADE TO THE LAYOUT OF THIS PLAN.

ELECTRICAL LEGEND	
	CEILING MOUNTED LIGHT
	HANGING LIGHT FIXTURE
	WALL MOUNTED LIGHT
	RECESSED CAN LIGHT
	ENERGY STAR RATED
	WALL MOUNTED STRIP (4 LIGHT / 6 LIGHT)
	FLUOR
	FLUORESCENT LIGHT
	3-WAY LIGHT SWITCH
	3-WAY LIGHT SWITCH
	DIMMER LIGHT SWITCH
	110V ELECTRICAL RECEPTACLE
	UNDER COUNTER RECEPTACLE
	GROUND FAULT CURRENT INTERRUPTER RECEPTACLE
	SWITCH RECEPTACLE
	WATERPROOF RECEPTACLE
	240V ELECTRICAL RECEPTACLE
	DRY BELL
	TELEPHONE JACK
	MULTIMEDIA JACK (NETWORK/TV)
	TV JACK
	SMOKE/CARBON MONOXIDE DETECTOR
	THERMOSTAT
	NATURAL GAS/PROPANE HOOKUP
	EXHAUST FAN
	ICE MAKER
	CENTRAL AIR CONDITIONING

**REVISION SCHEDULE:**

NO.	DESCRIPTION	DATE

PROJECT NAME:

REFLECTING CEILING/ELECTRICAL PLANS

PROJECT NUMBER	CUSTOM FORM/LINDA SCOTT
DATE	
DRAWN BY:	LDK
CHECKED BY:	
SHEET #	

**2.0**