


© 2004 TFH ARCHITECTS



17 NORTH STREET - WESTBROOK, ME
PEOPLE'S REGIONAL OPPORTUNITY PROGRAM
PORTLAND, MAINE

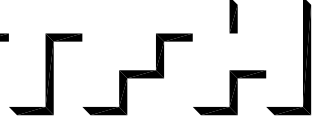

TFH ARCHITECTS
100 COMMERCIAL STREET
PORTLAND MAINE 04101
TELEPHONE 207 775 6141
ARCHITECTURE PLANNING


CONSULTANTS:

REVISIONS:


DATE: 01/26/05
PROJECT No. 0406
DRAWN BY: SA/RJS
CHECKED BY: DAM
SCALE: AS NOTED

SHEET TITLE:
HEATING PLAN


M1.1

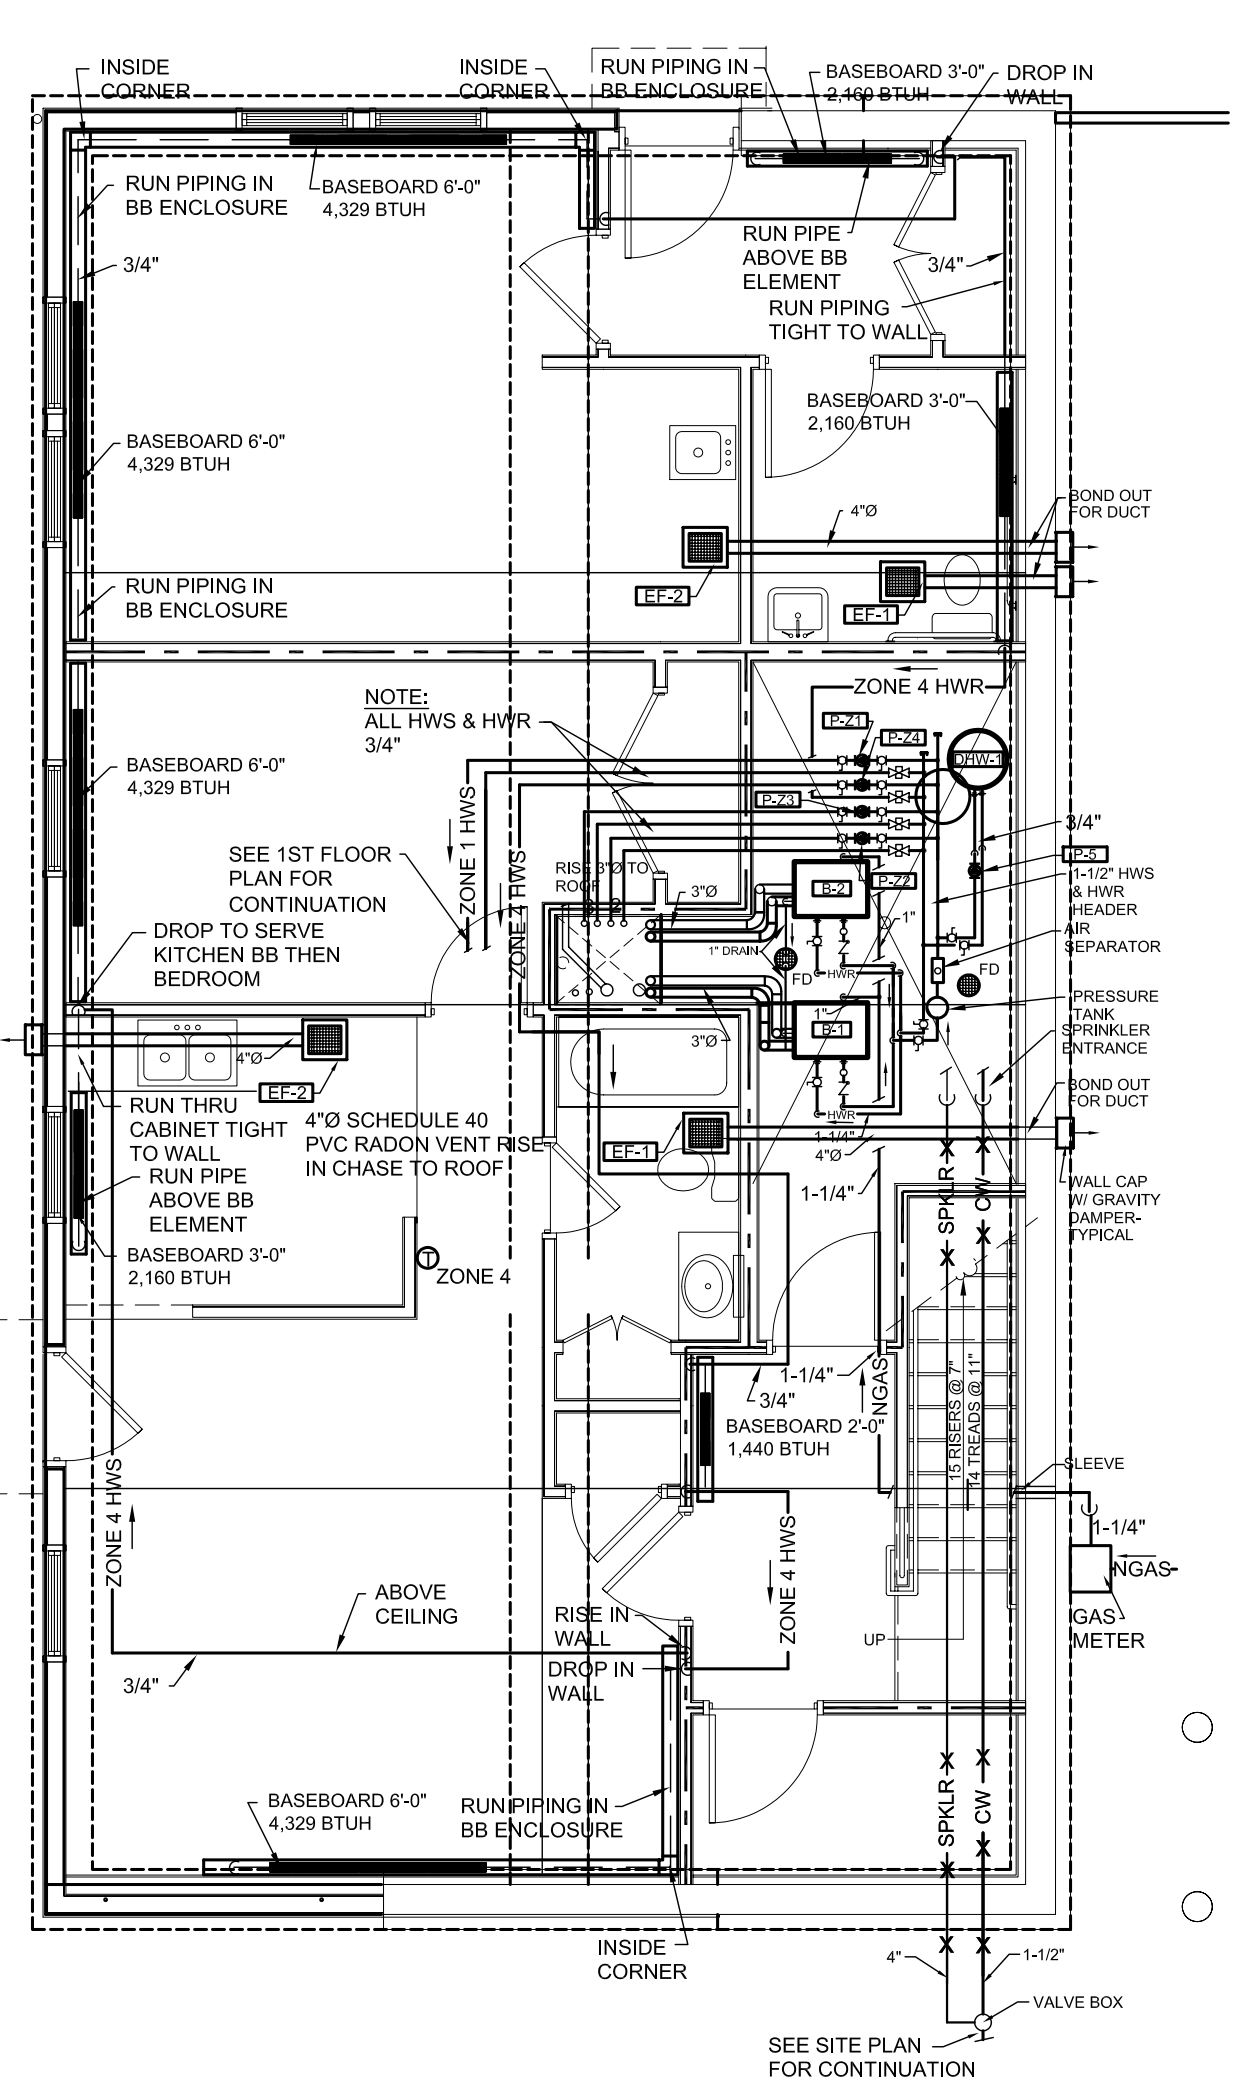


1 BASEMENT
M1.1 3/16" = 1'-0"

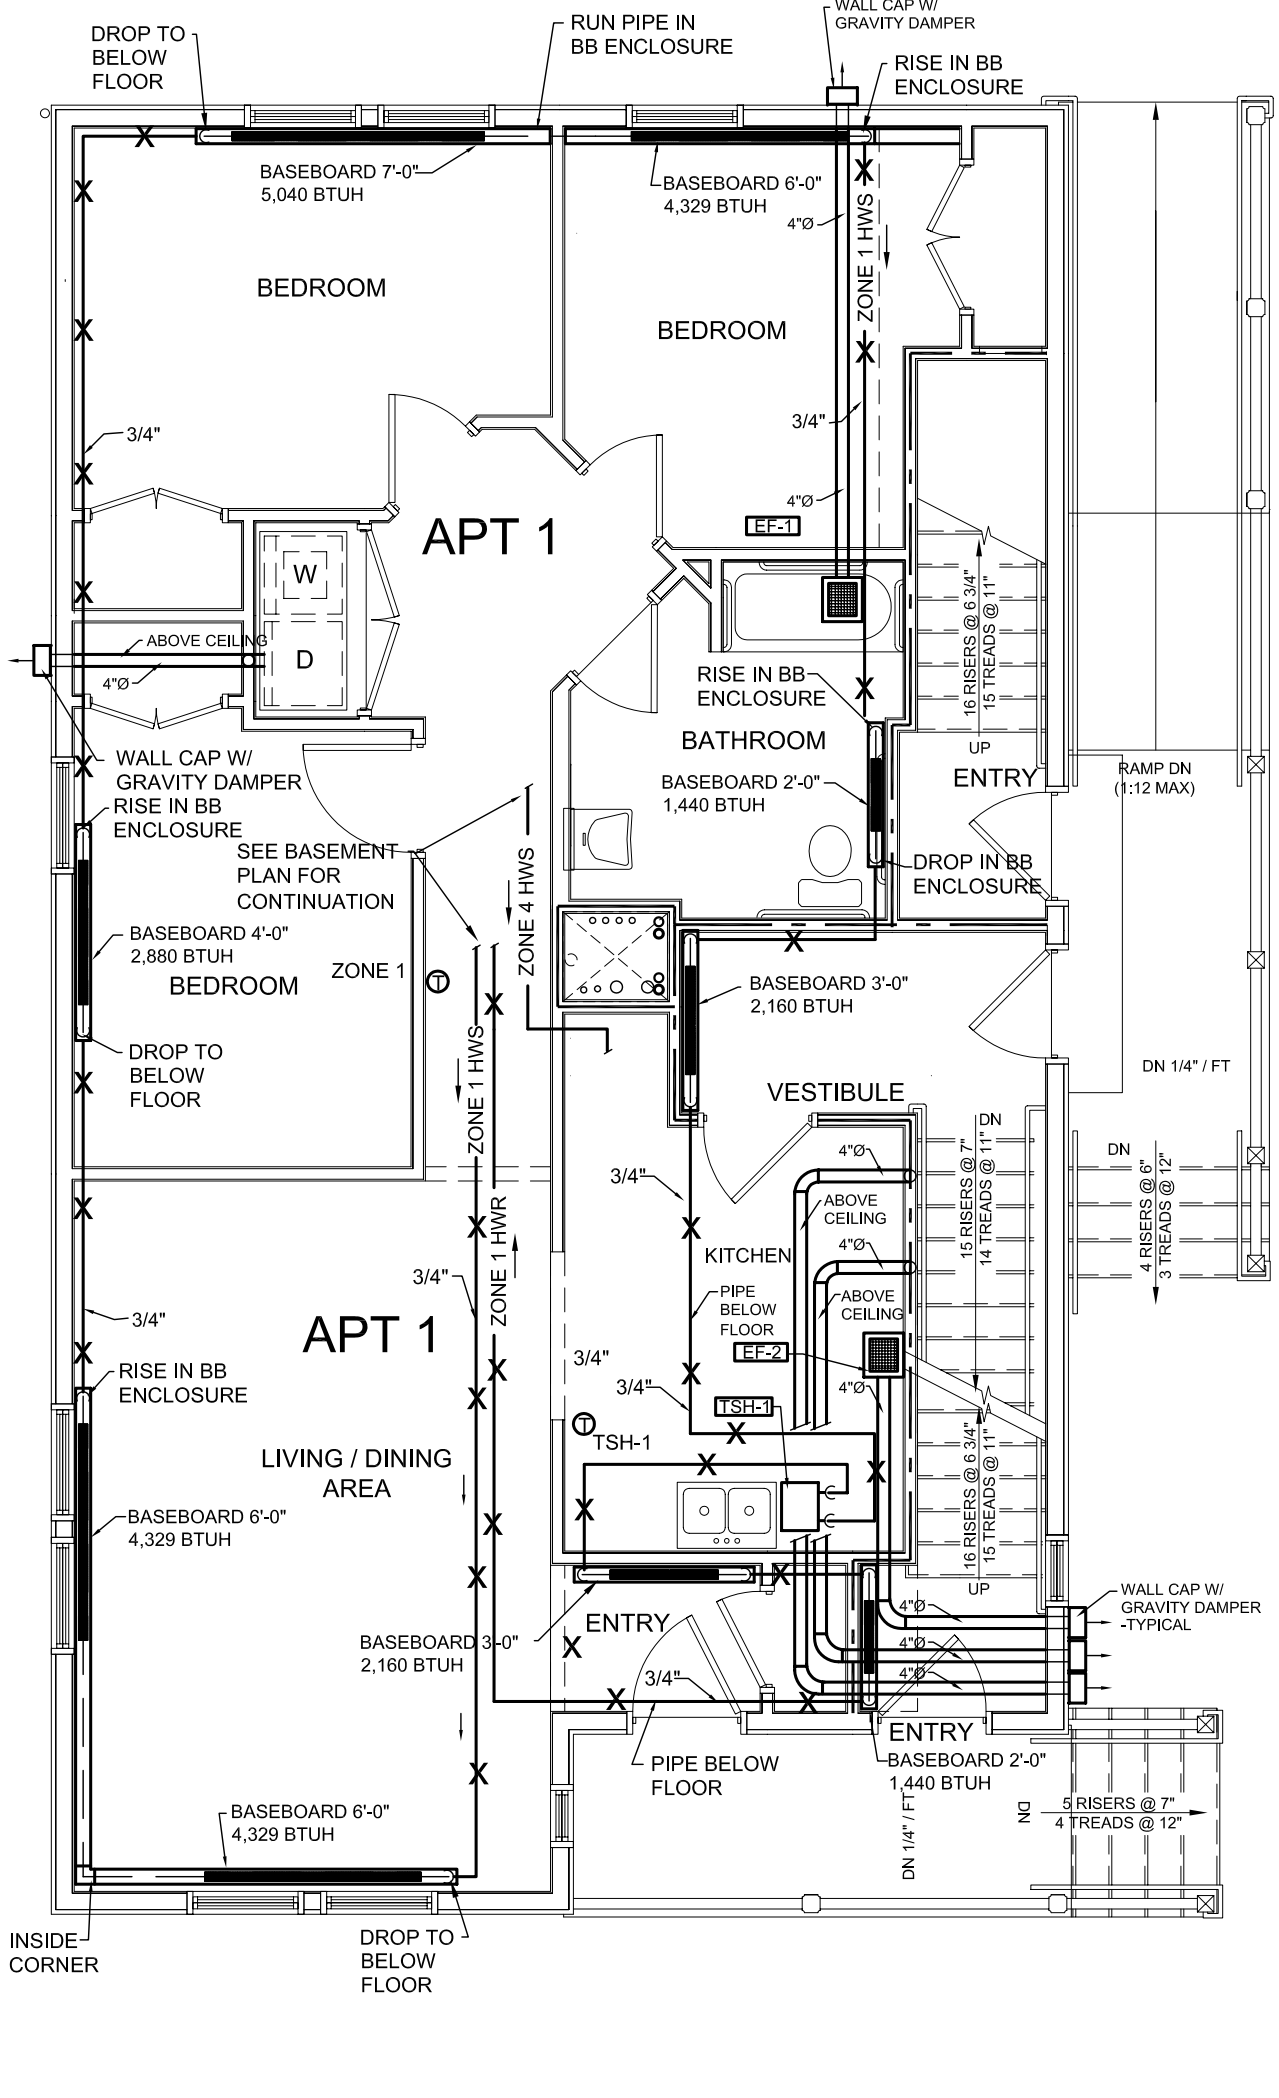

2 FIRST FLOOR
M1.1 3/16" = 1'-0"

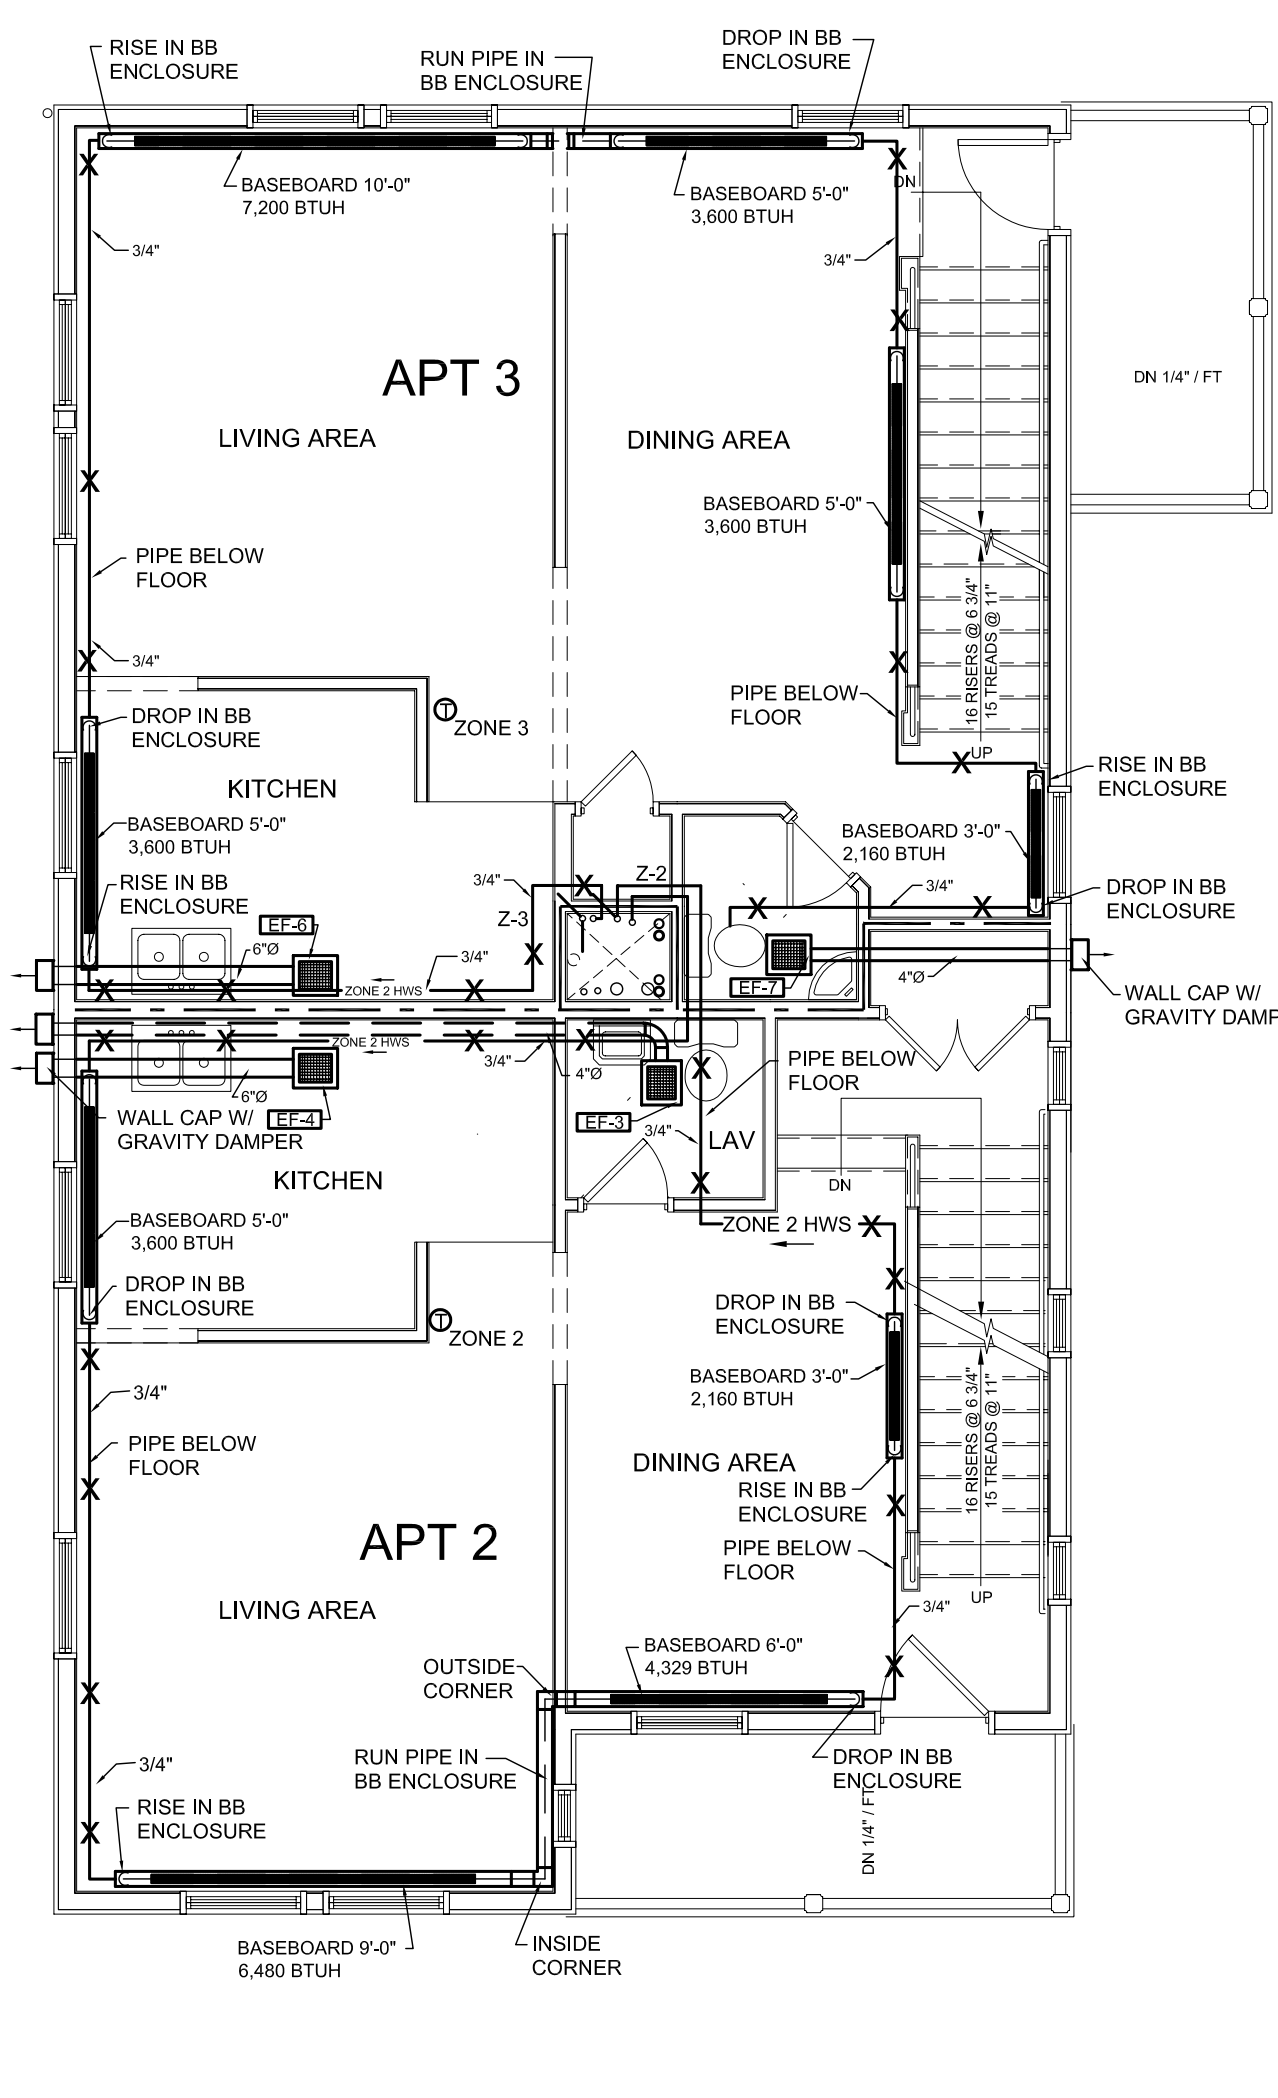

3 SECOND FLOOR
M1.1 3/16" = 1'-0"

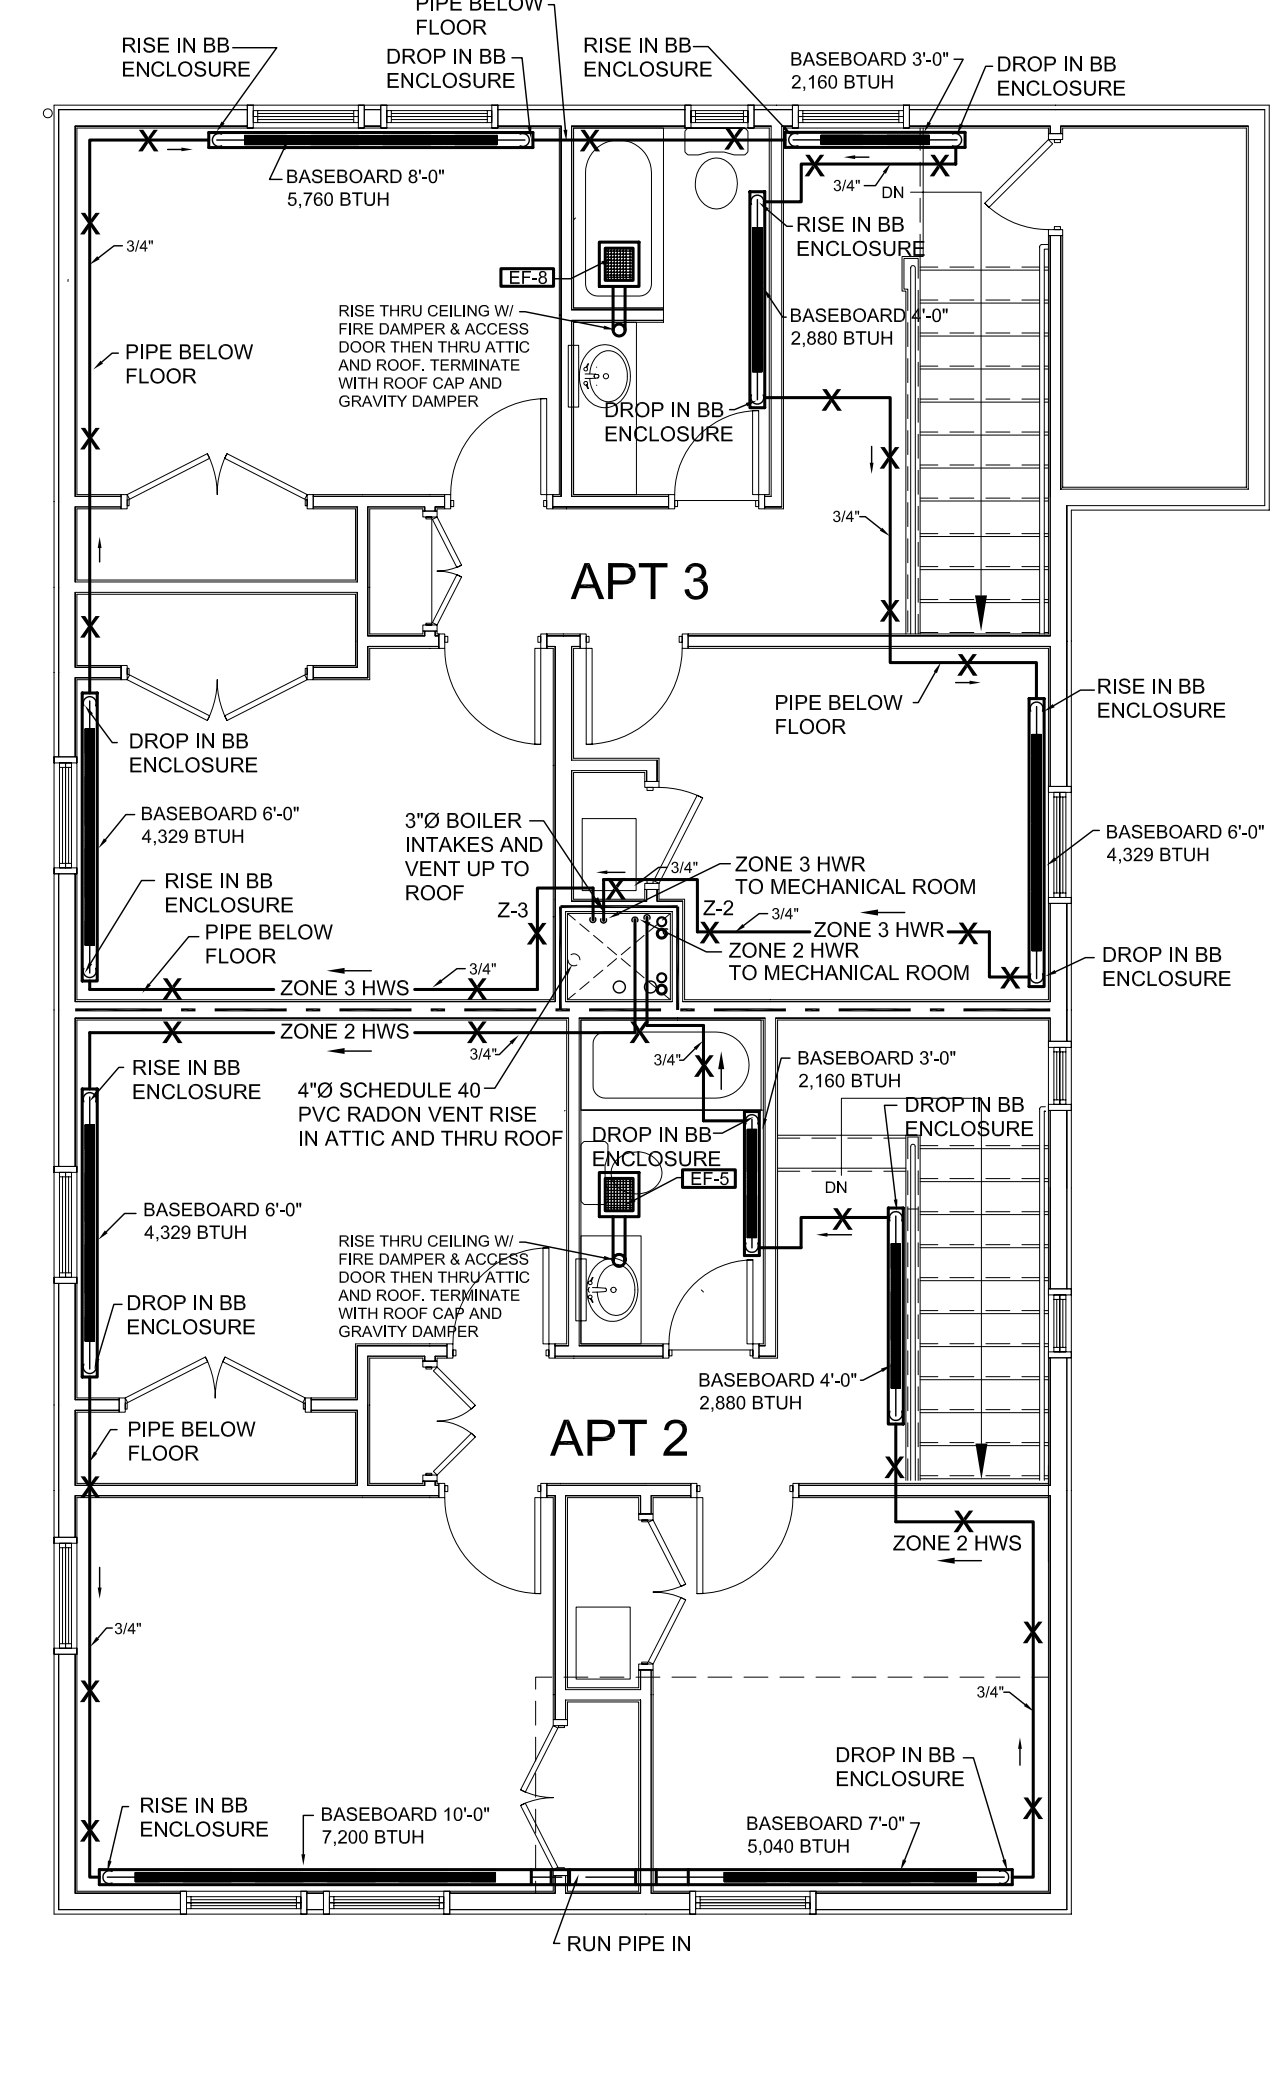

4 THIRD FLOOR
M1.1 3/16" = 1'-0"