


© 2004 TFH ARCHITECTS



23 NORTH STREET - WESTBROOK, ME  
PEOPLE'S REGIONAL OPPORTUNITY PROGRAM  
PORTLAND, MAINE

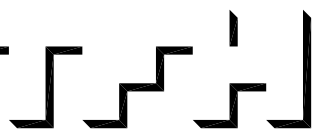

TFH ARCHITECTS  
100 COMMERCIAL STREET  
PORTLAND MAINE 04101  
TELEPHONE 207 775 6141  
ARCHITECTURE PLANNING

CONSULTANTS:

REVISIONS:

DATE: 01/26/05

PROJECT No. 0406


DRAWN BY: SA/RJS

CHECKED BY: DAM


SCALE: AS NOTED

SHEET TITLE:  
PLUMBING PLAN


M1.2

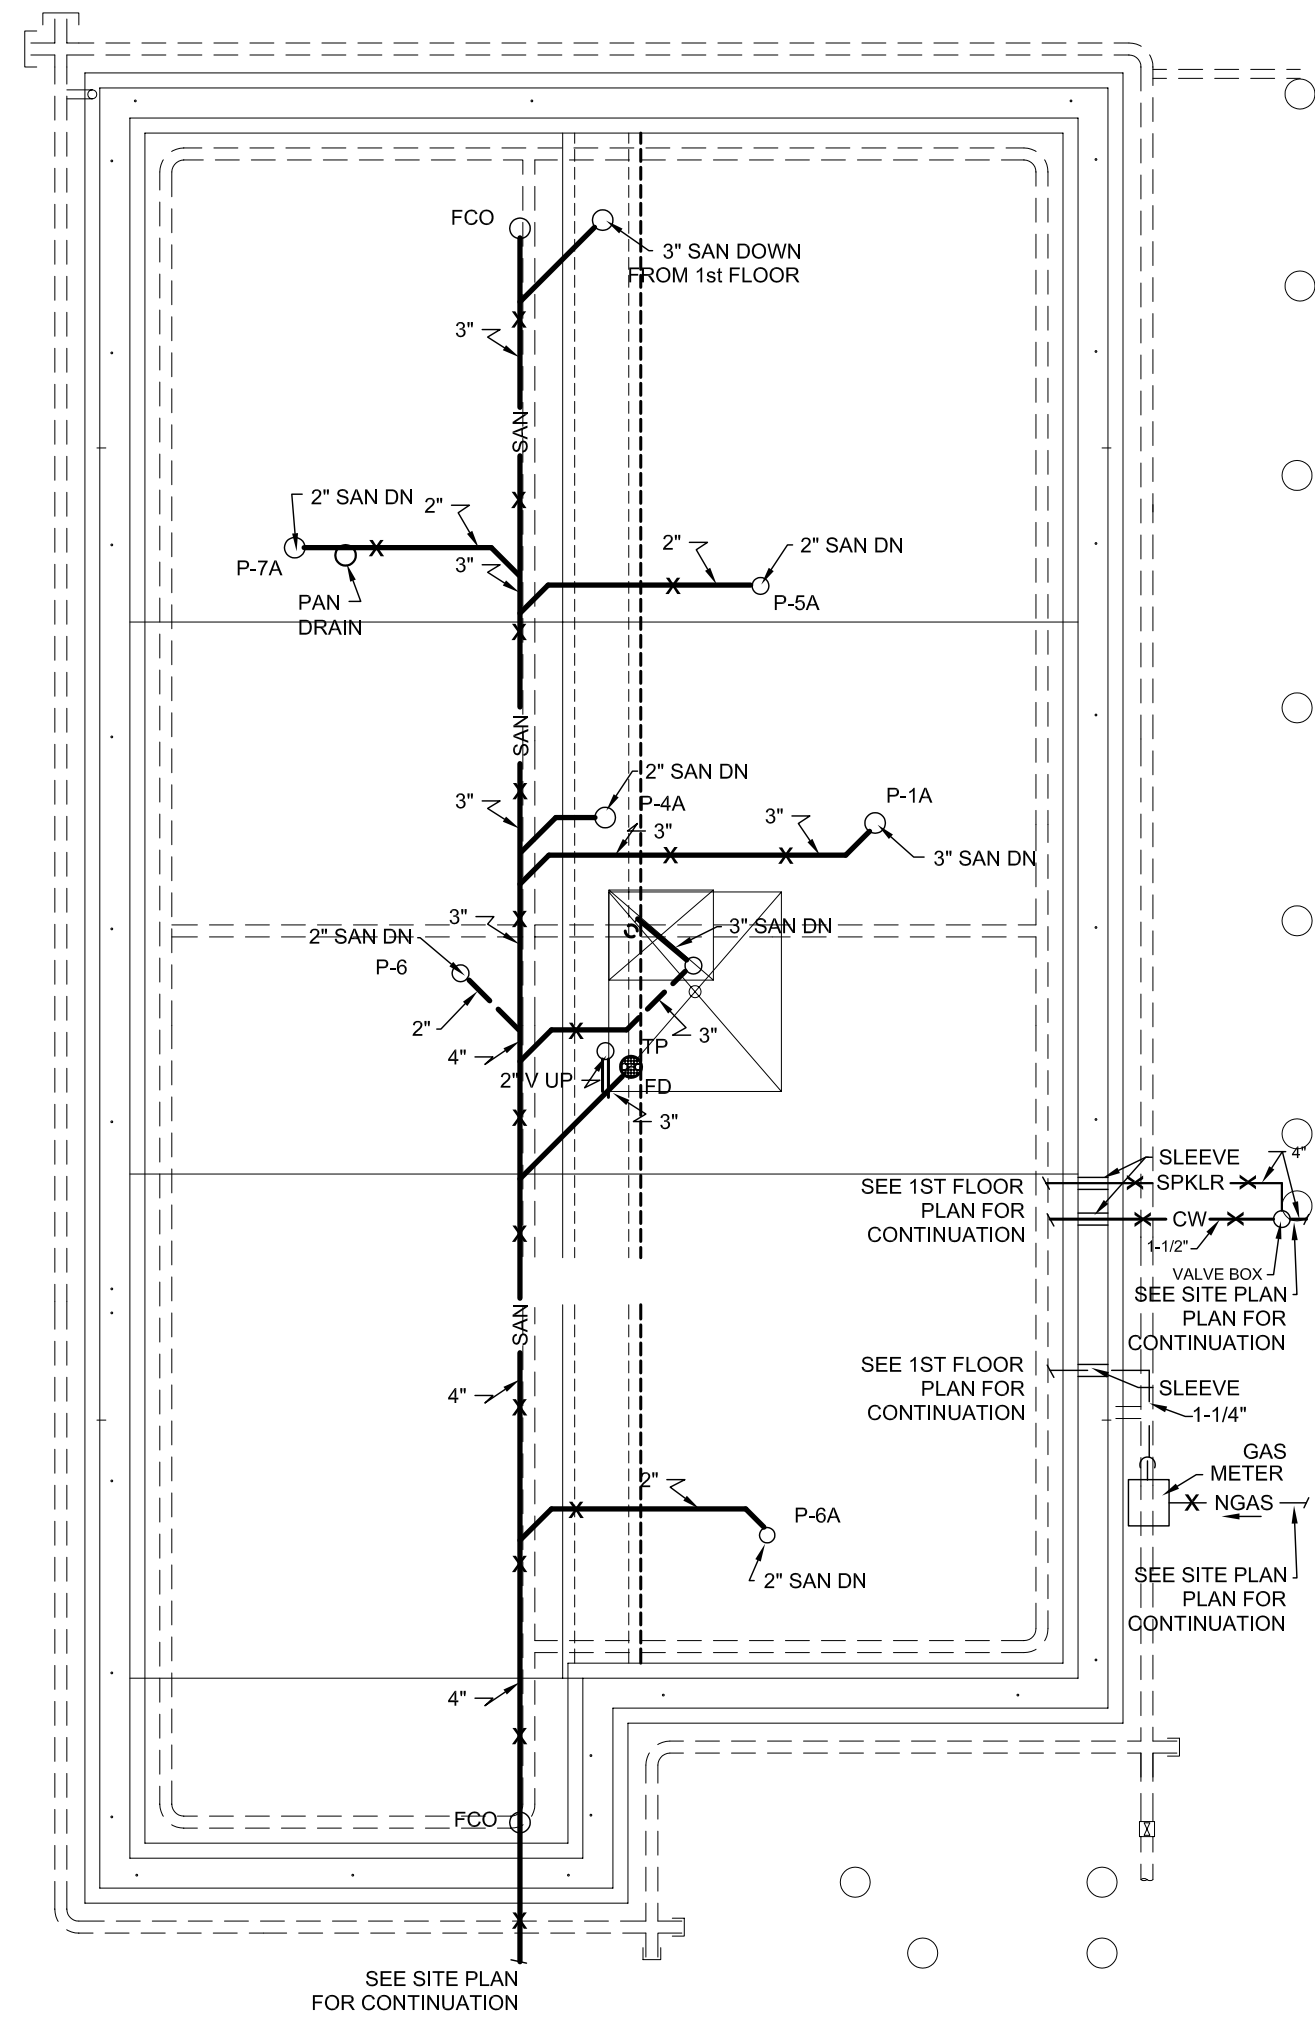


1 SLAB PLAN  
M1.2 3/16" = 1'-0"

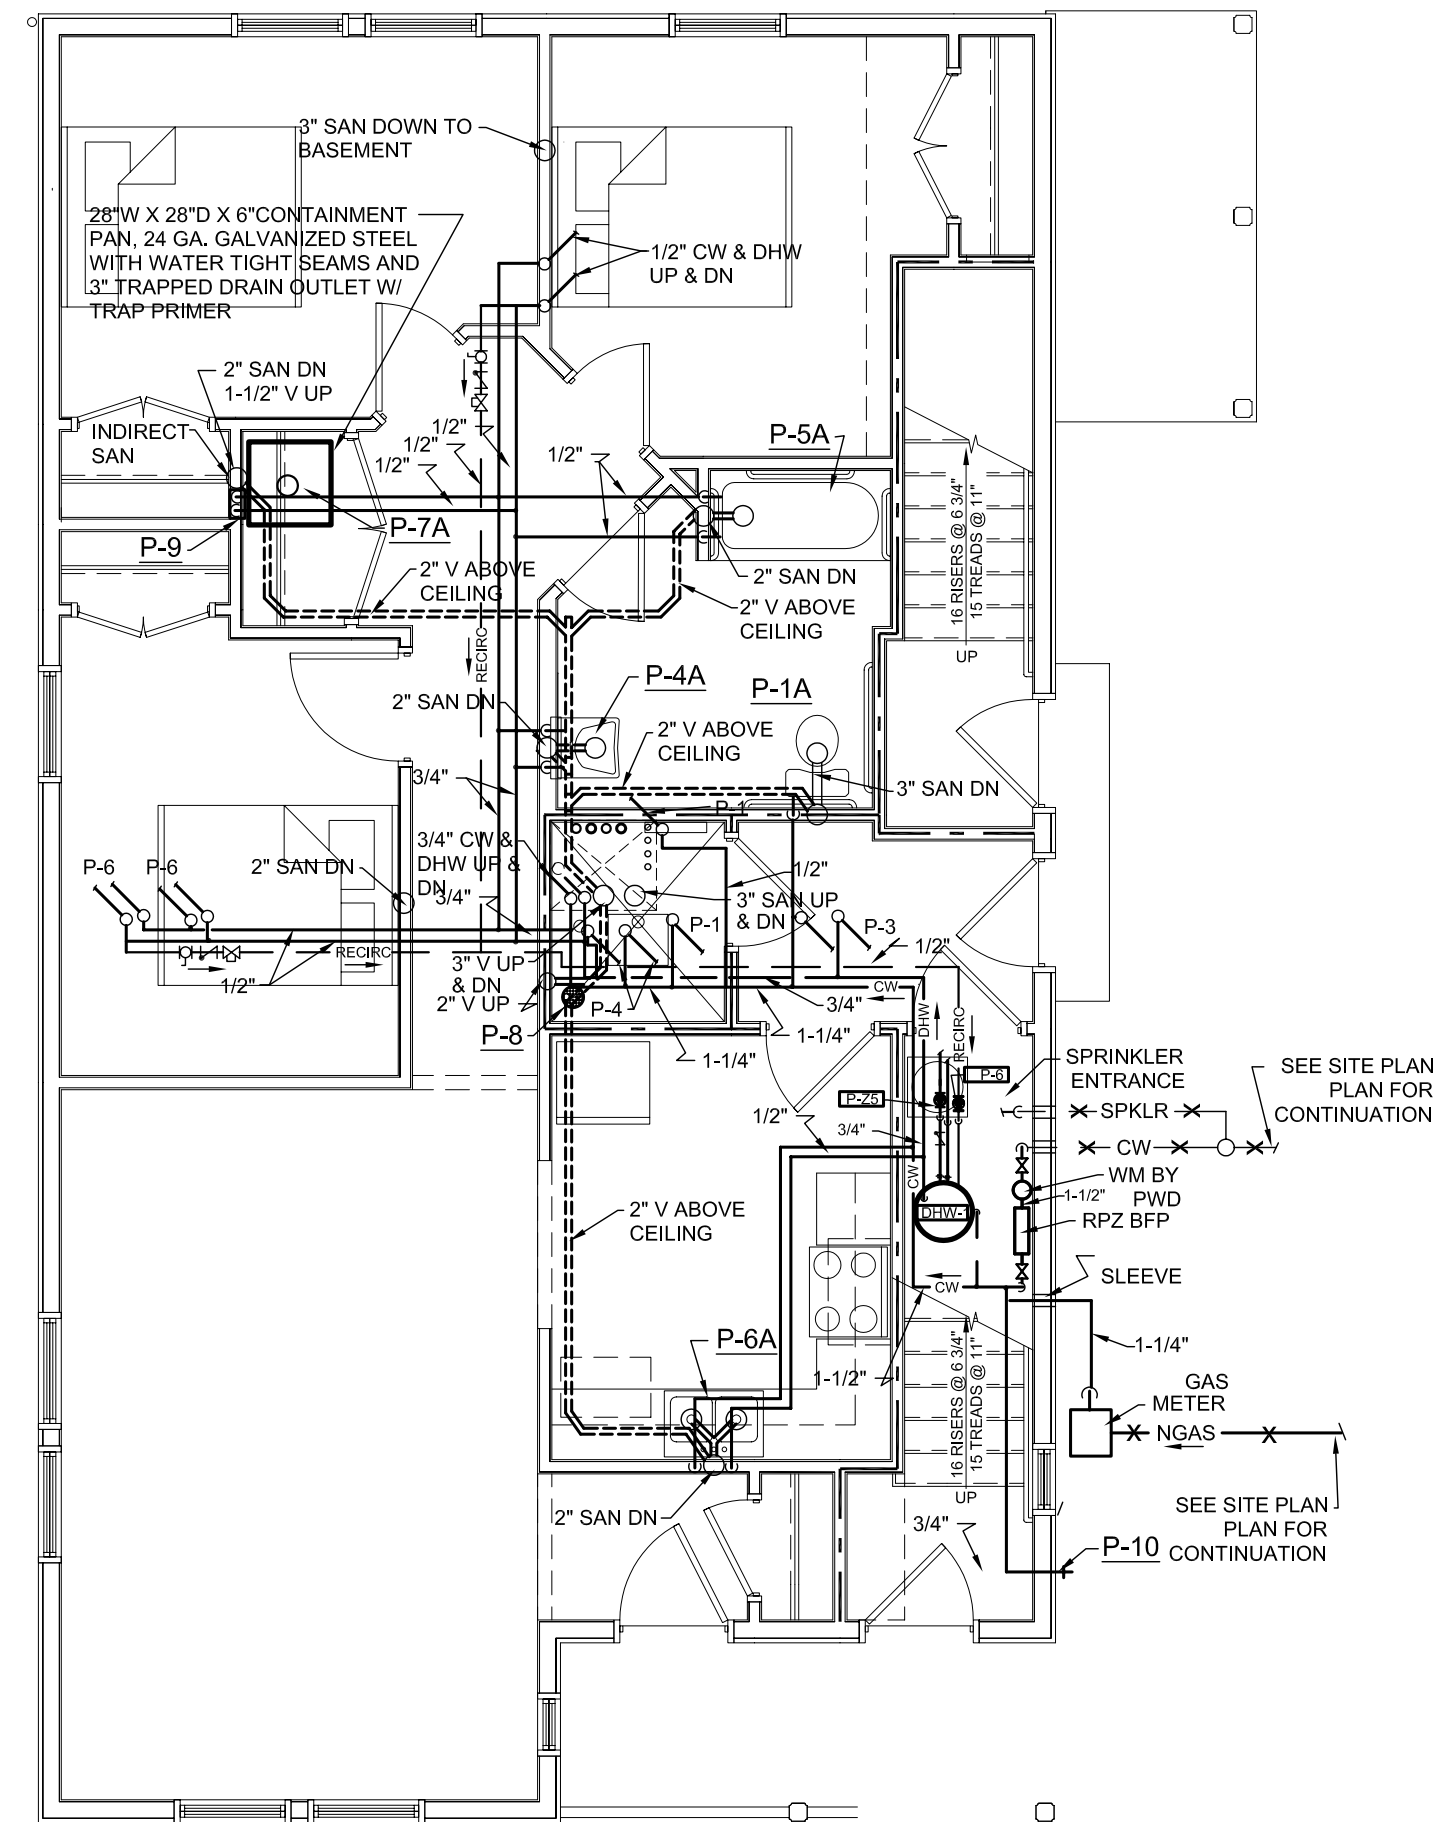

2 FIRST FLOOR  
M1.2 3/16" = 1'-0"

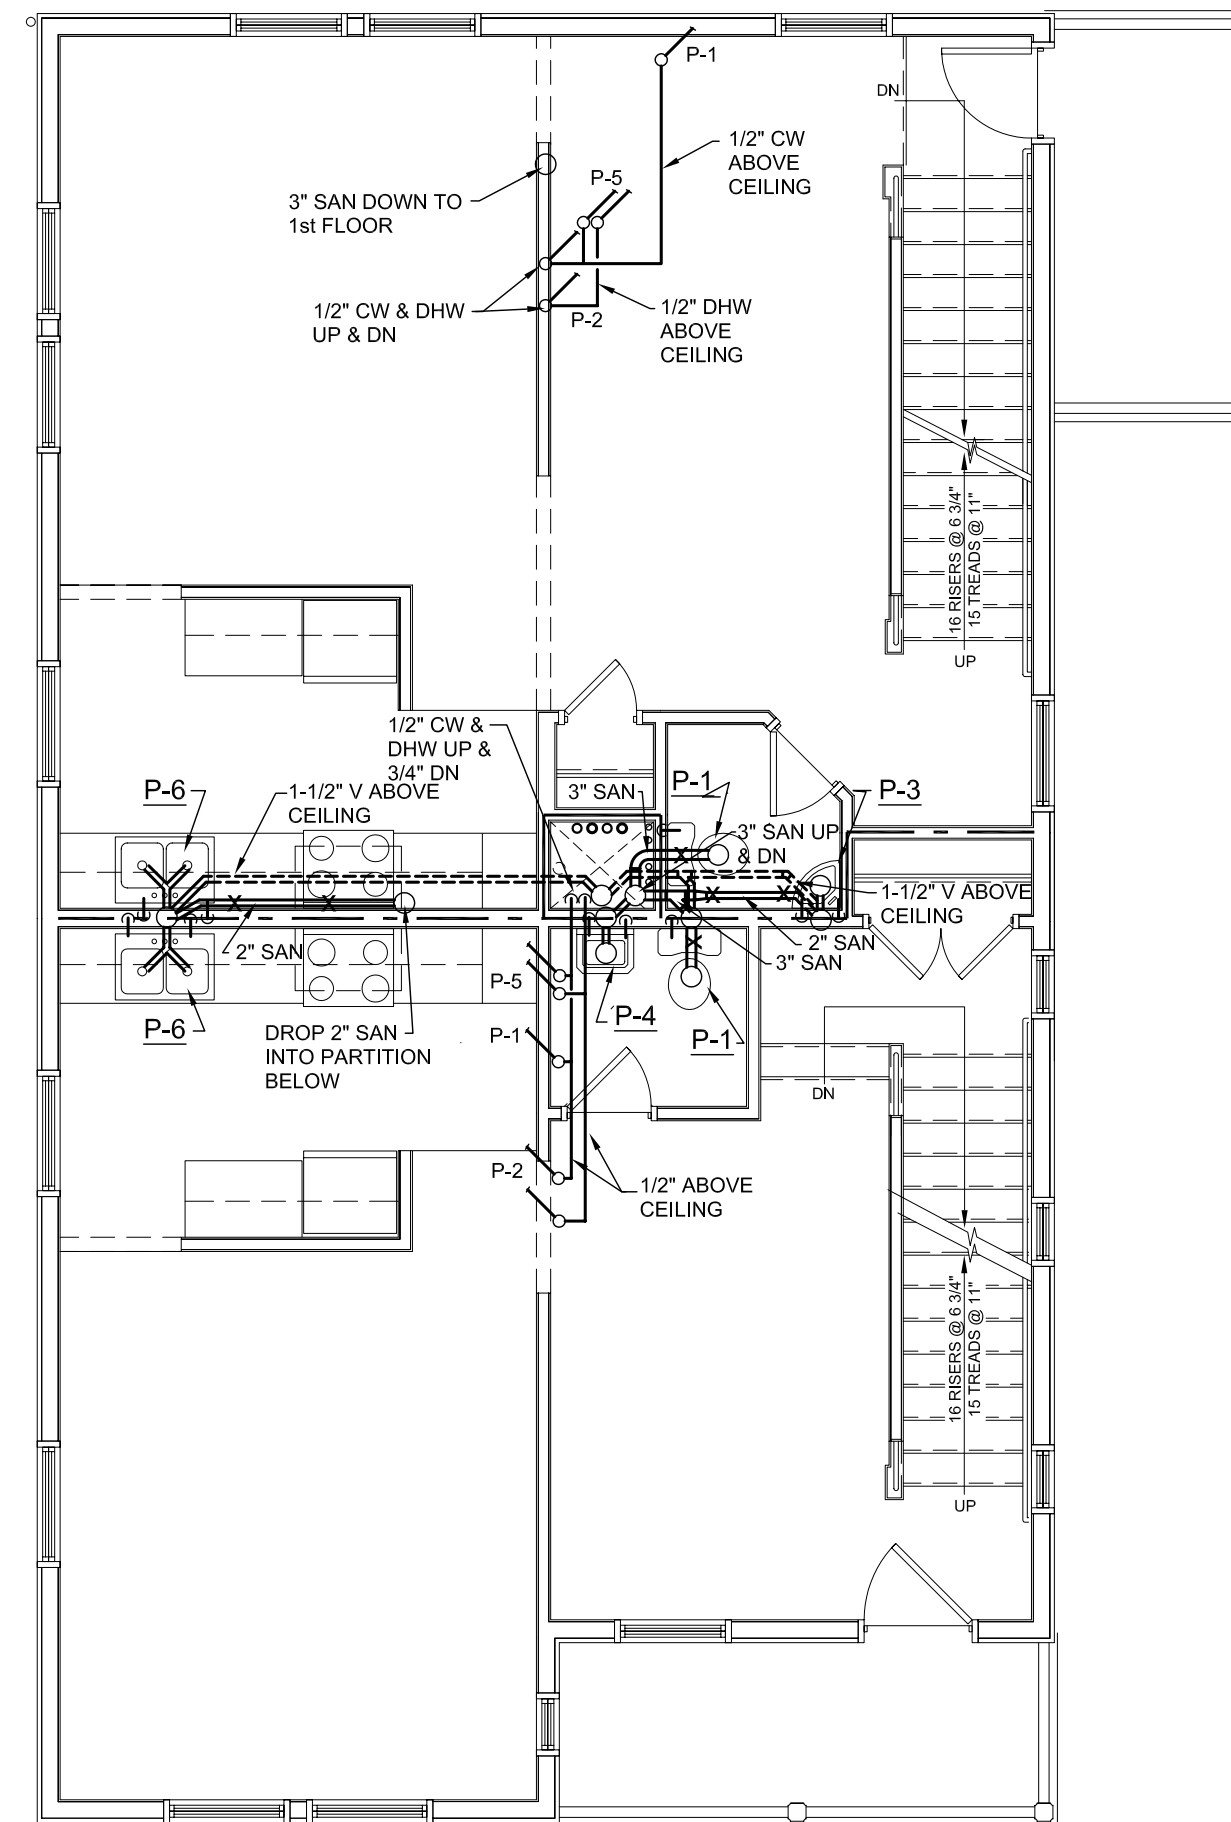

3 SECOND FLOOR  
M1.2 3/16" = 1'-0"

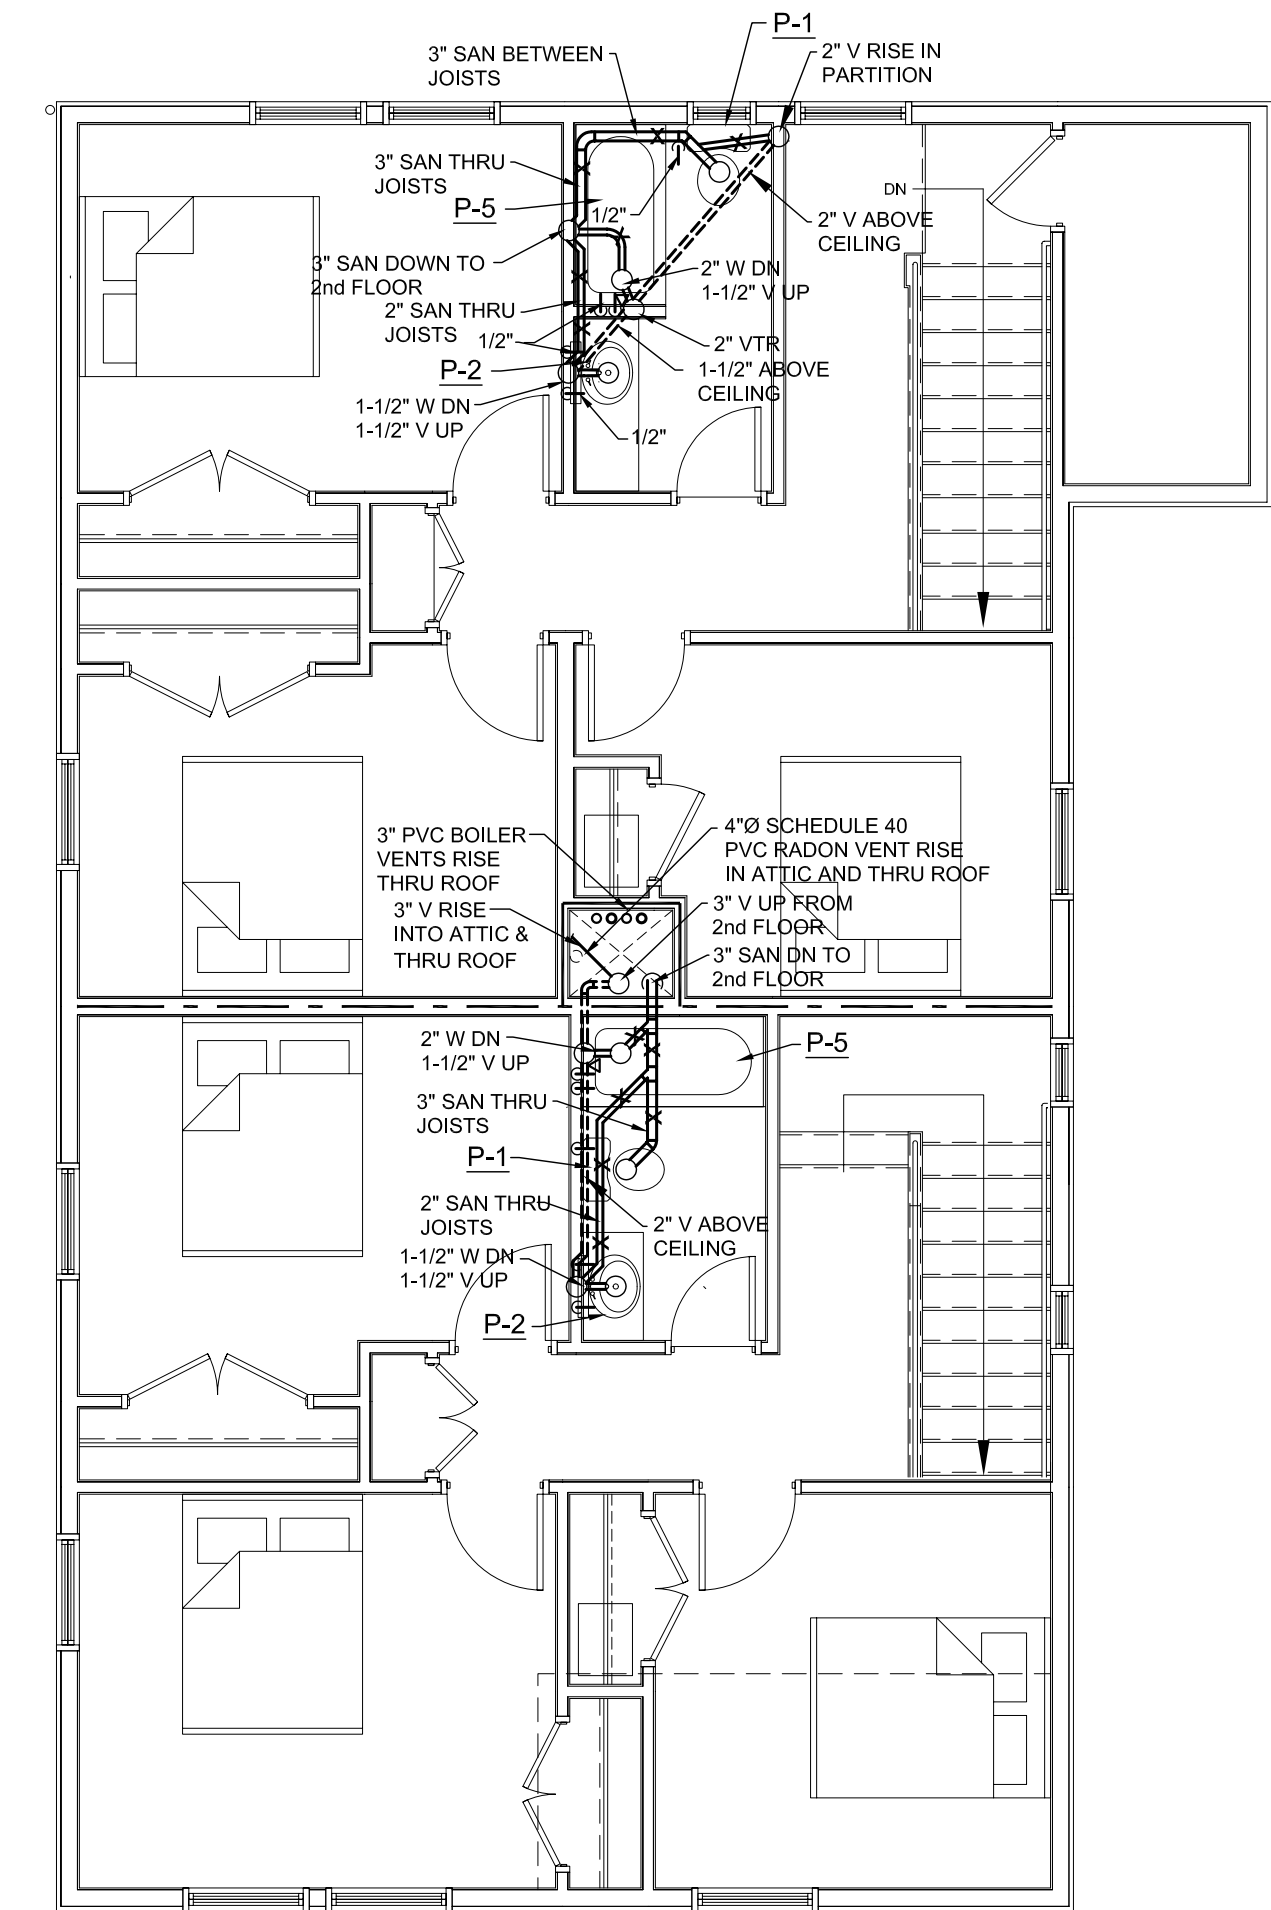

4 THIRD FLOOR  
M1.2 3/16" = 1'-0"