

WASHINGTON BATHS

AKASHA 155 LLC
PORTLAND, MAINE


LEGEND

EXISTING

REFER TO THE EXISTING CONDITIONS PLAN FOR ADDITIONAL INFORMATION



PROPOSED

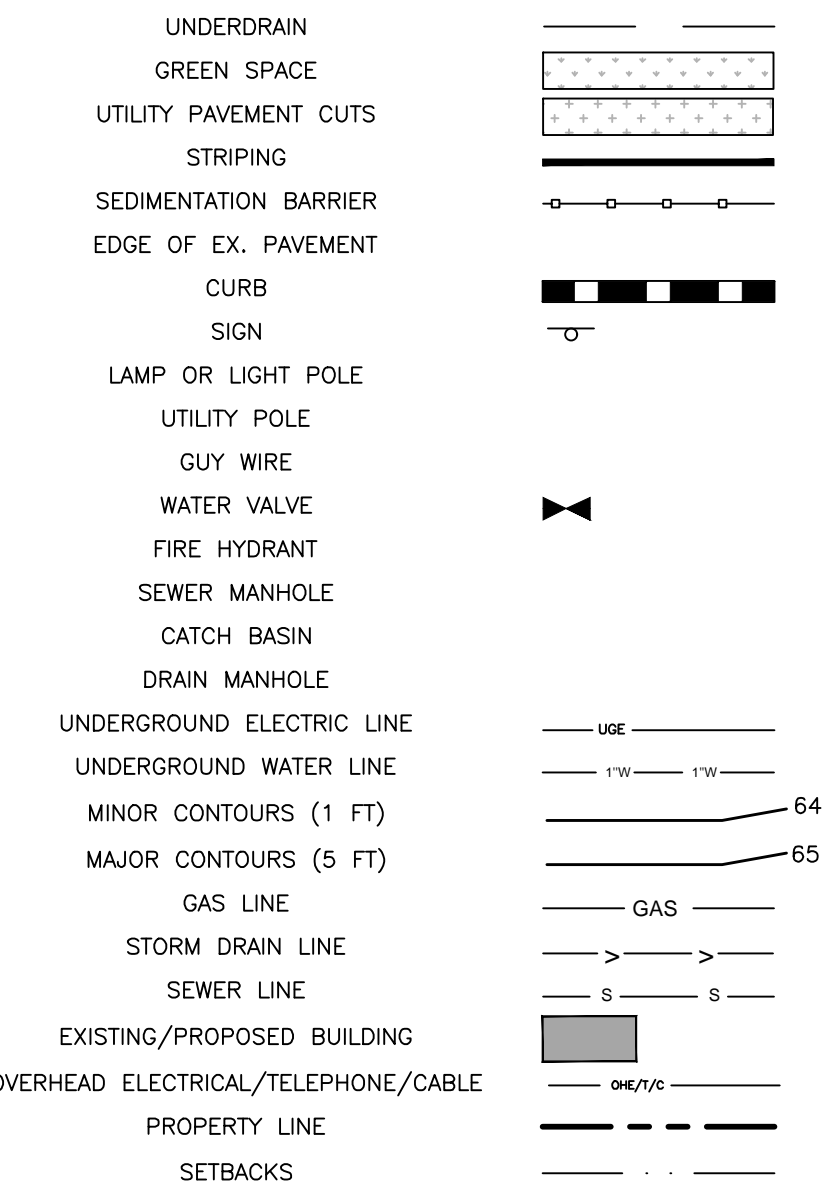

INDEX

- C-01 COVER SHEET & LEGEND
- C-02 GENERAL NOTES
- EX EXISTING CONDITIONS PLAN – BY R.W. EATON ASSOCIATES
- C-03 CONSTRUCTION MANAGEMENT & EROSION CONTROL PLAN
- C-10 SITE PLAN
- L-1 LANDSCAPE PLAN
- C-20 UTILITY PLAN
- C-30 GRADING & DRAINAGE PLAN
- C-40 SITE DETAILS
- C-41 LANDSCAPING DETAILS
- C-42 UTILITY DETAILS – 1
- C-43 UTILITY DETAILS – 2
- C-44 DRAINAGE DETAILS
- C-45 EROSION & SEDIMENTATION CONTROL DETAILS

CALL BEFORE YOU DIG
1-888-DIG-SAFE
1-888-344-7233

UTILITIES

SEWER:

DEPARTMENT OF PUBLIC WORKS (DPW)
55 PORTLAND STREET
PORTLAND, MAINE 04101
CONTACT: KEITH GRAY, P.E.
(207) 874-8834

WATER:

PORTLAND WATER DISTRICT
225 DOUGLASS STREET
PO BOX 3553
PORTLAND, MAINE 04104
ATTN: MEANS DIVISION
(207) 774-5961

ELECTRIC:

CENTRAL MAINE POWER COMPANY (CMP)
162 CANCO ROAD
PORTLAND, MAINE 04103
CONTACT: PAUL DUPERRÉ
(207) 828-2882

TELEPHONE:

CONSOLIDATED COMMUNICATIONS
(FORMERLY FAIRPOINT)
45 FOREST AVENUE
PORTLAND, MAINE 04101
CONTACT: PAT MORRISON
(207) 745-9363

CABLE:

SPECTRUM CABLE
118 JOHNSON ROAD
PORTLAND, MAINE 04102
CONTACT: MARK PELLETIER
(877) 546-0962

NATURAL GAS:

UNITIL SERVICE CORP
1075 FOREST AVENUE
PORTLAND, ME 04103
CONTACT: SCOTT CARPENTER
(207) 541-2543

PROJECT TEAM

DEVELOPER:

AKASHA 155 LLC
PO BOX 11546
PORTLAND, MAINE 04104
CONTACT: ASHER WOODWORTH
(207) 332-4911

ARCHITECT:

KIEL MOE & DECENTRALIZED DESIGN LAB
CONTACT: KIEL MOE, RA
(617) 843-5435

SURVEYOR:

R.W. EATON ASSOCIATES
WESTBROOK, MAINE
CONTACT: RICHARD EATON, P.L.S.
(207) 854-2402

STRUCTURAL ENGINEER:

STRUCTURAL INTEGRITY CONSULTING ENGINEERS, INC.
46 FOREST AVENUE
PORTLAND, MAINE 04101
CONTACT: AARON JONES
(207) 774-4614

ABBREVIATIONS

PARTIAL LIST OF ABBREVIATIONS AND THEIR CORRESPONDING MEANING. PLEASE CONTACT THE ENGINEER FOR ANY CLARIFICATION

APPROX.	APPROXIMATE
BC	BOTTOM OF CURB
BMP	BEST MANAGEMENT PRACTICE
BOT.	BOTTOM
CB	CATCH BASIN
CF	CUBIC FOOT
CIP	CAST IN PLACE
CM	CONSTRUCTION MANAGER
CMP	CENTRAL MAINE POWER
CONC.	CONCRETE
CY	CUBIC YARD
DIP	DUCTILE IRON PIPE
DIA.	DIAMETER
DIM.	DIMENSION
EA.	EACH
ELEC.	ELECTRICAL
ELEV.	ELEVATION
EQUIV.	EQUIVALENT
EST.	ESTIMATE
EX.	EXISTING
FFE	FINISH FLOOR ELEVATION
FT.	FEET
GAL.	GALVANIZED
ID	INNER DIAMETER
IN.	INCH
INV.	INVERT
L	LENGTH
MAX.	MAXIMUM
MDOT	MAINE DEPARTMENT OF TRANSPORTATION
MFG.	MANUFACTURED
MH	MANHOLE
MIN.	MINIMUM
O.C.	ON CENTER
OD	OUTSIDE DIAMETER
OHE/T/C	OVERHEAD ELECTRIC/TELEPHONE/CABLE
PC	PRECAST
PE	PROFESSIONAL ENGINEER
PL	PROPERTY LINE
PLS	PROFESSIONAL LAND SURVEYOR
PROP.	PROPOSED
PSI	POUNDS PER SQUARE INCH
PVC	POLYVINYL CHLORIDE
PWD	PORTLAND WATER DISTRICT
R	RADIUS
RD	ROOF DRAIN
RET.	RETAINING
ROW	RIGHT OF WAY
S	SLOPE
SD	STORM DRAIN
SDR	STANDARD DIMENSION RATIO
SF	SQUARE FEET
SMH	SEWER MANHOLE
SPEC.	SPECIFICATION
TC	TOP OF CURB
TW	TOP OF WALL
TYP.	TYPICAL
UD	UNDERDRAIN
UGE	UNDERGROUND ELECTRIC

ISSUED FOR	BY
DATE	DATE
LEVEL II SITE PLAN	WHS 10/03/18

DRAWING NAME: CONSTRUCTION MANAGEMENT PLAN
PROJECT NAME: WASHINGTON BATHS
CLIENT: AKASHA 155 LLC
PO BOX 11546, PORTLAND, ME 04104

ACOORN ENGINEERING, INC.
158 BANKFOUR ST. PORTLAND, MAINE 04102
(207) 775-2655

FILE: 1108_DETAILS


JN: 1108

SCALE: NTS

DESIGNED BY: SJL

DRAWN BY: FRT

CHECKED BY: WHS

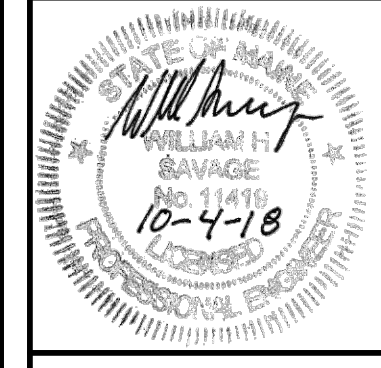

PERMIT LEVEL
NOT ISSUED FOR
CONSTRUCTION

DRAWING NO.
C-01