


89 Anderson Street  
Portland, ME

OWNER  
Redfern Properties  
P.O. Box 8816  
Portland, ME

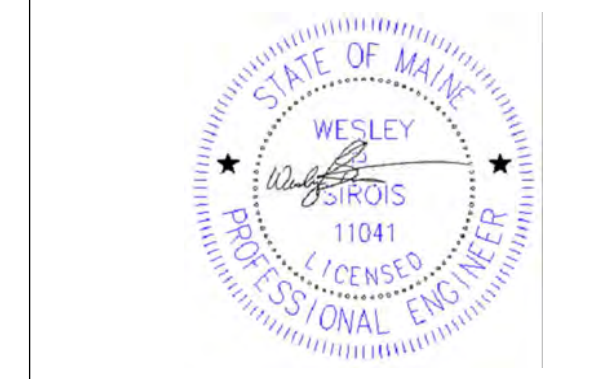

001 7/3/15 Permit Set NOT FOR CONSTRUCTION  
WORK SET DESCRIPTION  
SCALE: 1/4" = 1'  
PROJECT NO:  
CAD DWG FILE: M-2.1.DWG  
DRAWN BY: WFS  
CHECKED BY: HHH  
COPYRIGHT:

SHEET TITLE  
**2nd Floor HVAC Plan**

M-2.1  
SHEET SHEET INDEX OF TOTAL SHEETS