


89 Anderson Street  
Portland, ME

OWNER  
Redfern Properties  
P.O. Box 8816  
Portland, ME

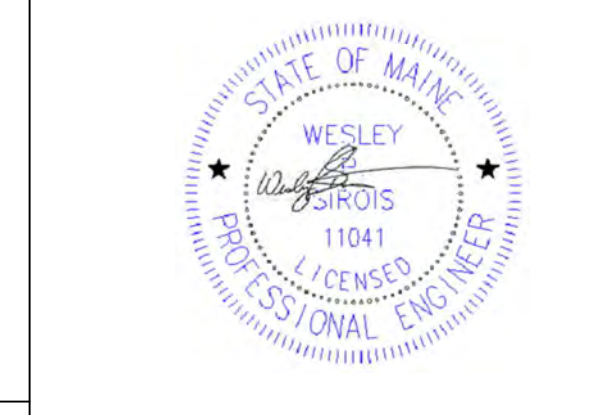

DATE	17/1/15	PROJECT	RENT FOR CONSTRUCTION
WORK	TYPE	DESCRIPTION	
SCALE	1/4" = 1'		
PROJECT NO.			
CAD DWG FILE	M-5.1.DWG		
DRAWN BY	WFS		
CHECKED BY	HHH		
COPYRIGHT			

PROJECT NUMBER  
M-5.1

SHEET TITLE  
Roof HVAC Plan

SHEET INDEX  
M-5.1 OF TOTAL SHEETS