


89 Anderson Street
Portland, ME

OWNER
Redfern Properties
P.O. Box 8816
Portland, ME

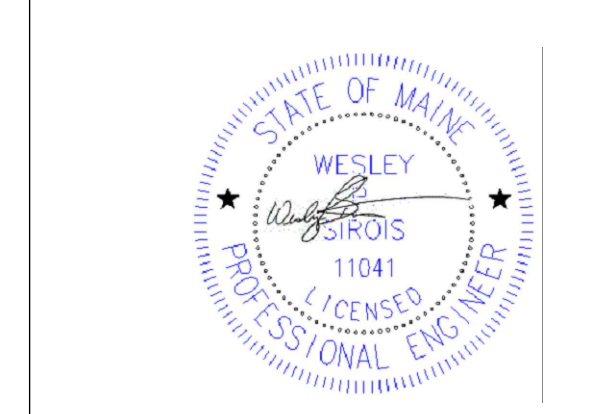

002 10/12/13 FOR CONSTRUCTION
001 7/3/15 Permit Set NOT FOR CONSTRUCTION
WORK TITLE DESCRIPTION
SCALE: 1/4" = 1'
PROJECT NO:
CAD DWG FILE: M-2.1.DWG
DRAWN BY: WFS
CHK'D BY: HHH
COPYRIGHT:

SHEET TITLE
2nd Floor HVAC Plan