


Schedule											
Symbol	Label	Quantity	Manufacturer	Catalog Number	Description	Lamp	Number Lamps	Filename	Lumens Per Lamp	Light Loss Factor	Wattage
□	A	3	Juno	MSL2-35K-UN-XX	Mini Wall Pack; mounted at 8ft	LED	1	MSL2-35K-UN-XX Led (164CHI-001).IES	662.7201	0.9	11
○	B	2	Juno	L6 08LM 35K MVOLT G3 80CRI EZ1 P CS WET	INDY 6" DIA. 1-LED 800K, 35K 80 CRI, LENS LITE W/ CLEAR SPECULAR ALZAK (CL) PARABOLIC CONE & FROSTED CONVEX GLASS LENS; mounted at 10ft	LED	1	L6-1340U-G3+L600P-CL.ies	1084	0.55	7.7

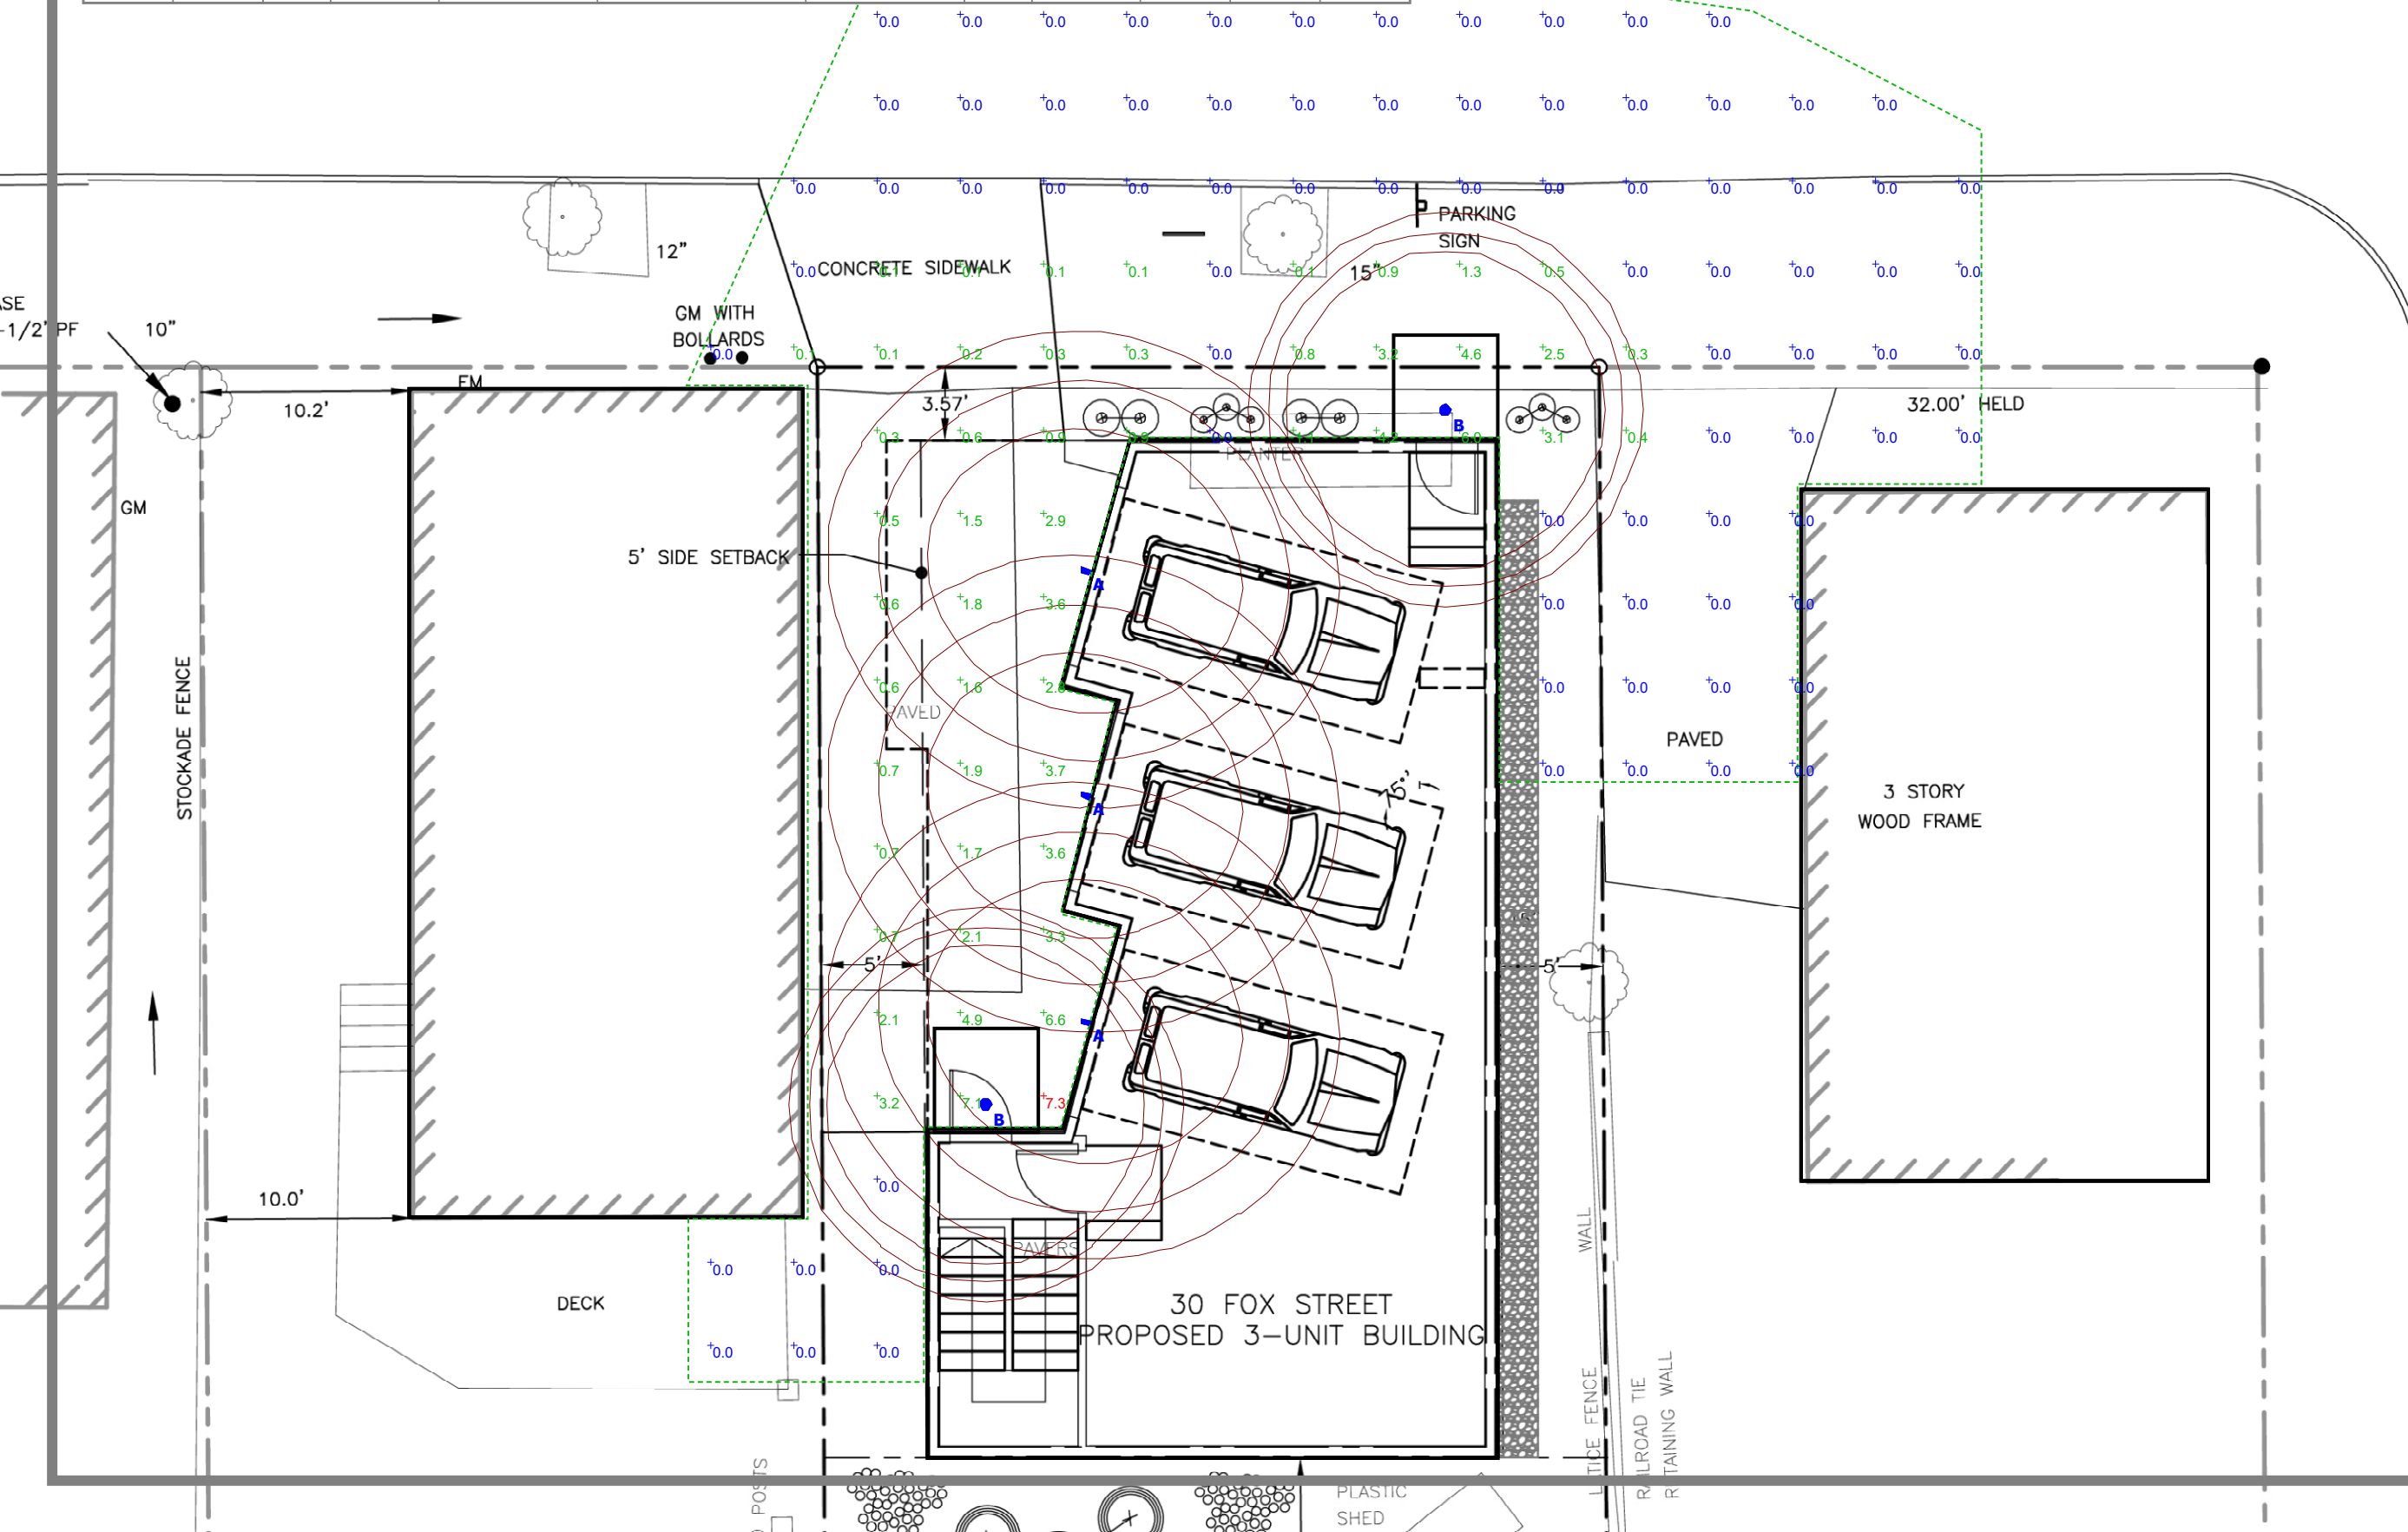

30 FOX ST Portland, ME Lighting Layout

Designer
Heidi G. Connors
Visible Light, Inc.
24 Stickney Terrace
Suite 6
Hampton, NH 03842

Date
9/20/2017

Scale
1"=8'

Drawing No.

Summary