

© 2017 RYAN SENATORE ARCHITECTURE

MAINE CRAFT DISTILLING
123 WASHINGTON STREET
PORTLAND, MAINE



RYAN SENATORE ARCHITECTURE
565 CONGRESS STREET
PORTLAND, MAINE 04101
207-650-6414
senatorearchitecture.com

CONSULTANTS:

REVISIONS:

DATE: FEBRUARY 14, 2017

PROJECT No. 1666


DRAWN BY: RRT

CHECKED BY: RJS

SCALE: AS NOTED

SHEET TITLE:
REFLECTED CEILING PLAN

A1-2

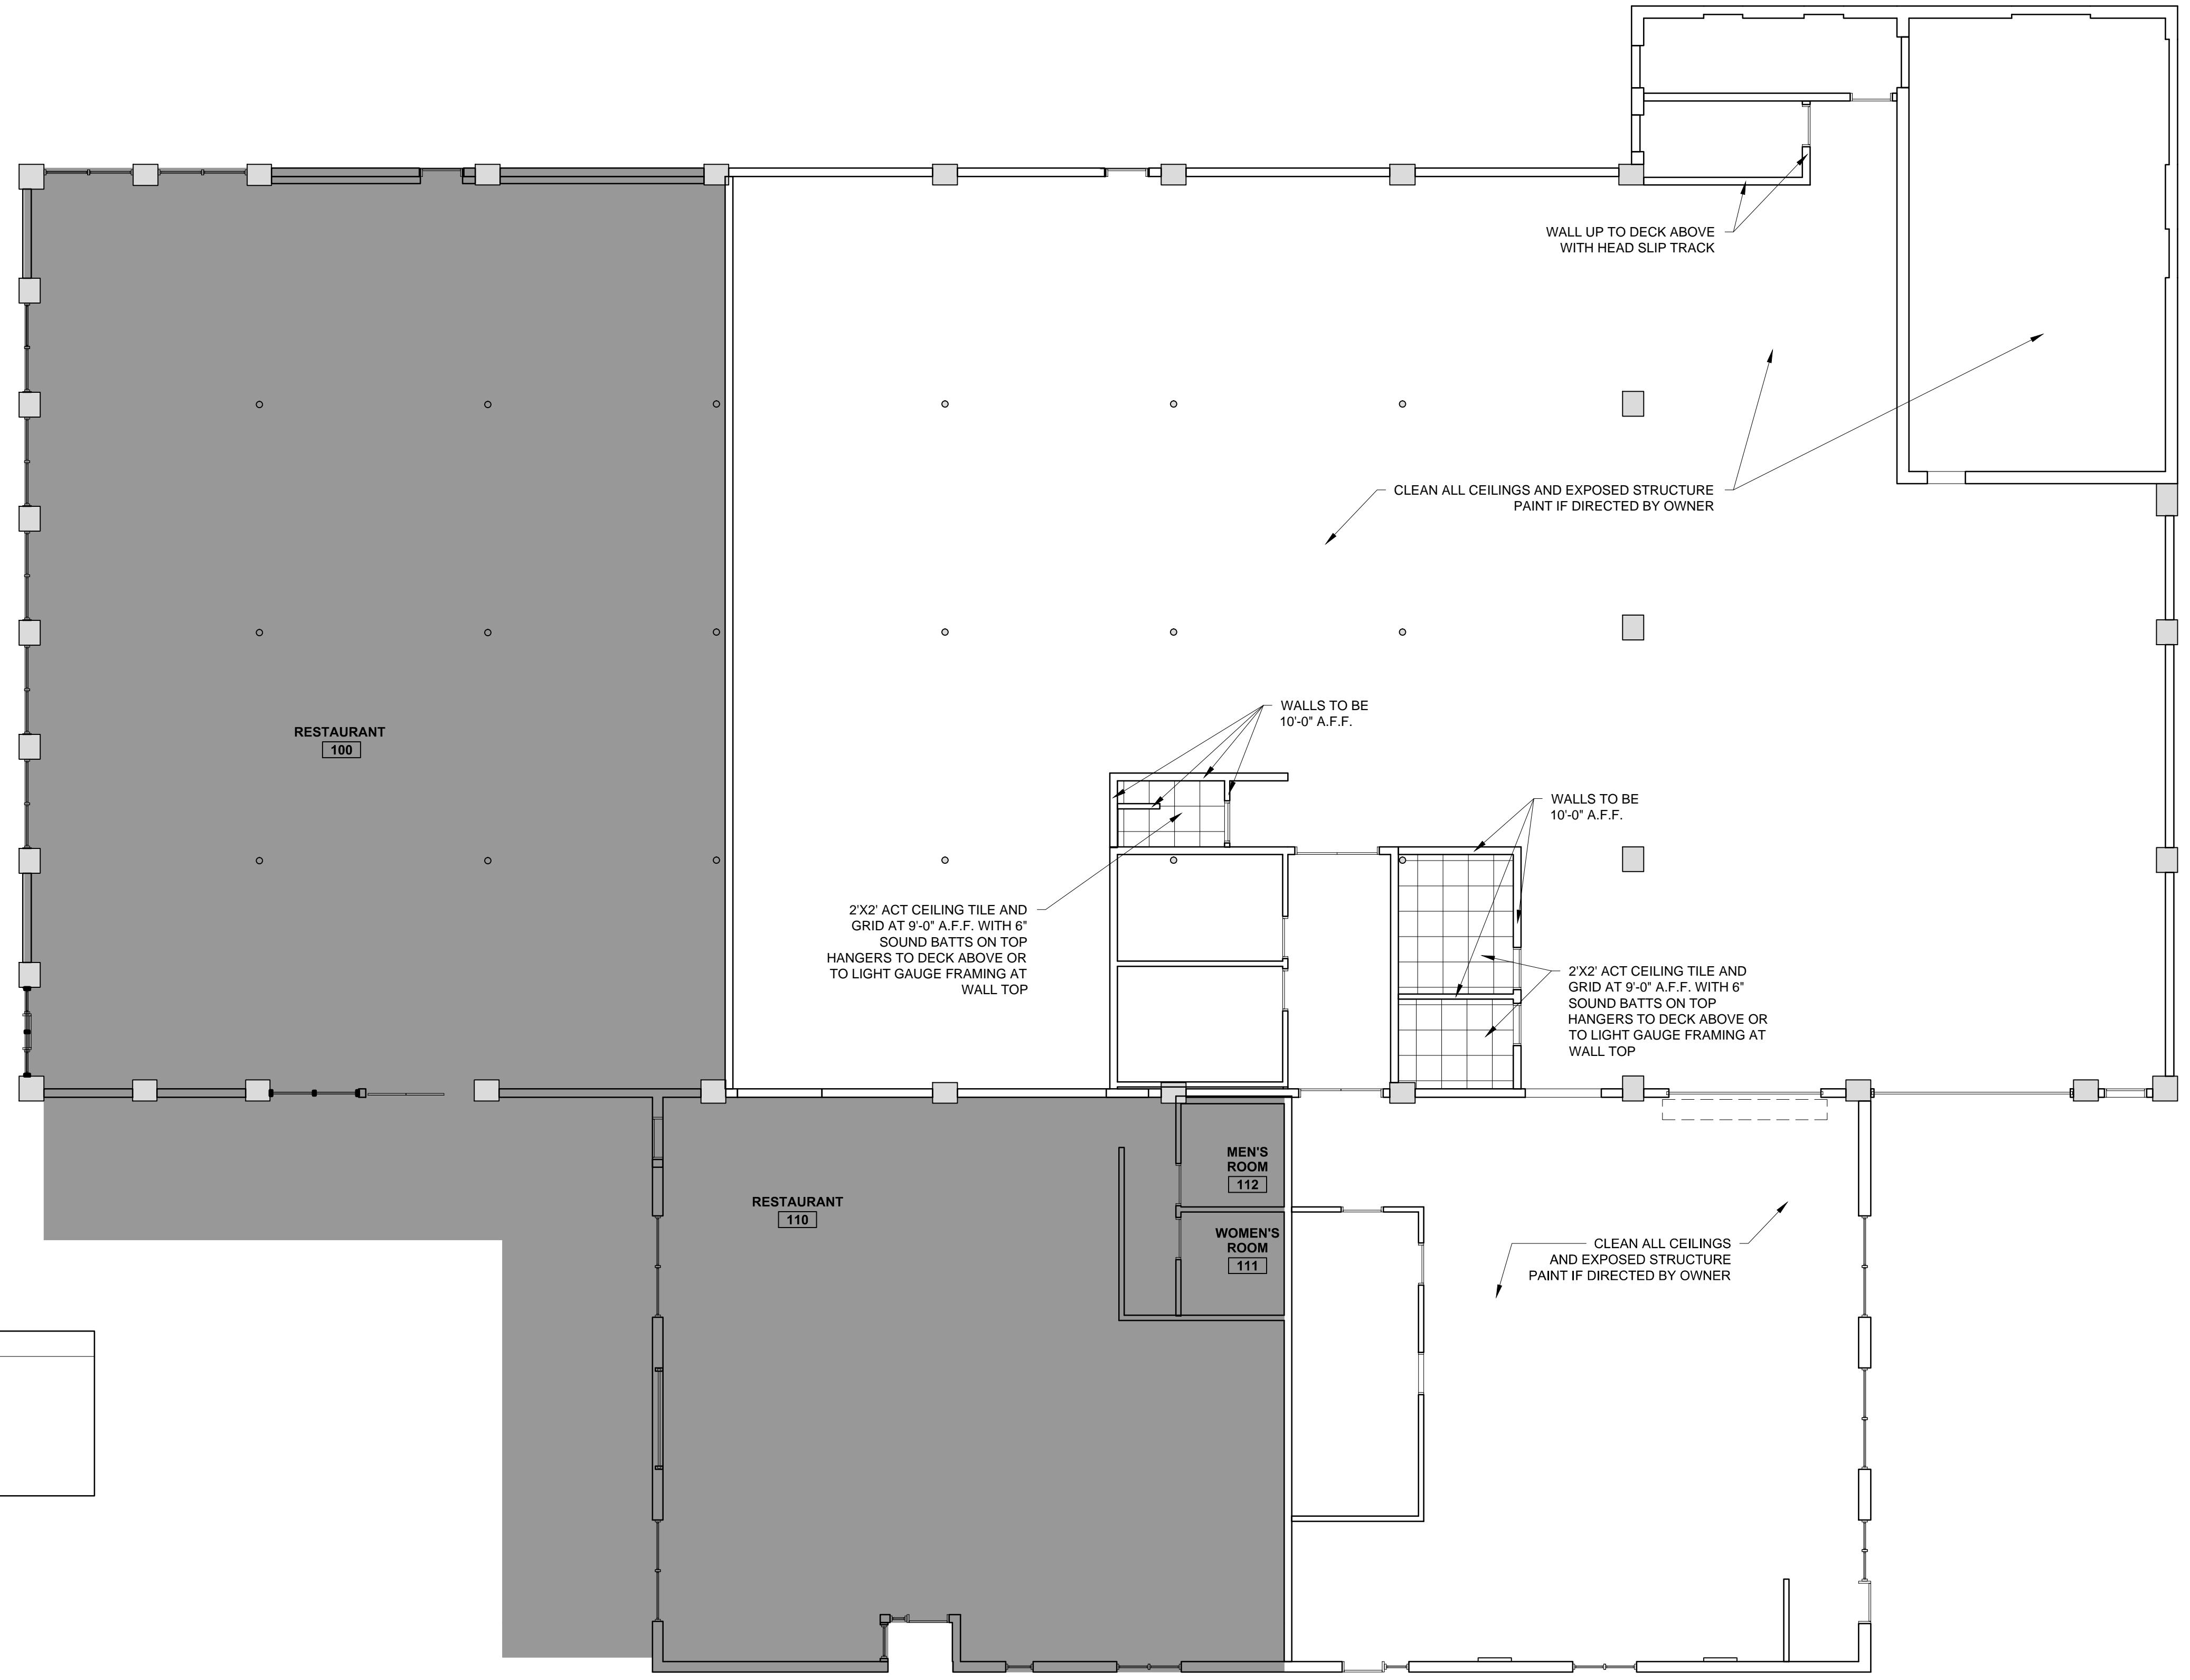

RCP NOTES
1.) LIGHTS NOT SHOWN - TBD BY OWNER



1 REFLECTED CEILING PLAN
1/8" = 1'-0"