

© 2017 RYAN SENATORE ARCHITECTURE

**MAINE CRAFT DISTILLING**  
123 WASHINGTON STREET  
PORTLAND, MAINE



RYAN SENATORE ARCHITECTURE  
565 CONGRESS STREET  
PORTLAND, MAINE 04101  
207-650-6414  
senatorearchitecture.com

CONSULTANTS:

REVISIONS:

DATE: FEBRUARY 14, 2017

PROJECT No. 1666

DRAWN BY: RRT

CHECKED BY: RJS


SCALE: AS NOTED

SHEET TITLE:  
DOOR AND WINDOW SCHEDULE


A7-0

**DOOR SCHEDULE**

- DOOR NOTES:**
- 1.) ALL EXTERIOR GLAZING TO BE LOW-E ARGON FILLED INSULATED GLAZING UNITS
  - 2.) FRAME ALL OPENINGS WITH ELEVATIONS
  - 3.) SEAL EXTERIOR DOORS TO ROUGH OPENING WITH LOW EXPANDING FOAM INSULATION - SEE DETAILS
  - 4.) ALL DOOR HARDWARE TO BE 'LEVER' TYPE
  - 5.) ALL EXTERIOR DOORS TO BE WEATHERSTRIPPED

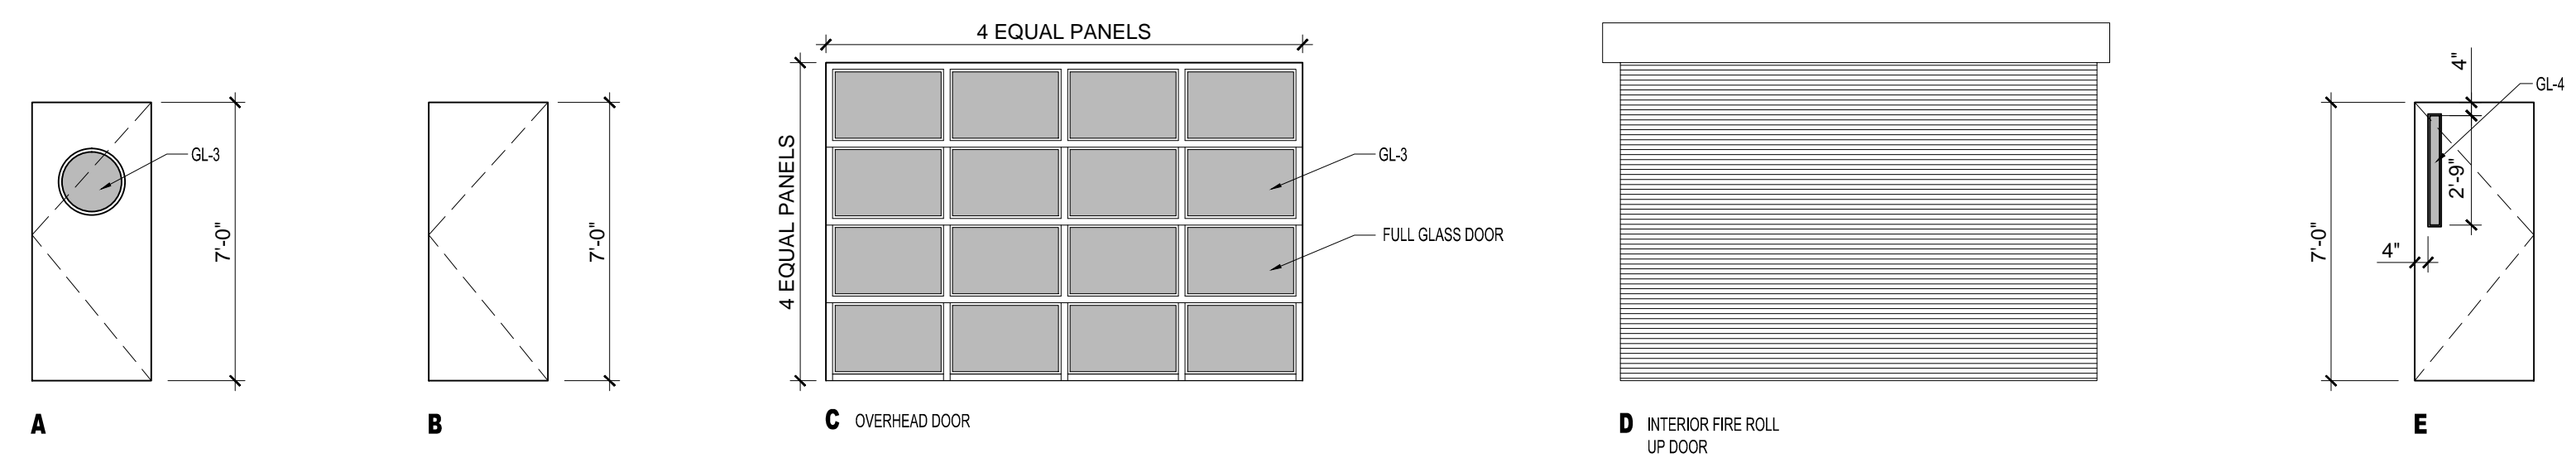

**FRAME TYPES**

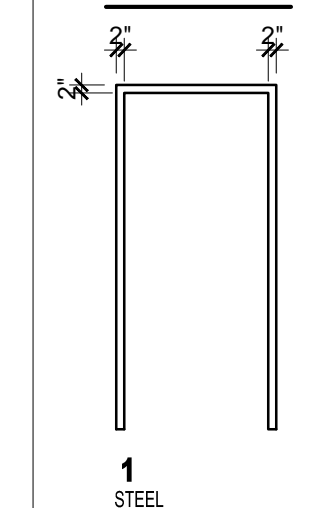

**GLAZING SCHEDULE**

KEY	GLAZING TYPE
GL-1	INSULATED CLEAR TEMPERED GLAZING
GL-2	FIRE RATED INSULATED GLAZING
GL-3	CLEAR TEMPERED GLASS
GL-4	CLEAR INSULATED TEMPERED GLASS
GL-5	FIRE RATED GLAZING


1 DOOR TYPES  
1/4" = 1'-0"

DOOR		FRAME										GENERAL				
DOOR NO.	TYPE	SIZE			MATERIAL	FINISH	INSULATED	TYPE	MATERIAL	THRESHOLD	DETAILS			CLOSER	FIRE RATING (MINUTES)	REMARKS
		WIDTH	HEIGHT	THICKNESS							HEAD	JAMB	SILL			
121.1	C	12'-0"	8'-0"	1-3/4"	AL	PTD	-	-	AL	-	-	-	-	-	-	FULL GLASS OVERHEAD DOOR WITH CHAIN PULL, LOCK
121.2	D	12'-0"	8'-0"	-	STL	PTD	-	-	STL	-	-	-	-	Y	60	FIRE RATED OVERHEAD ROLLING DOOR WITH AUTOMATIC CLOSER TIED TO FIRE ALARM SYSTEM WITH LASER EYE SAFTEY FEATURE, OVERHEAD DOOR MODEL 631, FUSEABLE LINK
121.3	E	3'-0"	7'-0"	1-3/4"	STL	PTD	Y	1	STL	AL	-	-	-	Y	-	THERMALLY BROKEN STEEL DOOR WITH PANIC HARDWARE
125.1	B	3'-0"	7'-0"	1-3/4"	STL	PTD	Y	1	STL	AL	-	-	-	Y	60	PANIC HARDWARE
127.1	A	3'-0"	7'-0"	1-3/4"	WD	CLR	Y	1	STL	-	-	-	-	Y	-	
128.1	A	3'-0"	7'-0"	1-3/4"	WD	CLR	Y	1	STL	-	-	-	-	Y	-	
131.1	B	3'-0"	7'-0"	1-3/4"	STL	PTD	Y	1	STL	-	-	-	-	Y	-	
132.1	A	3'-0"	7'-0"	1-3/4"	WD	CLR	Y	1	STL	-	-	-	-	-	-	
133.1	A	3'-0"	7'-0"	1-3/4"	WD	CLR	Y	1	STL	-	-	-	-	-	-	

**WINDOW SCHEDULE**

**WINDOW SCHEDULE LEGEND**

- T = TEMPERED GLASS
- FG = FIBERGLASS
- AL = ALUMINUM
- DH = DOUBLE HUNG
- AW = AWNING
- LV = LOUVER
- F = FIXED
- GL = GLIDER

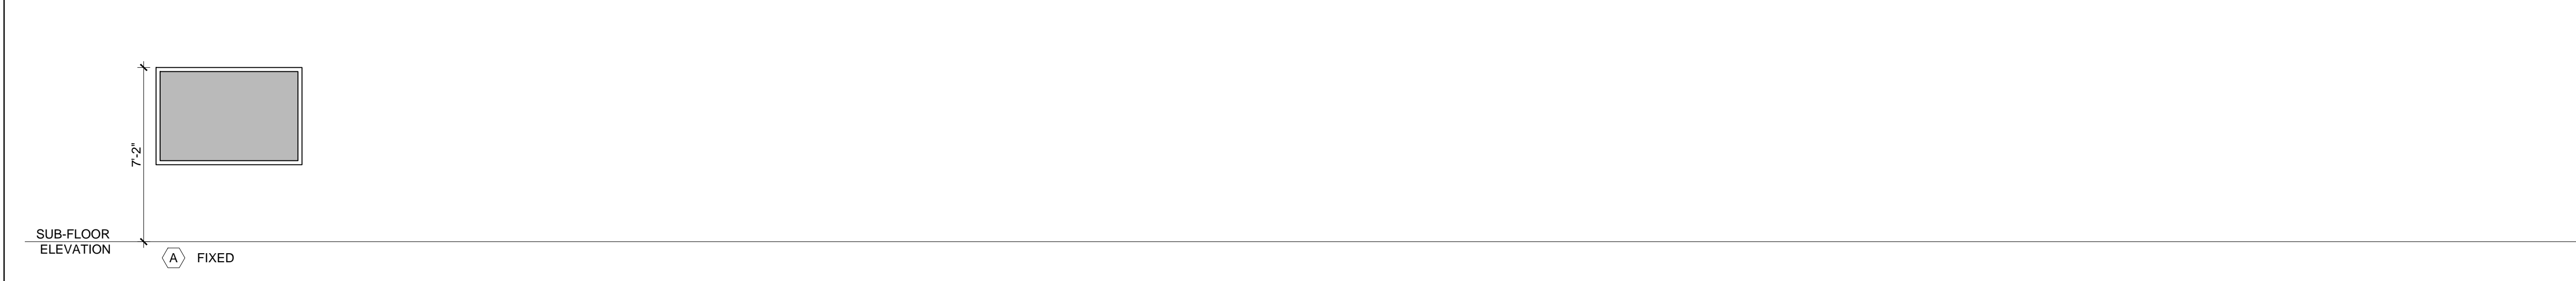

1 WINDOW TYPES  
1/4" = 1'-0"

WINDOW SCHEDULE											
KEY	ACTION	ROUGH OPENING (WH) VIF	RO. HEAD HEIGHT FROM SUB-FLOOR	DETAILS			MATERIAL	FINISH	FOR TEMPERED GLASS LOCATIONS SEE WINDOW ELEVATION TYPES FOR MASONRY OPENING DIMENSIONS COORDINATE COURSING WITH EXTERIOR ELEVATION SHEETS AND PLAN AND SECTION DETAIL SHEETS		
				HEAD	JAMB	SILL			REMARKS		
A	F	6'-1" X 4'-1"	-	-	-	-	STL	PTD	45 MINUTE FIRE RATED WINDOW AND FRAME, CLEAR FIRE RATED, TEMPERED GLASS		

- WINDOW NOTES:**
- 1.) ALL GLAZING LOCATED WITHIN 18" OF FINISHED FLOOR TO BE TEMPERED GLASS