



© 2017 RYAN SENATORE ARCHITECTURE

**MAINE CRAFT DISTILLING**  
123 WASHINGTON STREET  
PORTLAND, MAINE



**RYAN SENATORE ARCHITECTURE**  
565 CONGRESS STREET  
PORTLAND, MAINE 04101  
207-650-6414  
senatorearchitecture.com

CONSULTANTS:

REVISIONS:  
△ REVISION #1 - 5 / 17 / 17

DATE: FEBRUARY 14, 2017

PROJECT No. 1666


DRAWN BY: RRT

CHECKED BY: RJS

SCALE: AS NOTED

SHEET TITLE:  
**REFLECTED CEILING PLAN**

**A1-2**

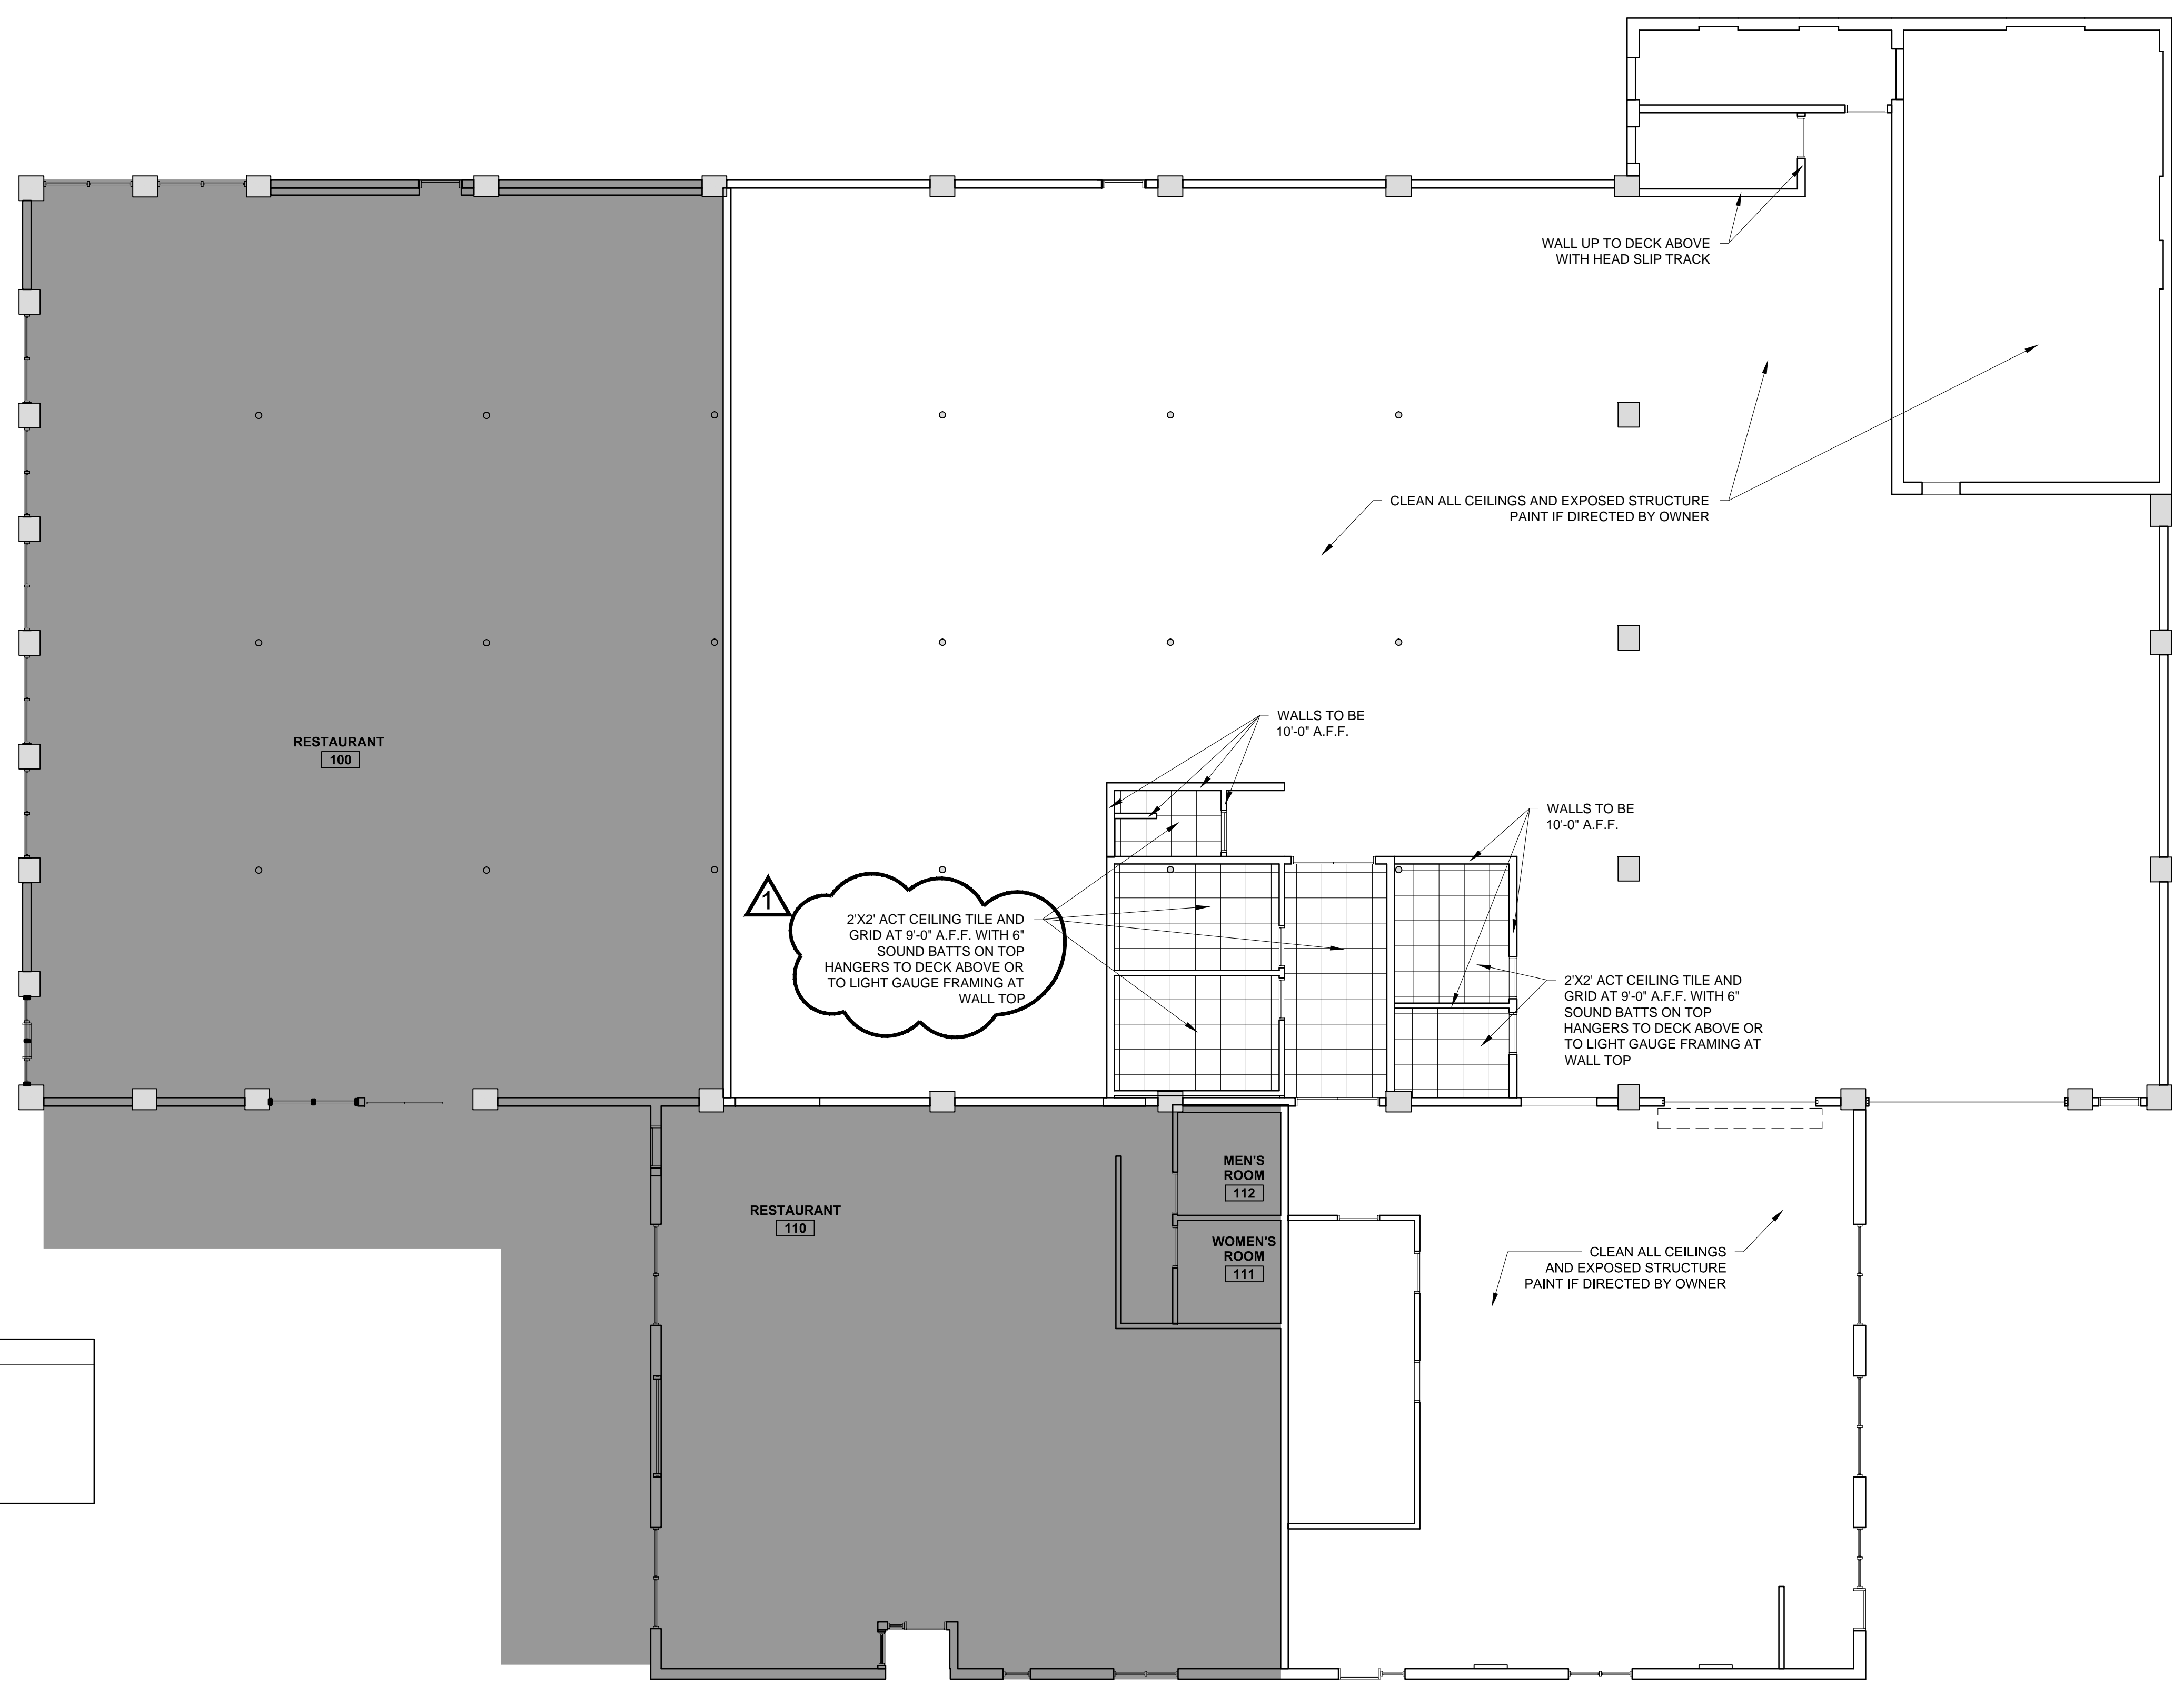

**RCP NOTES**  
1.) LIGHTS NOT SHOWN - TBD BY OWNER



1 REFLECTED CEILING PLAN  
1/8" = 1'-0"