



DOOR SCHEDULE

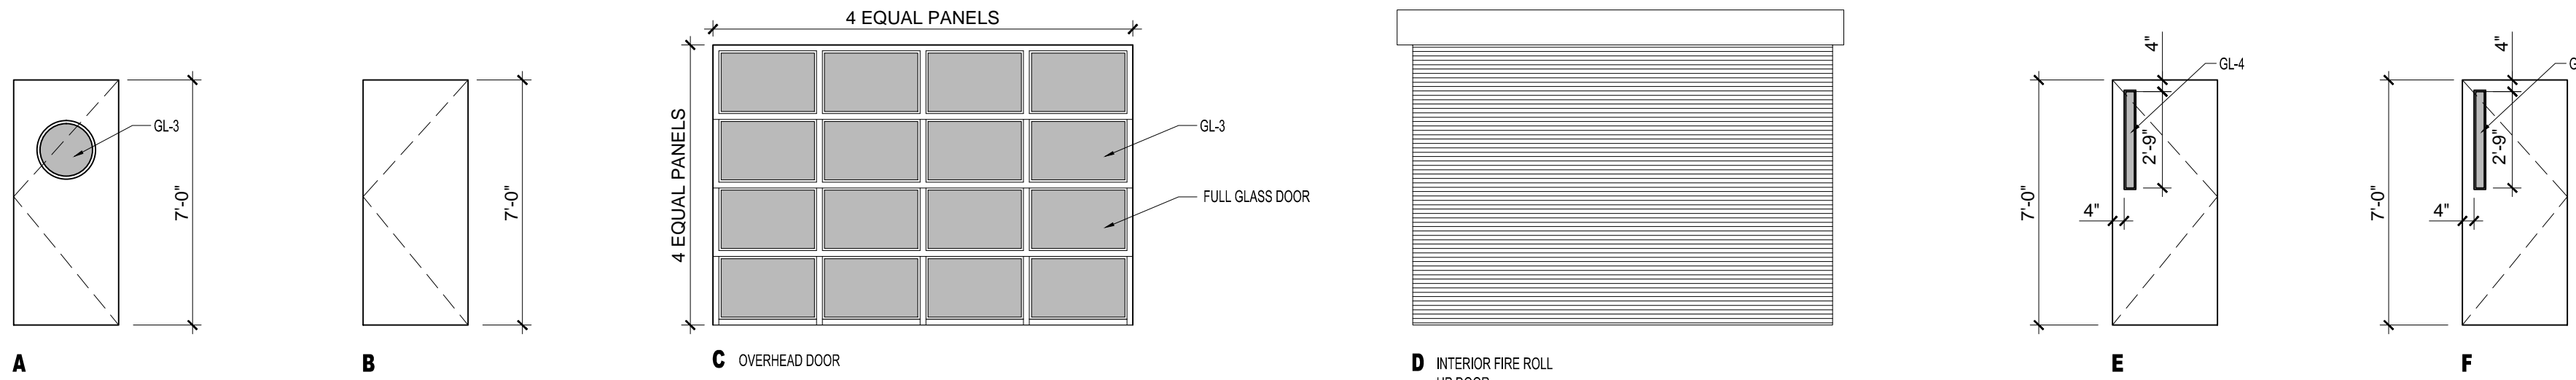

- DOOR NOTES:**
- 1.) ALL EXTERIOR GLAZING TO BE LOW-E ARGON FILLED INSULATED GLAZING UNITS
 - 2.) FRAME ALL OPENINGS WITH ELEVATIONS
 - 3.) SEAL EXTERIOR DOORS TO ROUGH OPENING WITH LOW EXPANDING FOAM INSULATION - SEE DETAILS
 - 4.) ALL DOOR HARDWARE TO BE 'LEVER' TYPE
 - 5.) ALL EXTERIOR DOORS TO BE WEATHERSTRIPPED

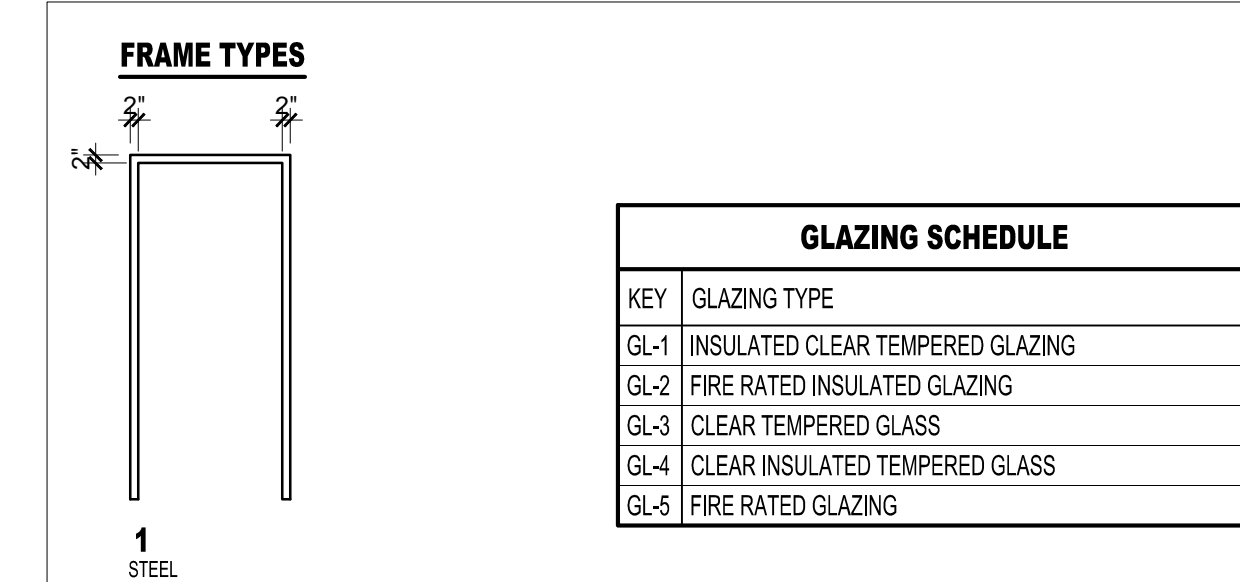

1 DOOR TYPES
1/4" = 1'-0"

DOOR SCHEDULE																
DOOR NO.	TYPE	SIZE			MATERIAL	FINISH	INSULATED	FRAME				CLOSER	FIRE RATING (MINUTES)	GENERAL		
		WIDTH	HEIGHT	THICKNESS				THRESHOLD	HEAD	JAMB	SILL				REMARKS	
121.1	C	12'-0"	8'-0"	1-3/4"	AL	PTD	-	-	-	AL	-	-	-	-	FULL GLASS OVERHEAD DOOR WITH CHAIN PULL, LOCK	
121.2	D	12'-0"	8'-0"	-	STL	PTD	-	-	STL	-	-	-	Y	60	FIRE RATED OVERHEAD ROLLING DOOR WITH AUTOMATIC CLOSER TIED TO FIRE ALARM SYSTEM WITH LASER EYE SAFTEY FEATURE, OVERHEAD DOOR MODEL 631, FUSEABLE LINK	
121.3	E	3'-0"	7'-0"	1-3/4"	STL	PTD	Y	1	STL	AL	-	-	-	Y	-	THERMALLY BROKEN STEEL DOOR WITH PANIC HARDWARE
124.1	F	6'-0"	7'-0"	1-3/4"	STL	PTD	Y	2	STL	AL	-	-	-	Y	60	-
125.1	B	3'-0"	7'-0"	1-3/4"	STL	PTD	Y	1	STL	AL	-	-	-	Y	60	PANIC HARDWARE
127.1	A	3'-0"	7'-0"	1-3/4"	WD	CLR	Y	1	STL	-	-	-	-	Y	-	-
128.1	A	3'-0"	7'-0"	1-3/4"	WD	CLR	Y	1	STL	-	-	-	-	Y	-	-
131.1	B	3'-0"	7'-0"	1-3/4"	STL	PTD	Y	1	STL	-	-	-	-	Y	-	-
132.1	A	3'-0"	7'-0"	1-3/4"	WD	CLR	Y	1	STL	-	-	-	-	-	-	-
133.1	A	3'-0"	7'-0"	1-3/4"	WD	CLR	Y	1	STL	-	-	-	-	-	-	-



© 2017 RYAN SENATORE ARCHITECTURE

MAINE CRAFT DISTILLING
123 WASHINGTON STREET
PORTLAND, MAINE



RYAN SENATORE ARCHITECTURE
565 CONGRESS STREET
PORTLAND, MAINE 04101
207-650-6414
senatorearchitecture.com

CONSULTANTS:

REVISIONS:
REVISION #1 -05 / 17 / 17

DATE: FEBRUARY 14, 2017

PROJECT No. 1666

DRAWN BY: RRT


CHECKED BY: RJS

SCALE: AS NOTED

SHEET TITLE:
DOOR AND WINDOW SCHEDULE

A7-0

WINDOW SCHEDULE

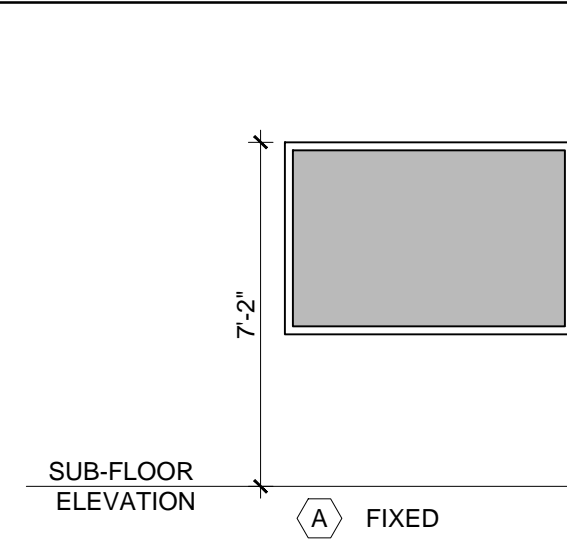

WINDOW SCHEDULE LEGEND

- T = TEMPERED GLASS
- FG = FIBERGLASS
- AL = ALUMINUM
- DH = DOUBLE HUNG
- AW = AWNING
- LV = LOUVER
- F = FIXED
- GL = GLIDER

1 WINDOW TYPES
1/4" = 1'-0"

WINDOW SCHEDULE										
KEY	ACTION	ROUGH OPENING (WH) VIF	RO. HEAD HEIGHT FROM SUB-FLOOR	DETAILS			MATERIAL	FINISH	FOR TEMPERED GLASS LOCATIONS SEE WINDOW ELEVATION TYPES FOR MASONRY OPENING DIMENSIONS COORDINATE COURSING WITH EXTERIOR ELEVATION SHEETS AND PLAN AND SECTION DETAIL SHEETS	
				HEAD	JAMB	SILL			REMARKS	REMARKS
A	F	6'-1" X 4'-1"	-	-	-	-	STL	PTD	45	MINUTE FIRE RATED WINDOW AND FRAME, CLEAR FIRE RATED, TEMPERED GLASS

- WINDOW NOTES:**
- 1.) ALL GLAZING LOCATED WITHIN 18" OF FINISHED FLOOR TO BE TEMPERED GLASS