



GENERAL NOTES

1. EXISTING FIRE SPRINKLER SYSTEM TO REMAIN AND BE KEPT IN SERVICE DURING CONSTRUCTION.
2. EXISTING FIRE ALARM SYSTEM TO REMAIN AND BE KEPT IN SERVICE DURING CONSTRUCTION.

ARCHITECT:
KEVIN MORIN, AIA
 46 LISBON STREET #3
 LEWISTON, ME 04240
 917-287-3486
 kevin@pomoandco.com

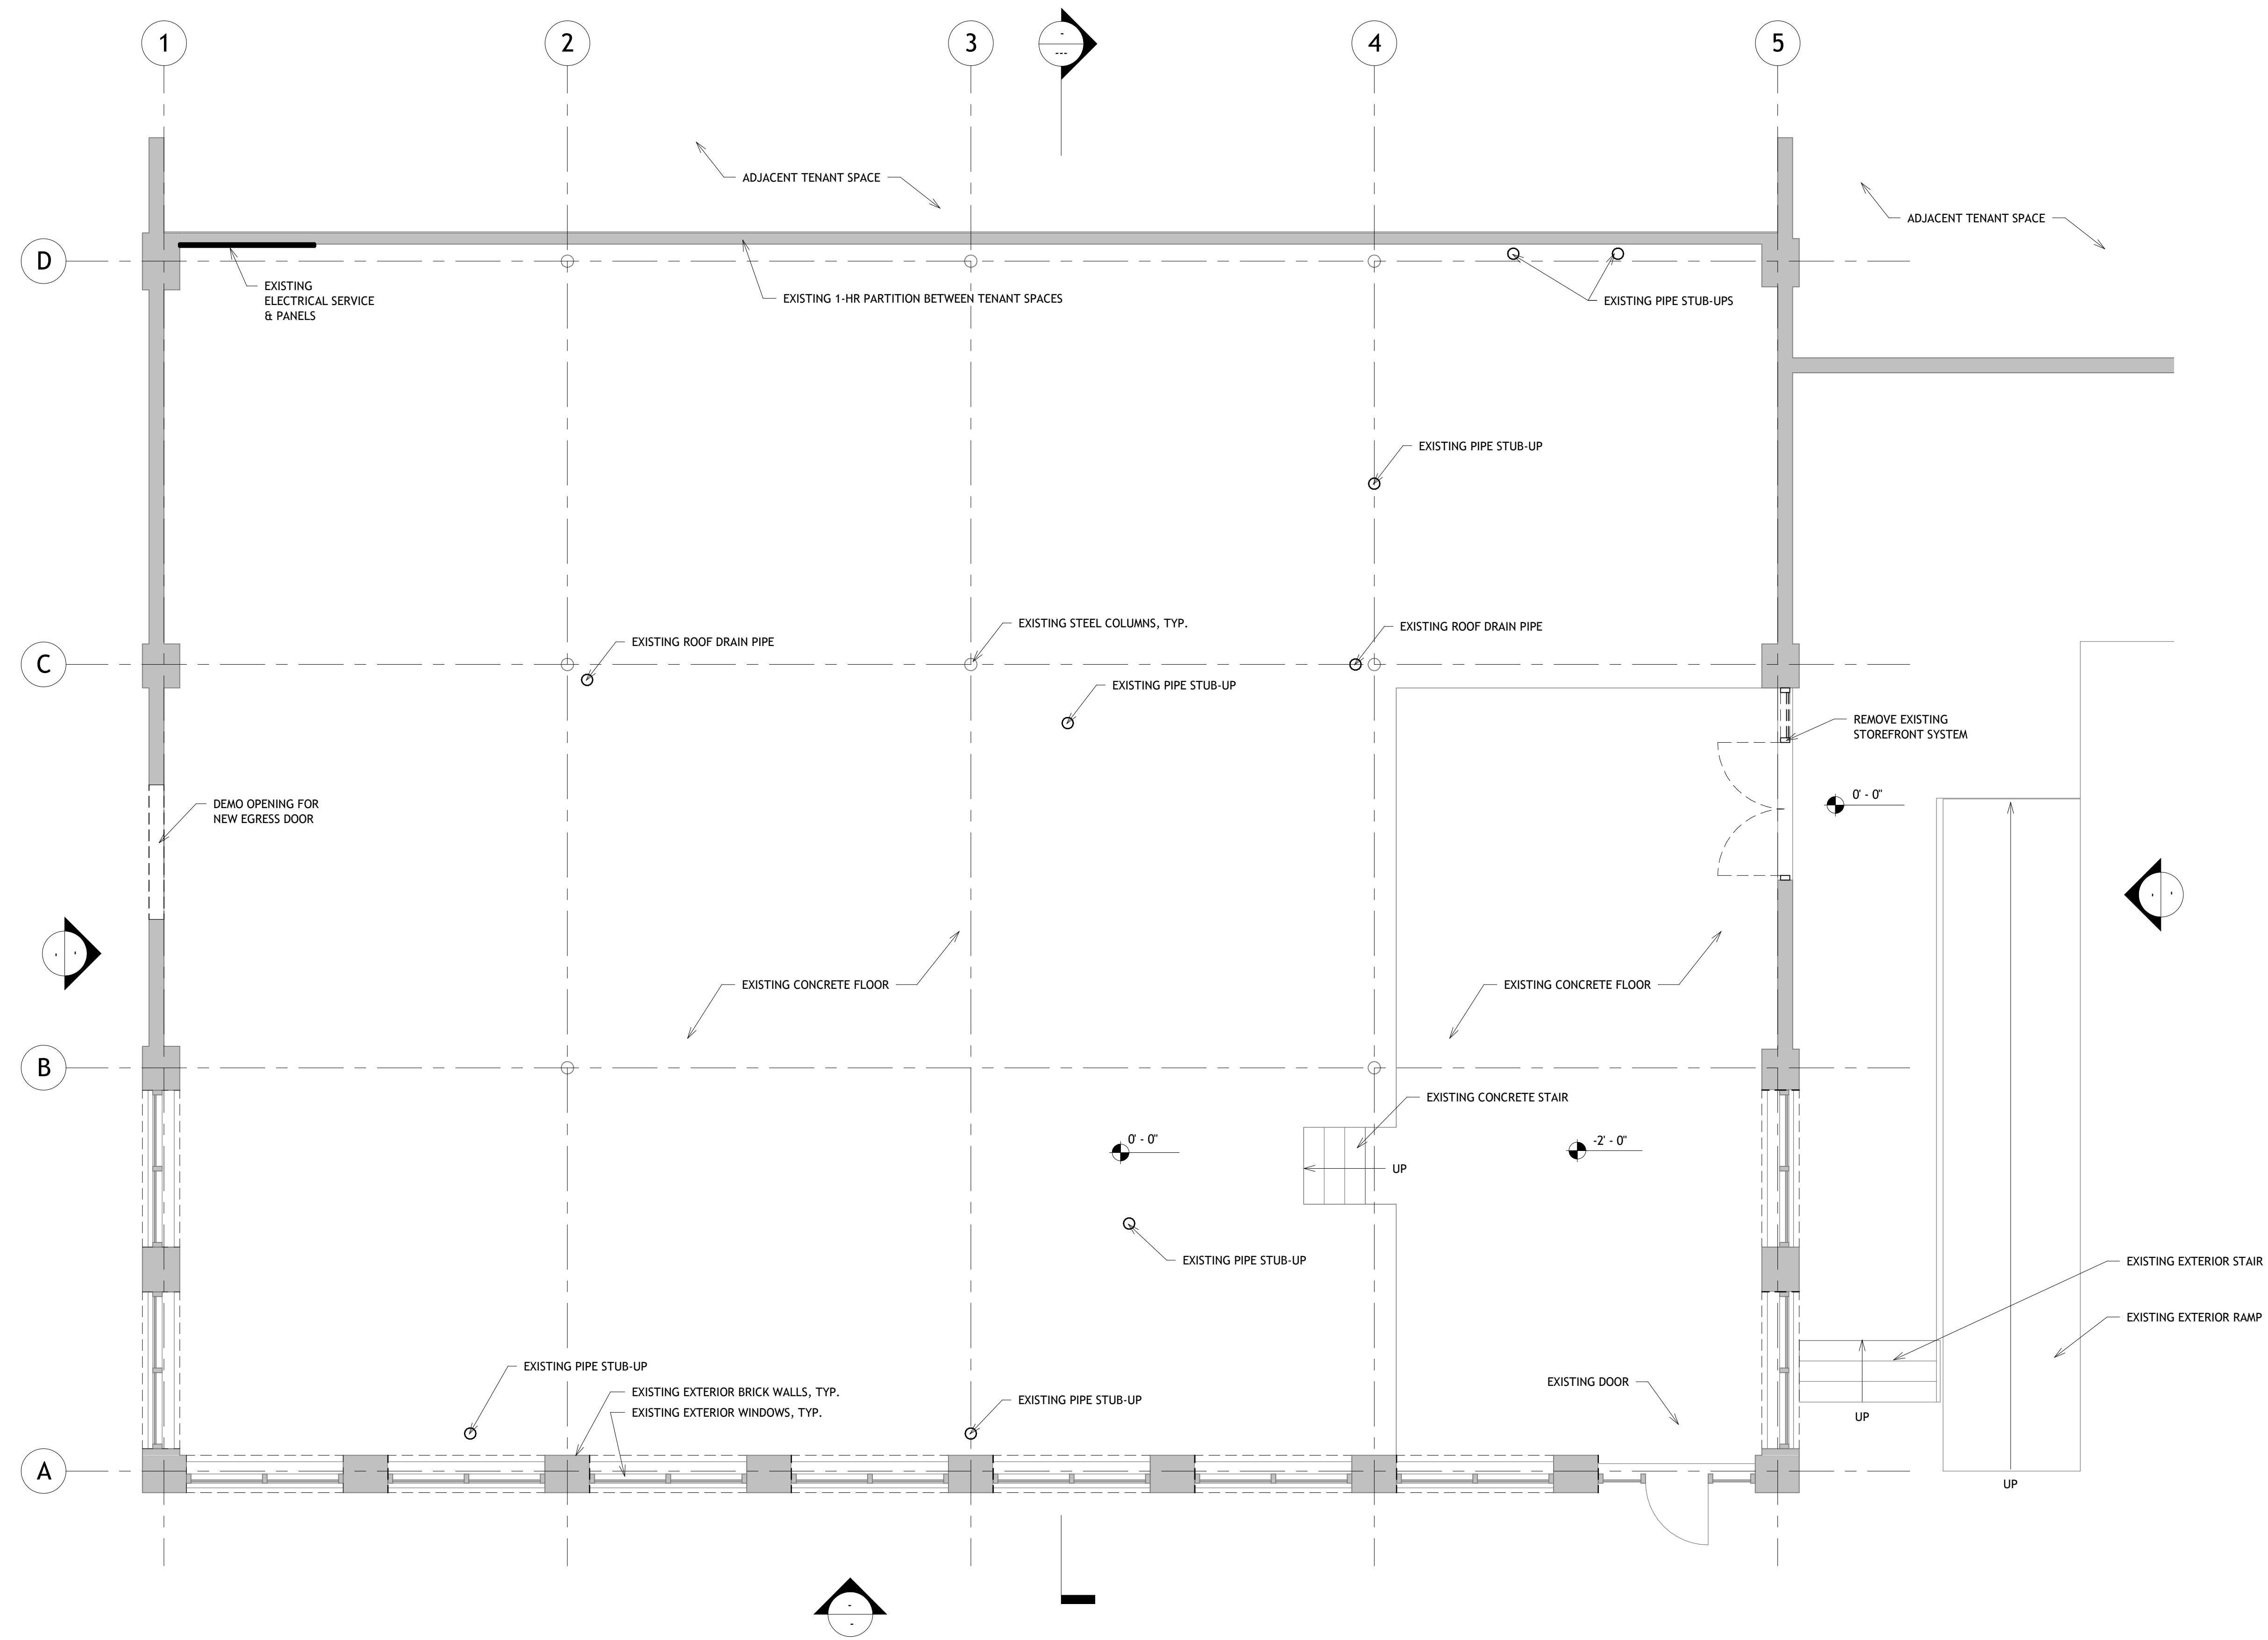

1 EXISTING FLOOR PLAN
 SCALE: 1/4" = 1'-0"

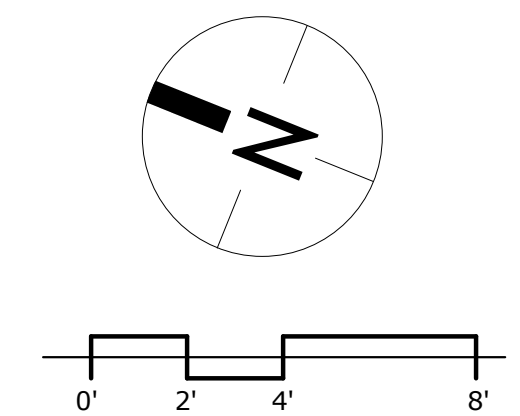

FORAGE MARKET

123 WASHINGTON AVE
 PORTLAND, MAINE 04101

SEAL:



Project Status

ISSUE DATE:

REVISION	DESCRIPTION	DATE

EXISTING FLOOR PLAN

A-100

11/30/2017 10:14:36 PM