

PARTITION TYPES:

- 1 5/8" MOISTURE RESISTANT GWB
 3 5/8" METAL STUDS
 5/8" MOISTURE RESISTANT GWB
- 1A SAME AS TYPE 1 W/ SOUND BATT INSULATION IN STUD CAVITY
- 2 5/8" MOISTURE RESISTANT GWB
 8" METAL STUDS W/ 8" SOUND BATT INSULATION
 5/8" MOISTURE RESISTANT GWB

FLOOR PLAN NOTES:

- 1) UNLESS OTHERWISE NOTED, ALL EQUIPMENT TO BE PROVIDED BY OWNER. REFER TO SCHEDULE.
- 2) REFER TO EQUIPMENT SCHEDULE FOR CONTRACTOR INSTALLATION NOTES FOR EACH ITEM.
- 3) ALL EXHAUST SHALL BE THROUGH ROOF PENETRATIONS.
- 4) POWER FOR KITCHEN EQUIPMENT SHALL BE INSTALLED PER EQUIPMENT SCHEDULE. SPECIFIC OUTLET LOCATIONS HAVE BEEN SHOWN ON THE FLOOR PLAN. CONVENIENCE OUTLETS TO BE INSTALLED AS REQUIRED BY ALL APPLICABLE

EQUIPMENT SCHEDULE


TAG	BY OWNER	DESCRIPTION	ELECTRIC	PLUMBING / GAS	EXHAUST / ROOF EQUIP.
1	YES	ICE MACHINE	YES, REF. CUT SHEETS	YES, REF. CUT SHEETS	
2	YES	BREAD SLICER	YES		
3	YES	MAPLE TOP TABLE			
4	YES	SPIRAL MIXER	YES, REF. CUT SHEETS		
5	YES	WORKTOP REFRIGERATOR	YES		
6	YES	BAGEL PROOFER			
7	YES	PASTRY OVEN	YES, REF. CUT SHEETS	YES, REF. CUT SHEETS	YES, REF. CUT SHEETS
8	YES	WOOD FIRED BAGEL OVEN	YES		YES
9	YES	BAGEL KETTLE & HOOD		YES, REF. CUT SHEETS	YES, REF. CUT SHEETS
10	YES	BAGEL WASH TABLE			
11	YES	WOOD TOP BAKERY TABLE			
12	YES	DUNNAGE RACK			
13	YES	UNDERCOUNTER REFRIGERATOR	YES		
14	YES	COUNTERTOP GRIDDLE - 36"	YES, REF. CUT SHEETS	YES, REF. CUT SHEETS	
15	YES	GRIDDLE BASE - 36"	YES, REF. CUT SHEETS		
16	YES	DISHWASHER	YES, REF. CUT SHEETS	YES, REF. CUT SHEETS	YES, REF. CUT SHEETS
17	YES	DISH TABLE - 48"			
18	YES	STAINLESS COUNTER - 24"x72"			
19	YES	STAINLESS COUNTER - 24"x180"			
20	YES	SANDWICH PREP	YES, REF. CUT SHEETS		
21	YES	WALL MOUNTED SHELVING - 18'D			
22	YES	TOASTER	YES		
23	YES	STAINLESS COUNTER - 24"x66"			
24	YES	STAINLESS COUNTER - 24"x36"			
25	YES	ESPRESSO MACHINE	YES	YES	
26	YES	COFFEE BREWER	YES	YES	
27	YES	UNDERCOUNTER ICE MAKER	YES	YES	
28	YES	6 BURNER RANGE		YES, REF. CUT SHEETS	
29	YES	SOUP KETTLE	YES		
30	YES	8' COMMERCIAL HOOD W/ MAKEUP AIR	YES		YES
31	YES	10x11' WALK-IN REFRIGERATOR	YES, REF. CUT SHEETS	YES, REF. CUT SHEETS	YES, REF. CUT SHEETS
32	YES	10x11' WALK-IN FREEZER	YES, REF. CUT SHEETS	YES, REF. CUT SHEETS	YES, REF. CUT SHEETS
33	YES	SPRAY SINK - 59"	YES		
34	YES	3-BAY DISH SINK - 74"		YES	
35	YES	STAINLESS COUNTER - 24"x36"			
36	YES	STAINLESS COUNTER - 24"x36"			

PLUMBING FIXTURES

TAG	BY OWNER	DESCRIPTION
A	YES	MOP SINK
B	YES	HAND WASH SINK
B	YES	HAND WASH SINK
B	YES	HAND WASH SINK
C	YES	SPRAYER FAUCET
D	NO	WATER HEATER
E	YES	PRODUCE SINK
E	YES	PRODUCE SINK
G	YES	HAND WASH SINK W/ EMERGENCY EYE WASH
H	YES	FLOOR SINK
H	YES	FLOOR SINK

DOOR SCHEDULE

TAG	WIDTH	HEIGHT	COMMENTS
1	6'-0"	7'-0"	STORAGE HARDWARE SET
2	2'-6"	7'-0"	STORAGE HARDWARE SET
3	3'-0"	7'-0"	PASSAGE HARDWARE SET, NO LATCHING
4	6'-0"	7'-0"	PANIC HARDWARE
5	2'-9 1/2"	6'-10 3/4"	EXISTING DOOR & HARDWARE
6	3'-0"	7'-0"	ALUMINUM STOREFRONT DOOR. PANIC HARDWARE.

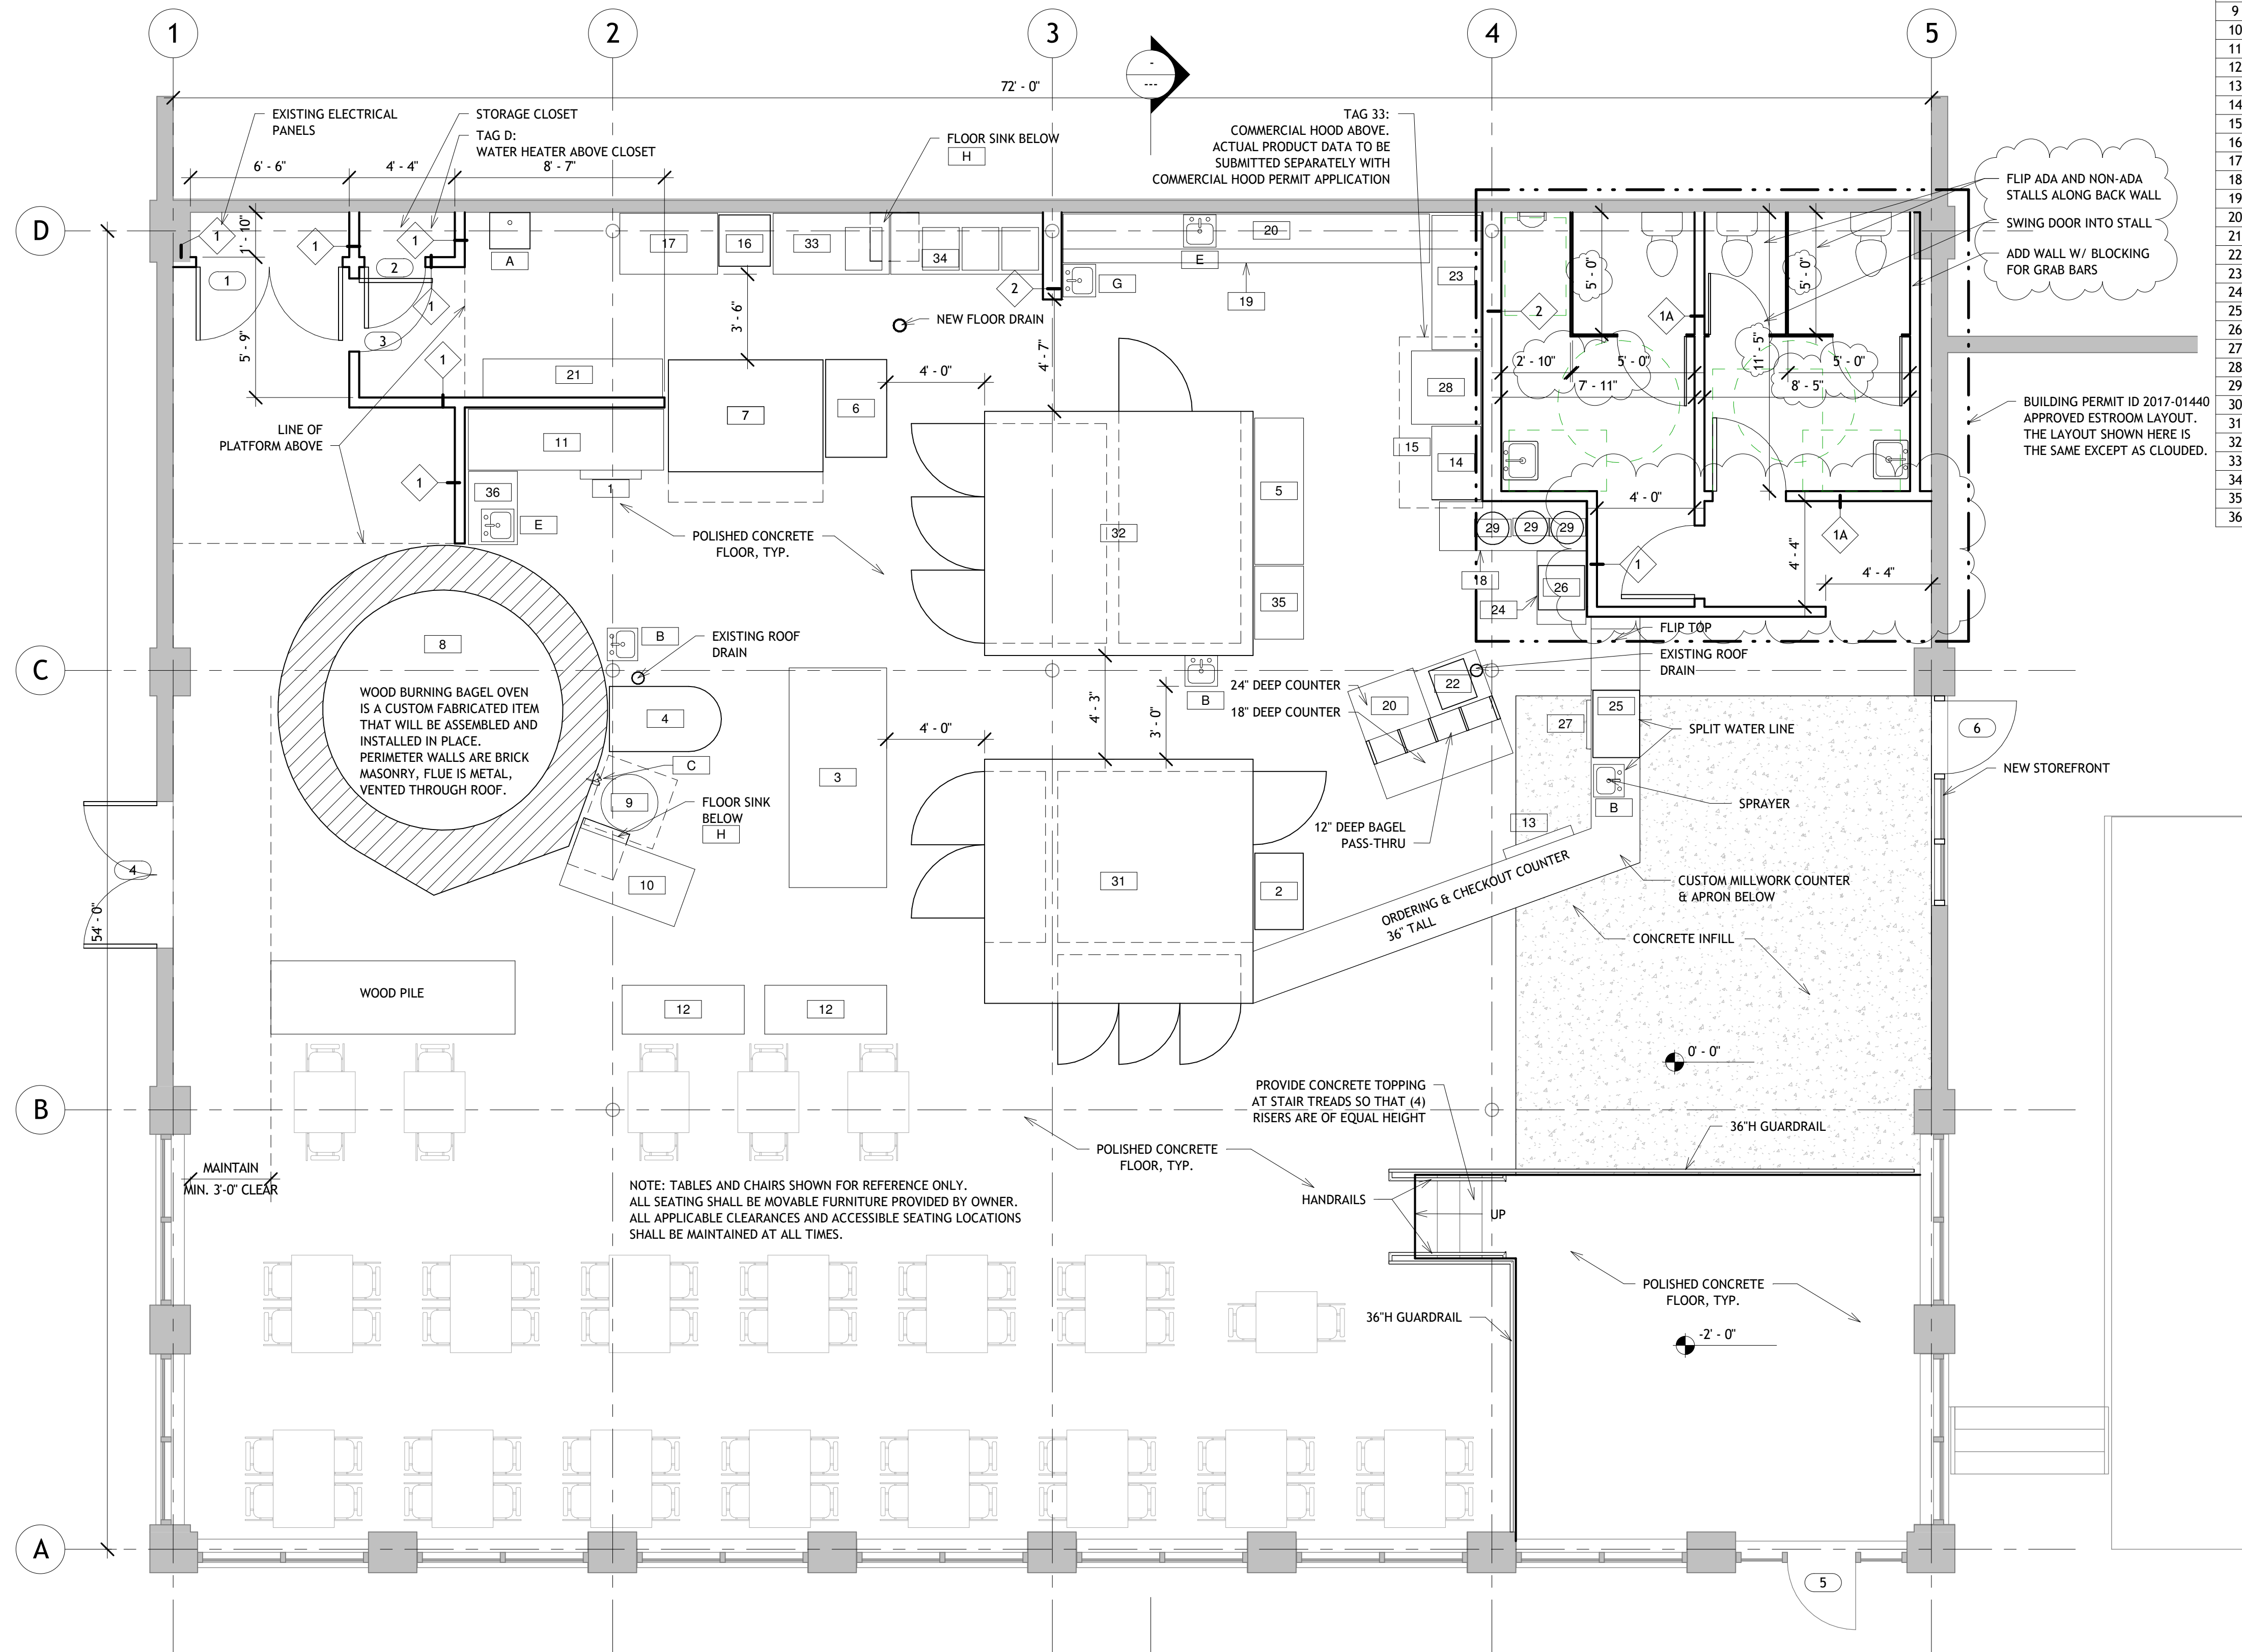

1 PROPOSED FLOOR PLAN
 SCALE: 1/4" = 1'-0"

FORAGE MARKET

123 WASHINGTON AVE
 PORTLAND, MAINE 04101

SEAL:



Project Status
 ISSUE DATE:

REVISION	DESCRIPTION	DATE

PROPOSED FLOOR PLAN

A-102