

© 2016 RYAN SENATORE ARCHITECTURE

93 WASHINGTON AVE.
PORTLAND, MAINE



RYAN SENATORE ARCHITECTURE
565 CONGRESS STREET
PORTLAND, MAINE 04101
207-650-6414
senatorearchitecture.com

CONSULTANTS:

REVISIONS:

DATE: JULY 26, 2016

PROJECT No. 1626

DRAWN BY: RJS / RRT

CHECKED BY: RJS


SCALE: AS NOTED

SHEET TITLE:
REFLECTED CEILING PLAN

A1-1

REFLECTED CEILING PLAN AND LIGHTING LEGEND		
SYMBOL	TAG	DESCRIPTION
⊕	A	4" RECESSED CAN
⊕	B	4" RECESSED CAN - WET LOCATION
—	C	SURFACE MOUNTED ON WALL ABOVE DOOR
—	D	WALL SCONCE
—	E	EXTERIOR CUT-OFF WALL MOUNTED DN LIGHT

- NOTES:
- 1.) ALL LIGHTING TO BE LED LAMPS
 - 2.) ALL LIGHTING TO BE ON DIMMERS
 - 3.) ALL RECESSED LIGHTS TO BE IN FIRE RATED BOXES

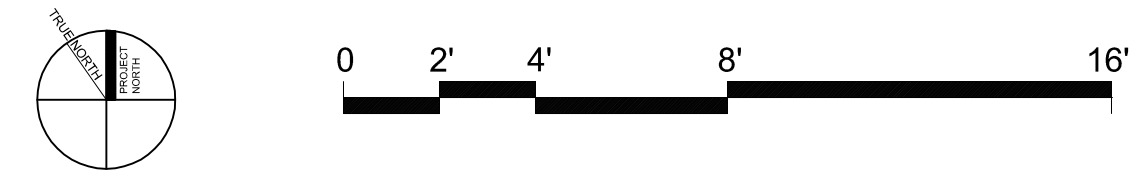

1 REFLECTED CEILING PLAN
1/4" = 1'-0"