

© 2016 RYAN SENATORE ARCHITECTURE

93 WASHINGTON AVE.  
PORTLAND, MAINE



RYAN SENATORE ARCHITECTURE  
565 CONGRESS STREET  
PORTLAND, MAINE 04101  
207-650-6414  
senatorearchitecture.com

CONSULTANTS:

REVISIONS:

DATE: SEPTEMBER 29, 2016

PROJECT No. 1626

DRAWN BY: RJS / RRT

CHECKED BY: RJS

SCALE: AS NOTED



SHEET TITLE:

REFLECTED CEILING PLANS



A1-2

REFLECTED CEILING PLAN AND LIGHTING LEGEND		
SYMBOL	TAG	DESCRIPTION
⊕	A	4" RECESSED CAN
⊕	B	4" RECESSED CAN - WET LOCATION
▭	C	SURFACE MOUNTED ON WALL ABOVE DOOR
▭	D	WALL SCONCE
▭	E	EXTERIOR CUT-OFF WALL MOUNTED DN.LIGHT
▭	F	EXTERIOR WALL SCONCE

- NOTES:
- 1.) ALL LIGHTING TO BE LED LAMPS
  - 2.) ALL LIGHTING TO BE ON DIMMERS
  - 3.) ALL RECESSED LIGHTS TO BE IN FIRE RATED BOXES

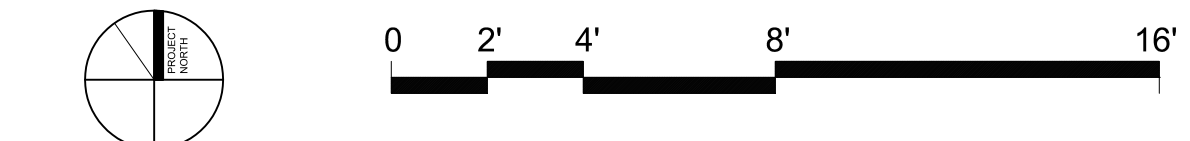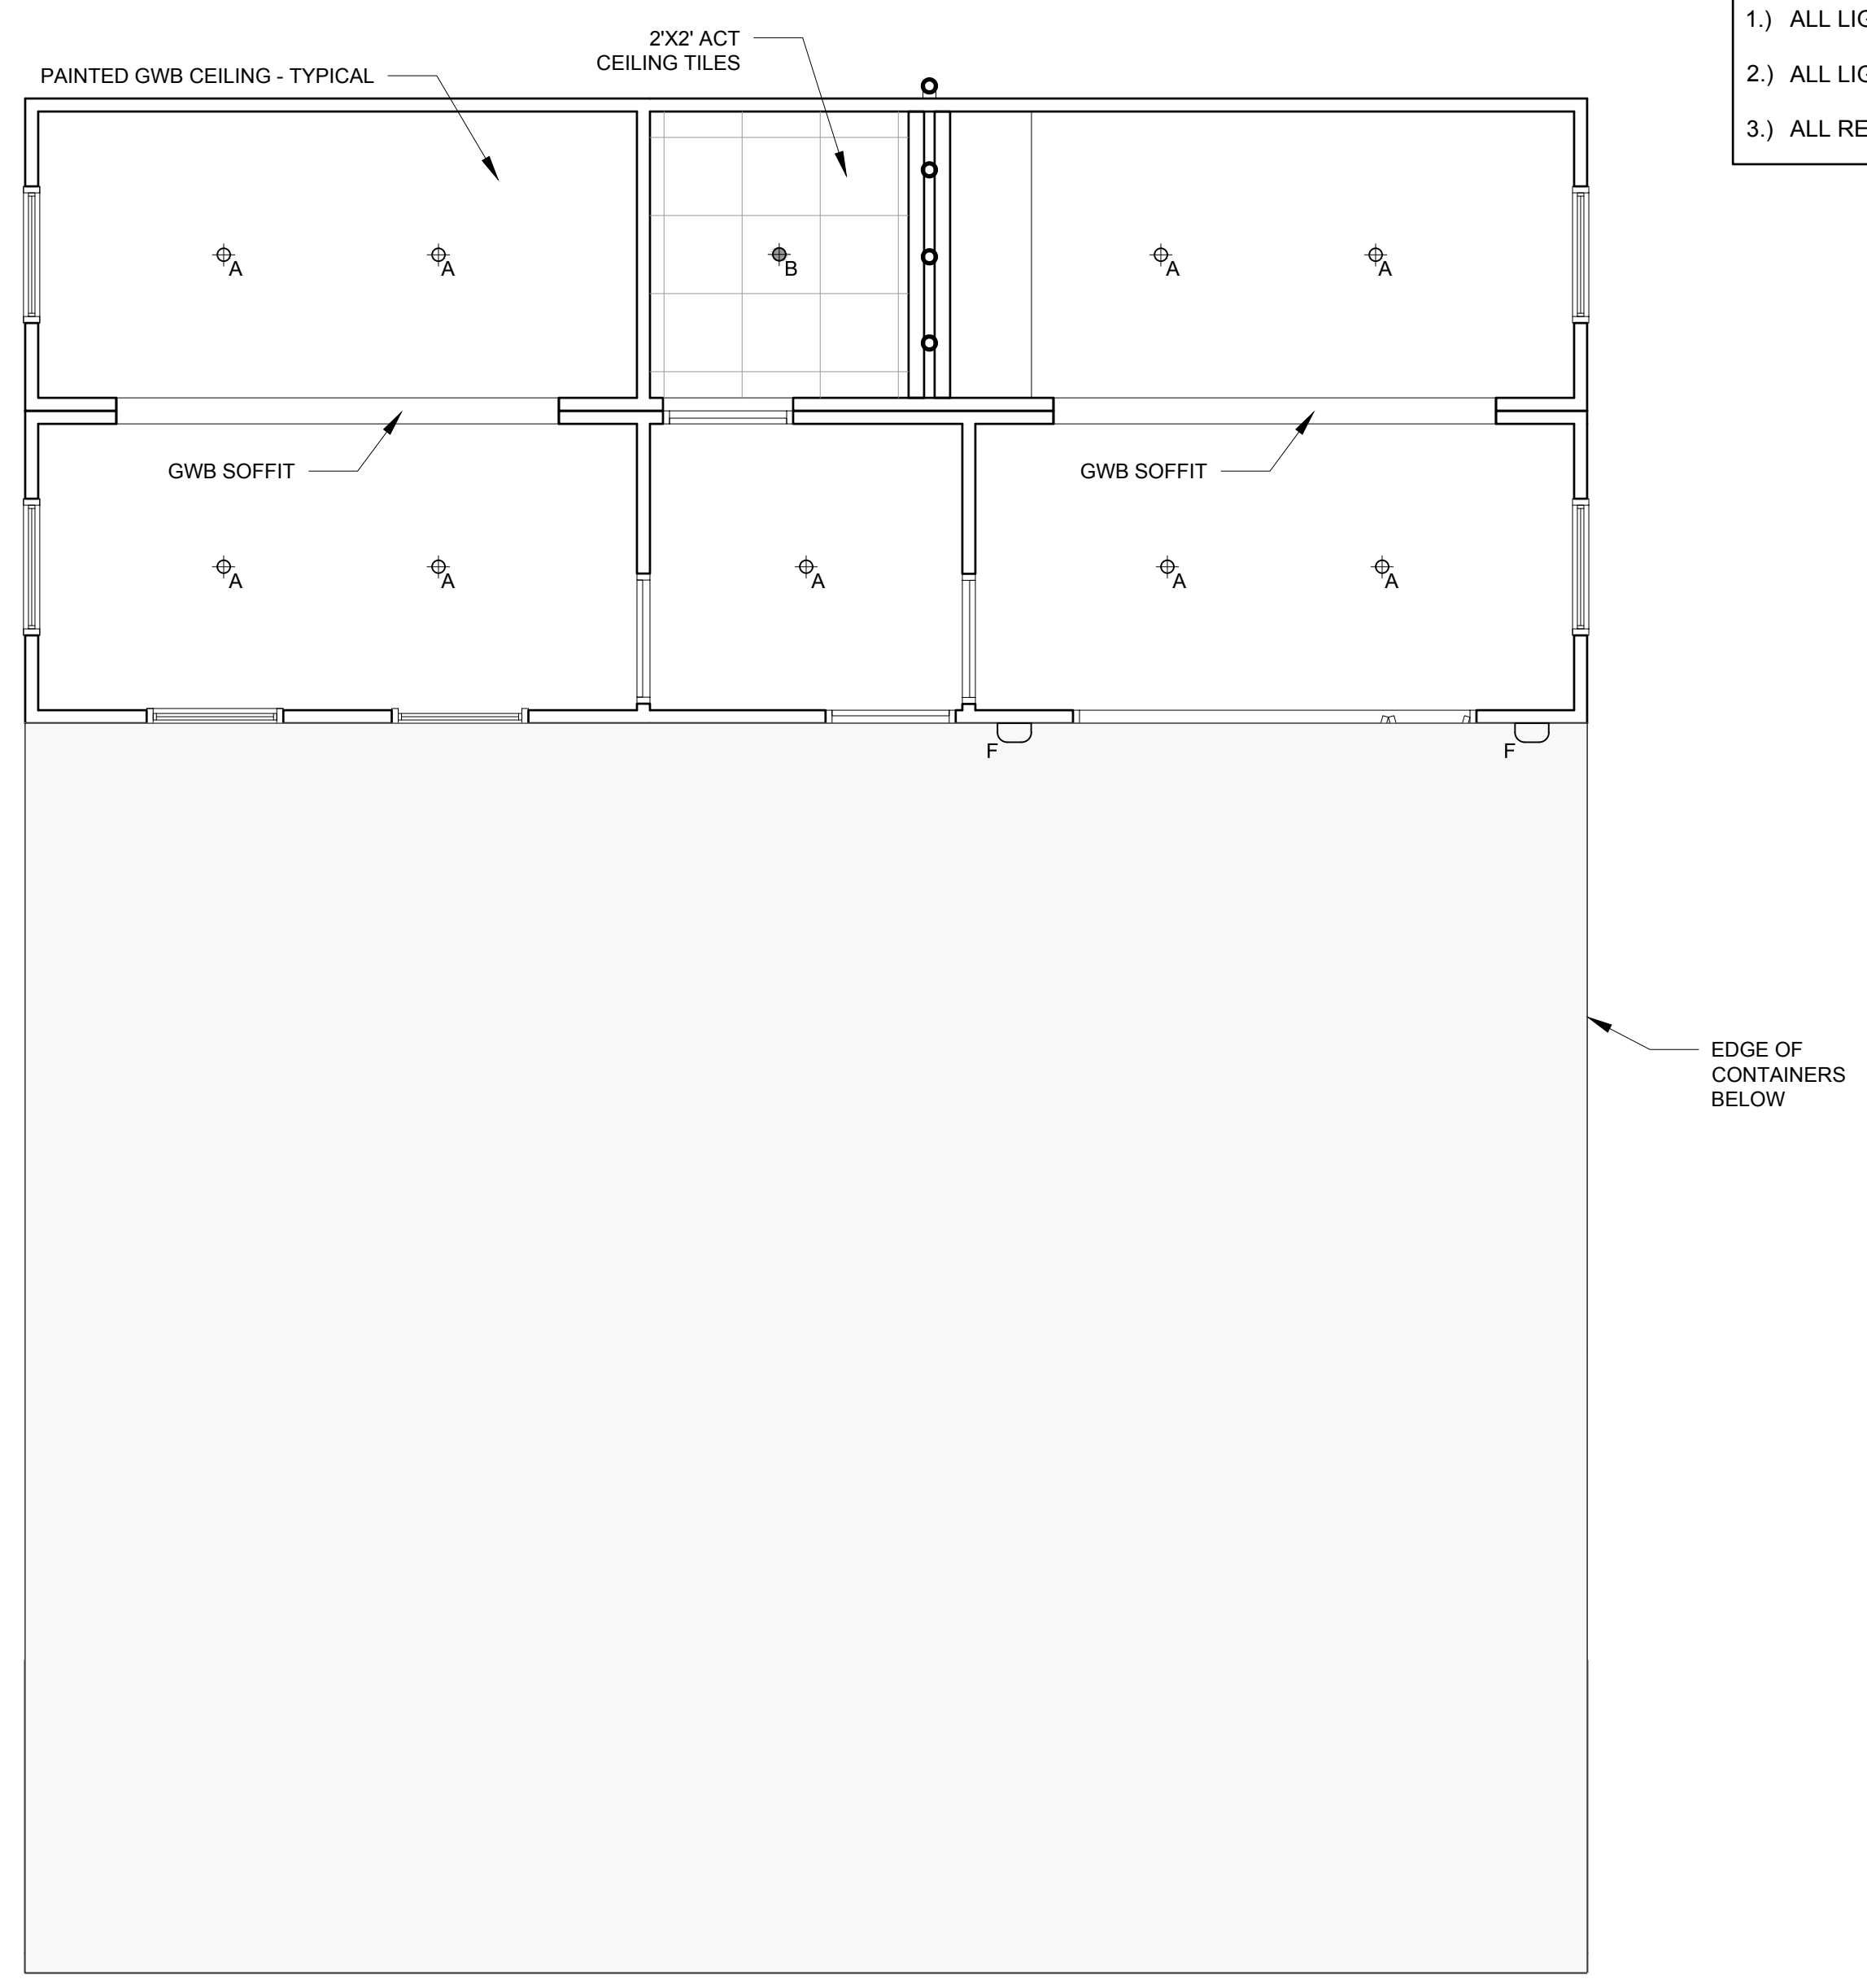

2 SECOND FLOOR REFLECTED CEILING PLAN  
1/4" = 1'-0"

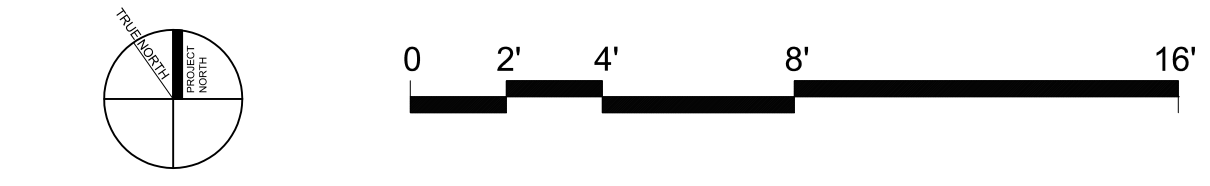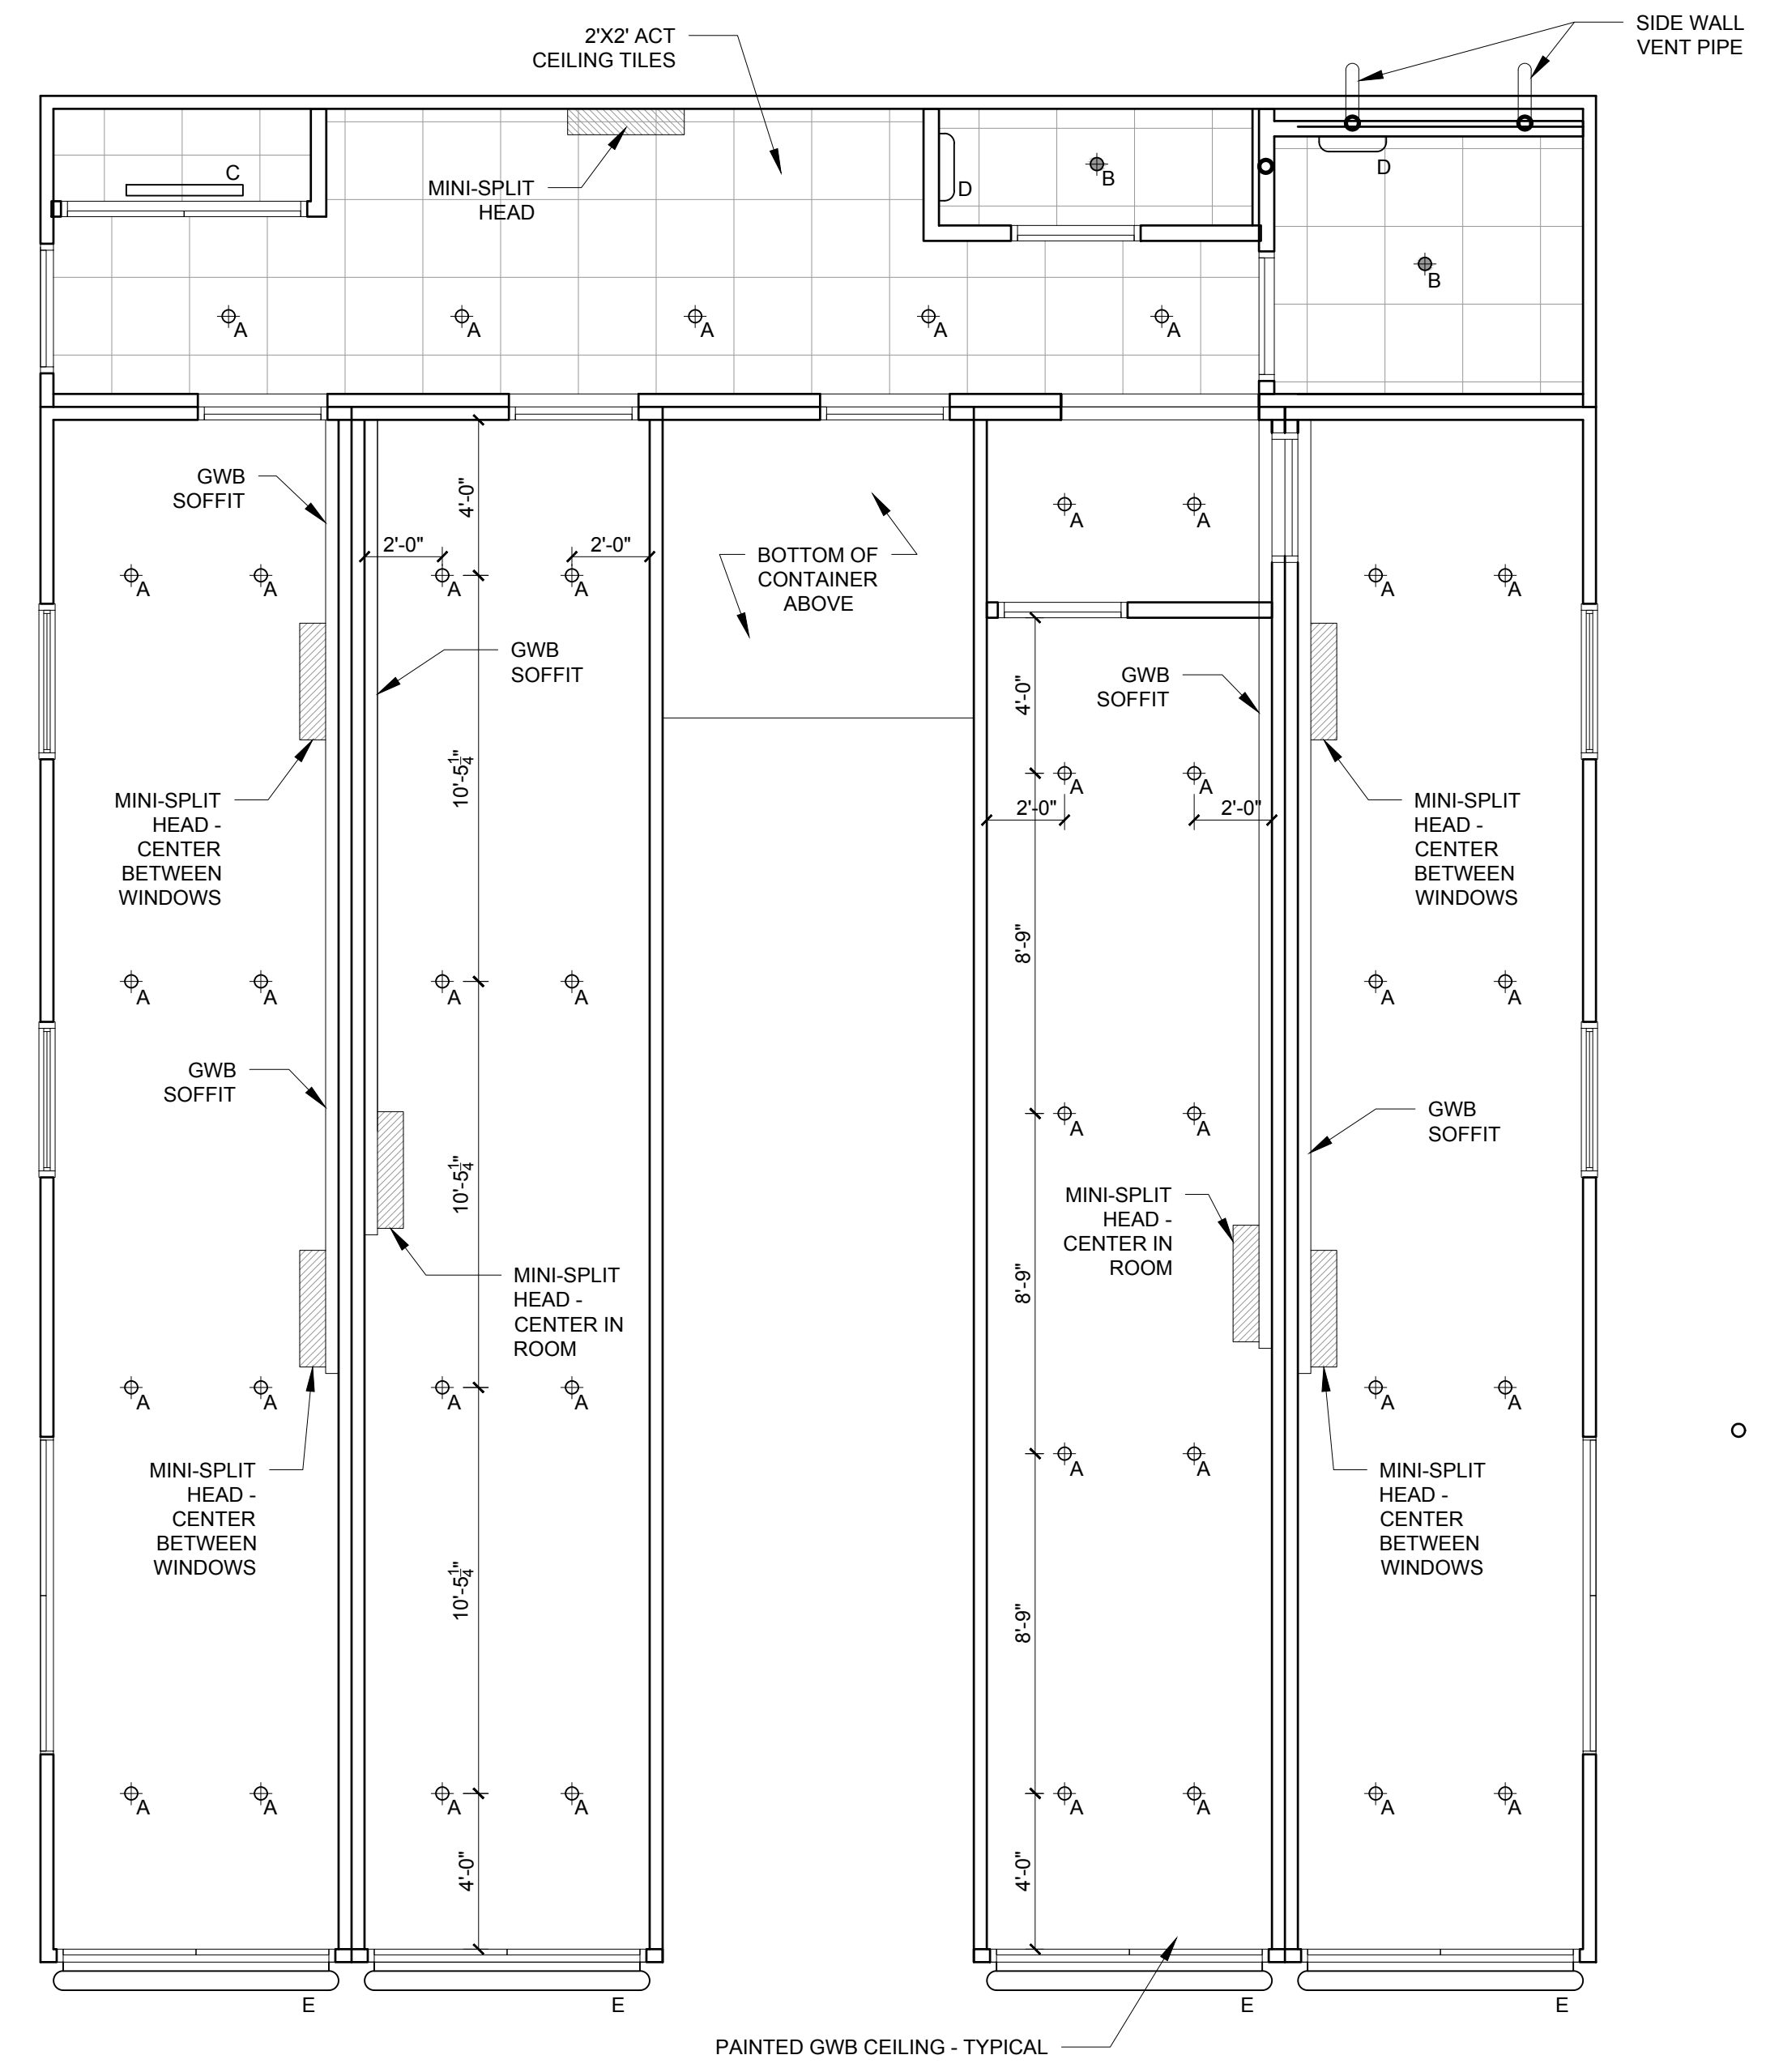

1 FIRST FLOOR REFLECTED CEILING PLAN  
1/4" = 1'-0"