



© 2017 RYAN SENATORE ARCHITECTURE

**RESIDENCES**  
155 SHERIDAN STREET  
PORTLAND, MAINE



**RYAN SENATORE ARCHITECTURE**  
565 CONGRESS STREET  
PORTLAND, MAINE 04101  
207-650-6414  
senatorearchitecture.com

**CONSULTANTS:**  
STRUCTURAL: Structural Integrity  
77 Oak Street  
Portland, ME 04101  
207-774-4814

**REVISIONS:**

DATE: JANUARY 16, 2018

PROJECT No. 1604

DRAWN BY: RRT, RJS

CHECKED BY: RJS

SCALE: AS NOTED

SHEET TITLE:  
**UNIT 204-205 REFLECTED CEILING PLANS**


**A1-31**

**REFLECTED CEILING PLAN NOTES**

- 1.) G.C. TO COORDINATE LOCATIONS OF PLUMBING CLEAN OUTS WITH ACCESS PANELS AS SHOWN ON REFLECTED CEILING PLANS
- 2.) G.C. TO PROVIDE ACCESS PANELS AS REQUIRED FOR ALL ELEMENTS (SPRINKLER, VALVES, ETC) NOT SHOWN ON THIS REFLECTED CEILING PLAN
- 3.) G.C. TO PROVIDE METAL FRAMING AND BLOCKING REQUIRED FOR ALL ACCESS PANELS AND CONTROL JOINTS
- 4.) ALL ACCESS PANELS TO BE FIRE RATED TO MATCH THE CEILING THEY ARE INSTALLED WITHIN
- 5.) FOR LIGHTING PLAN, SEE ELECTRICAL DRAWINGS

**LIGHTING LEGEND**

SYMBOL	TAG	DESCRIPTION
●	A	SURFACE MOUNT - TBD
○	B	SURFACE MOUNTED - TBD
○	C	SURFACE MOUNT - IN CLOSETS
□	D	SURFACE MOUNTED ON WALL ABOVE DOOR
□	E	WALL SCONCE IN BATHROOM OVER VANITY
○	F	SURFACE MOUNT - WET LOCATION
○	G	SURFACE MOUNT - IN CORRIDORS / FITNESS
○	H	SURFACE MOUNT - CENTER IN BEDROOMS
○	J	SURFACE MOUNT - WET LOCATION
○	K	EXTERIOR CUT OFF DOWN LIGHT OVER DOOR
○	L	SURFACE MOUNT - IN LOBBY
○	M	INTERIOR SCONCE LIGHTING
□	N	1'X4' FLORESCENT LIGHT
○	P	PENDANT OVER ISLAND
○	Q	LED UTILITY LIGHTING IN STAIRWELLS
□	R	LED PARKING GARAGE LIGHTING
△	S	EXTERIOR SCONCE DOWN LIGHTING
○	T	UNDER COUNTER LIGHTING
□		CEILING GRILL

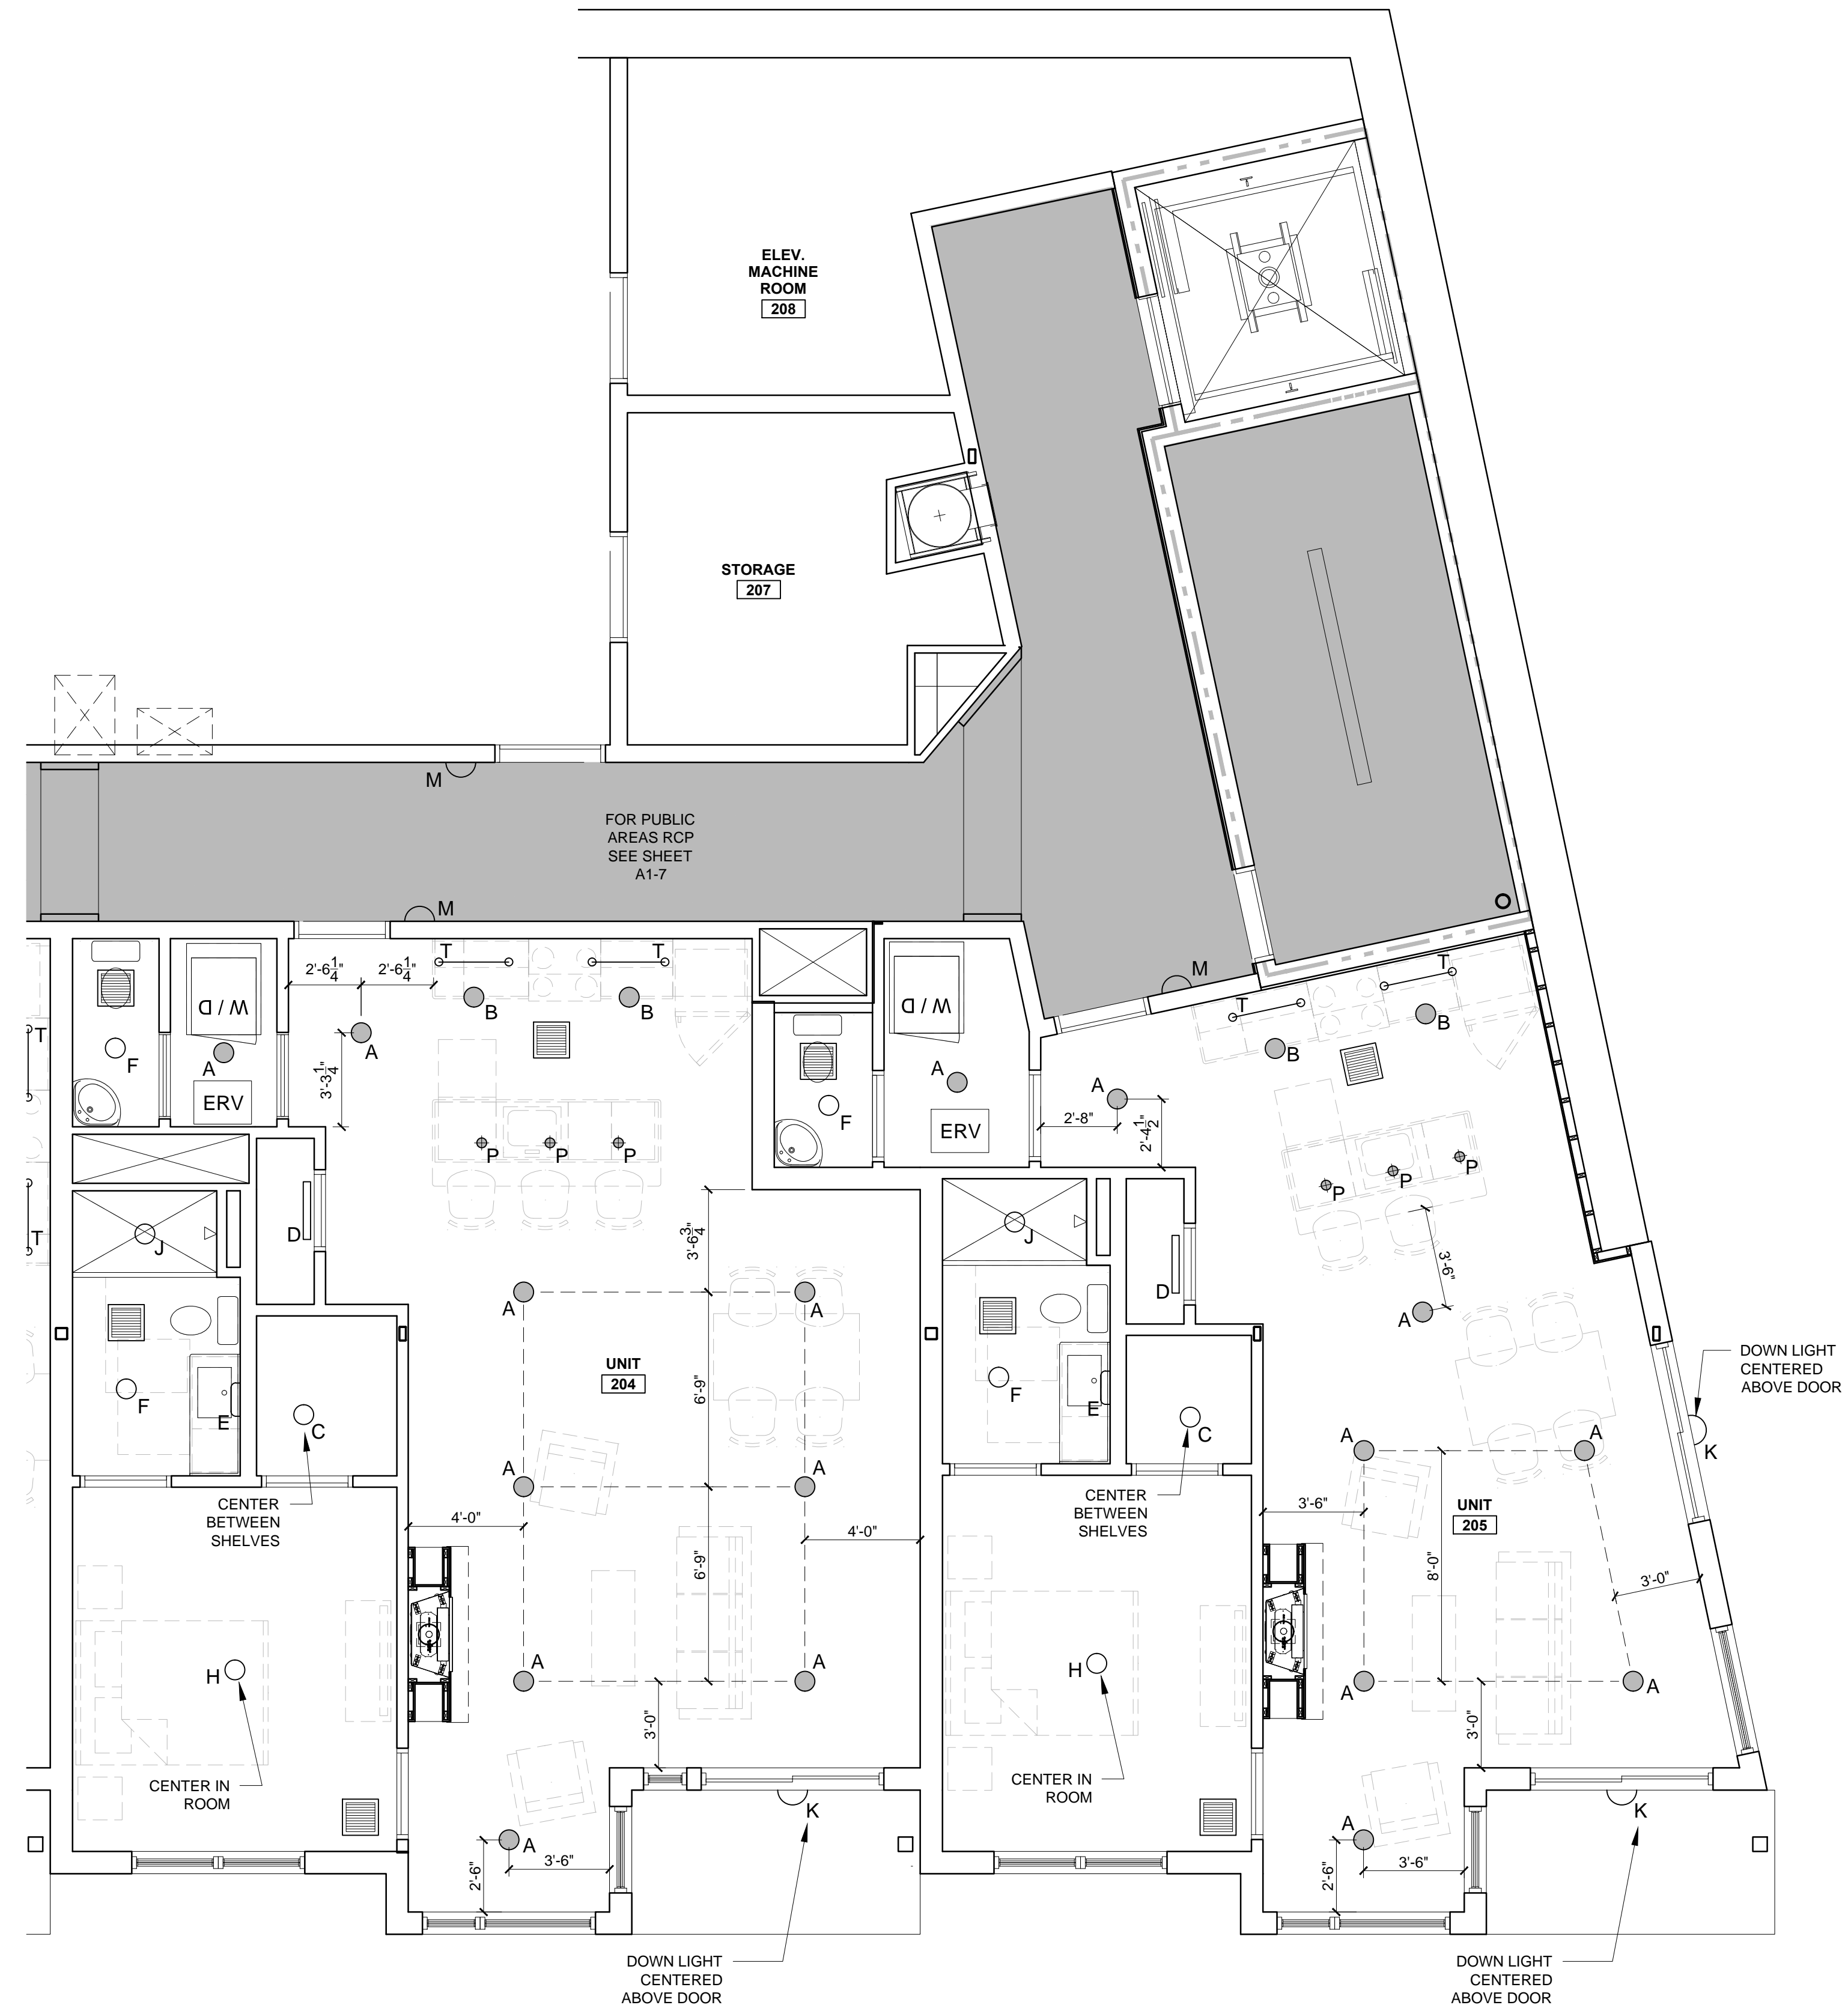

**1 UNIT 204-205 REFLECTED CEILING PLAN**  
1/4" = 1'-0"