



© 2017 RYAN SENATORE ARCHITECTURE

RESIDENCES
155 SHERIDAN STREET
PORTLAND, MAINE



RYAN SENATORE
ARCHITECTURE
565 CONGRESS STREET
PORTLAND, MAINE 04101
207-650-6414
senatorearchitecture.com

CONSULTANTS:
STRUCTURAL:
Structural Integrity
77 Oak Street
Portland, ME 04101
207-774-4814

REVISIONS:

DATE: JANUARY 16, 2018

PROJECT No. 1604


DRAWN BY: RRT, RJS

CHECKED BY: RJS

SCALE: AS NOTED

SHEET TITLE:
UNIT 401-406
REFLECTED
CEILING PLAN

A1-34

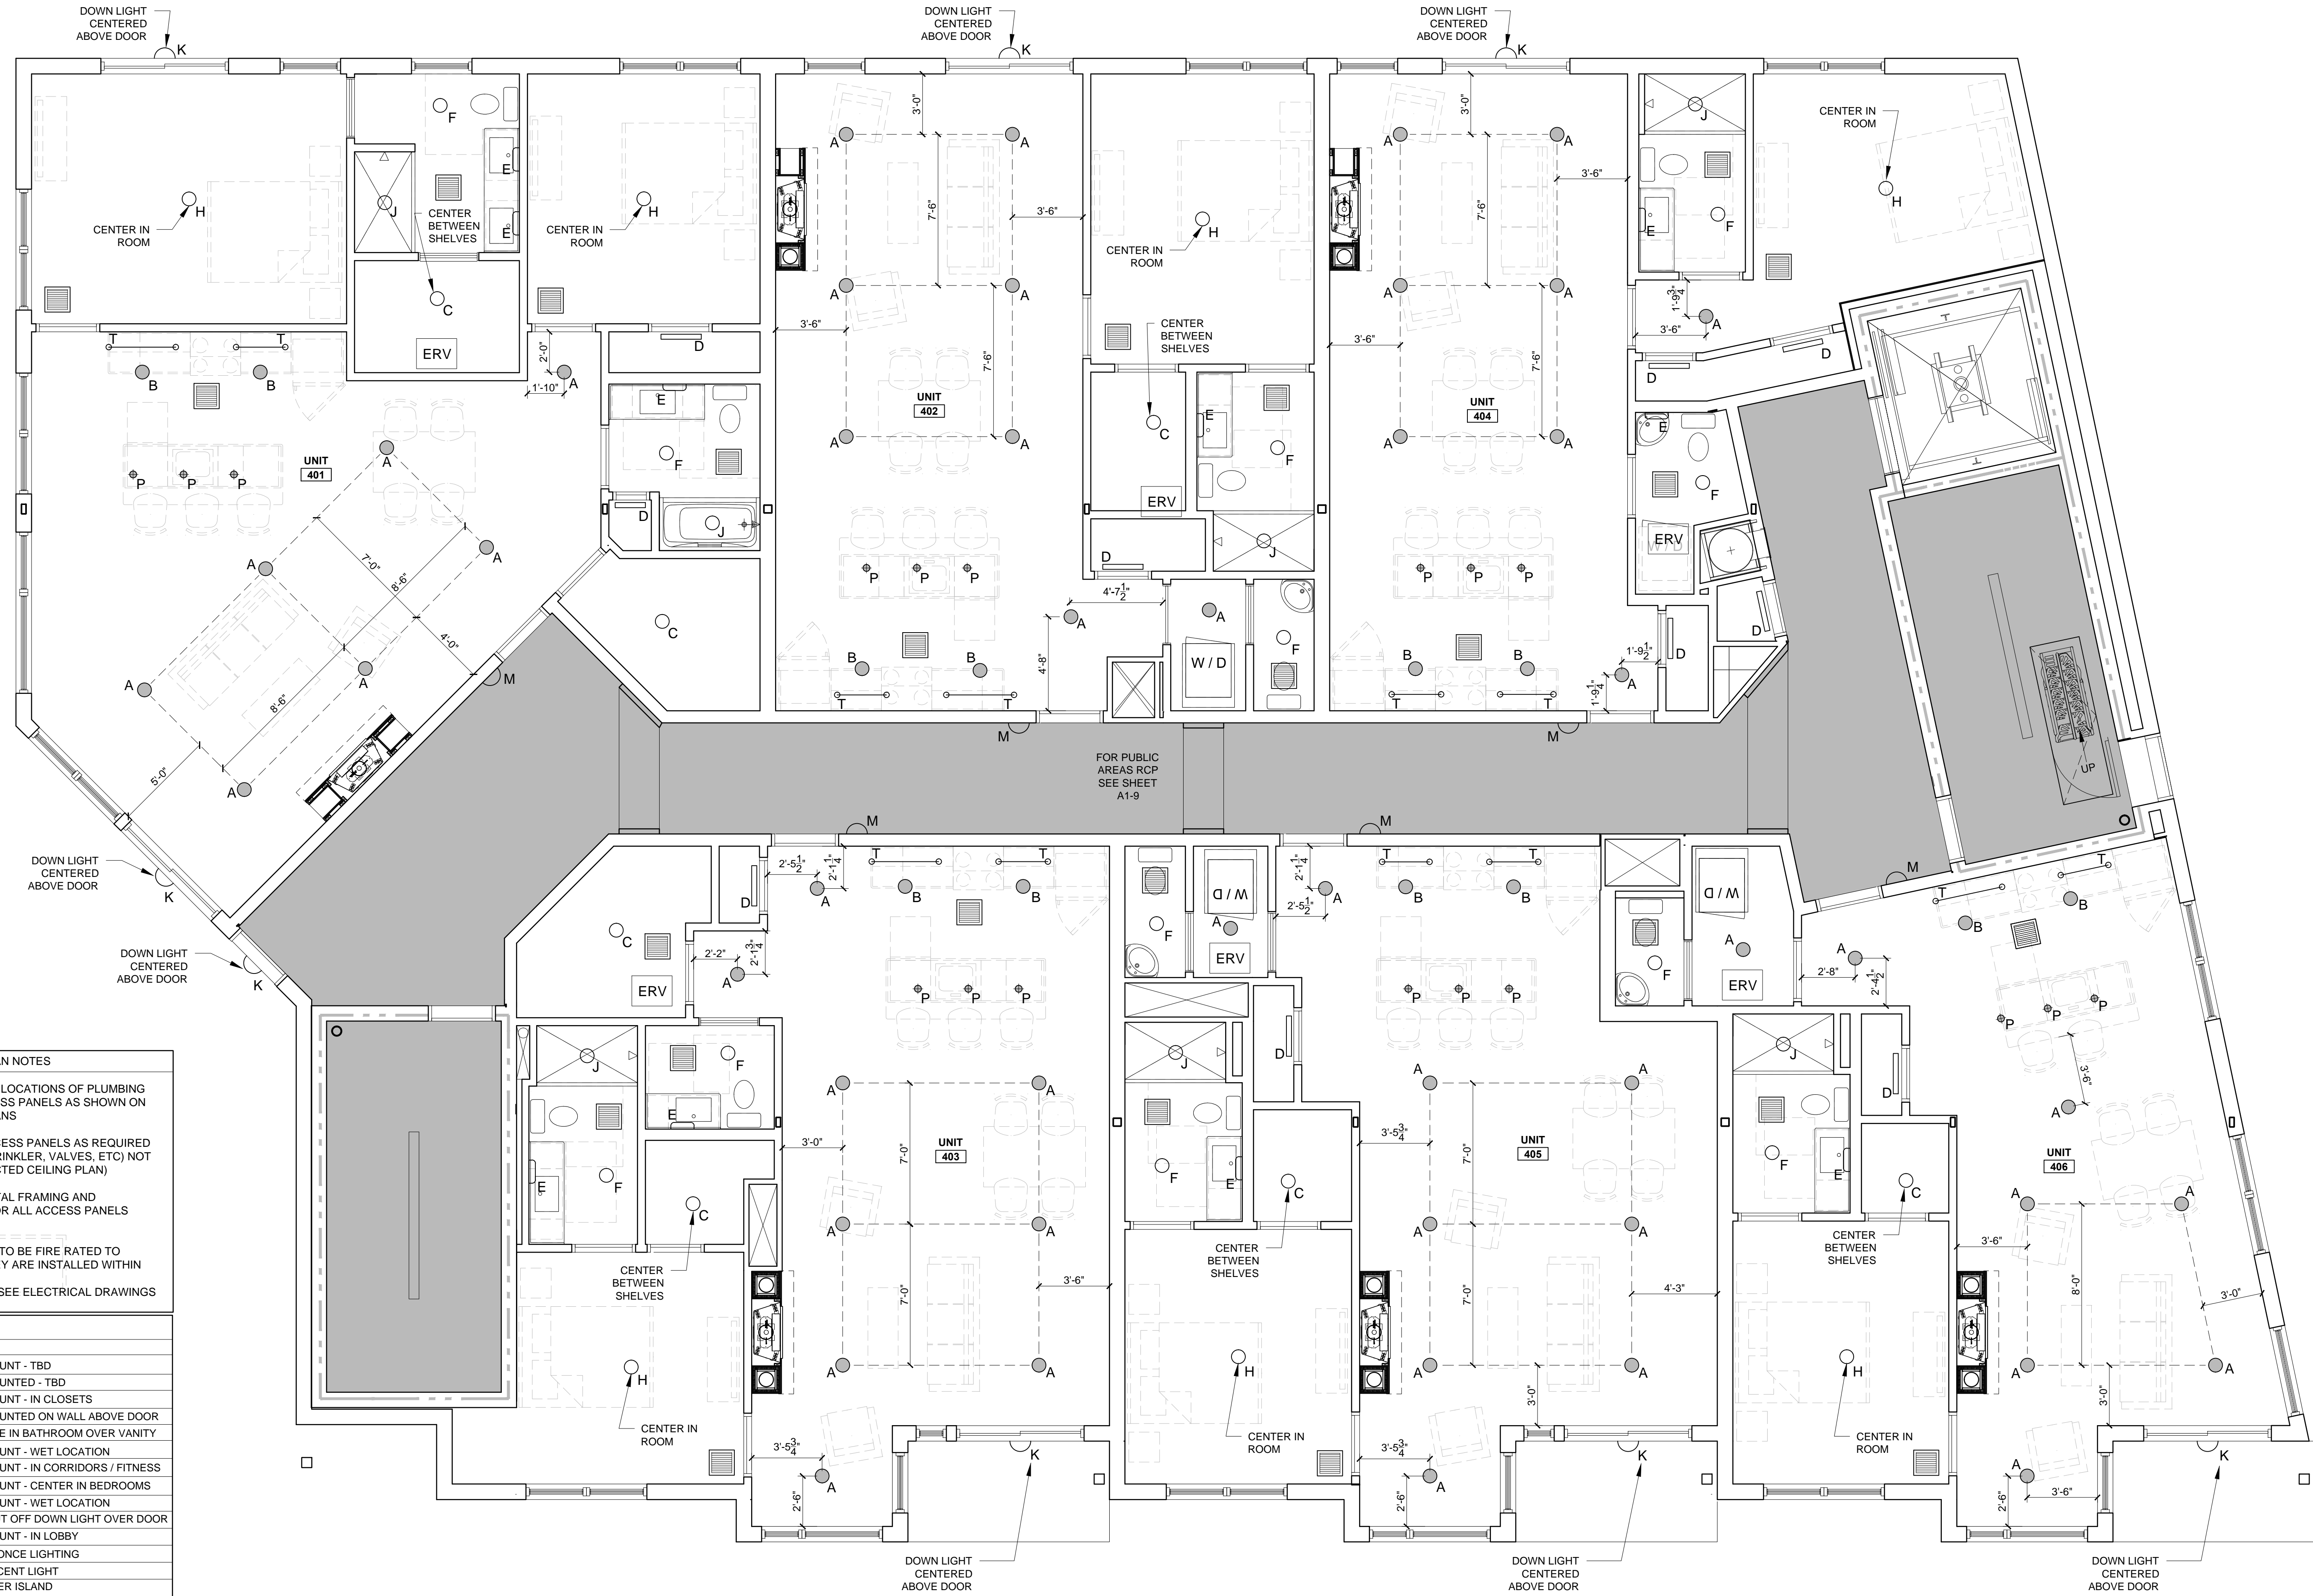

REFLECTED CEILING PLAN NOTES

- 1.) G.C. TO COORDINATE LOCATIONS OF PLUMBING CLEAN OUTS WITH ACCESS PANELS AS SHOWN ON REFLECTED CEILING PLANS
- 2.) G.C. TO PROVIDE ACCESS PANELS AS REQUIRED FOR ALL ELEMENTS (SPRINKLER, VALVES, ETC) NOT SHOWN ON THIS REFLECTED CEILING PLAN
- 3.) G.C. TO PROVIDE METAL FRAMING AND BLOCKING REQUIRED FOR ALL ACCESS PANELS AND CONTROL JOINTS
- 4.) ALL ACCESS PANELS TO BE FIRE RATED TO MATCH THE CEILING THEY ARE INSTALLED WITHIN
- 5.) FOR LIGHTING PLAN, SEE ELECTRICAL DRAWINGS

LIGHTING LEGEND

SYMBOL	TAG	DESCRIPTION
●	A	SURFACE MOUNT - TBD
○	B	SURFACE MOUNTED - TBD
○	C	SURFACE MOUNT - IN CLOSETS
—	D	SURFACE MOUNTED ON WALL ABOVE DOOR
—	E	WALL SCONCE IN BATHROOM OVER VANITY
○	F	SURFACE MOUNT - WET LOCATION
○	G	SURFACE MOUNT - IN CORRIDORS / FITNESS
○	H	SURFACE MOUNT - CENTER IN BEDROOMS
○	J	SURFACE MOUNT - WET LOCATION
⊙	K	EXTERIOR CUT OFF DOWN LIGHT OVER DOOR
○	L	SURFACE MOUNT - IN LOBBY
—	M	INTERIOR SCONCE LIGHTING
—	N	1'x4' FLORESCENT LIGHT
⊙	P	PENDANT OVER ISLAND
○	Q	LED UTILITY LIGHTING IN STAIRWELLS
□	R	LED PARKING GARAGE LIGHTING
△	S	EXTERIOR SCONCE DOWN LIGHTING
—	T	UNDER COUNTER LIGHTING
■		CEILING GRILL

1 UNIT 401-406 REFLECTED CEILING PLAN
1/4" = 1'-0"