
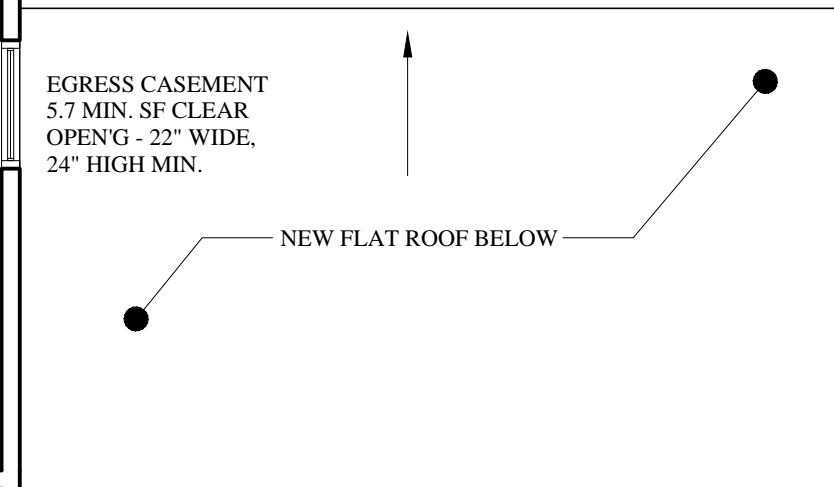


**LIFE SAFETY
LEGEND:**

- EXIT NEW EXIT SIGN
- SMOKE DETECTOR
- EXIT LIGHT

LIFE SAFETY AND FIRE ALARM SYSTEMS SHALL BE INSTALLED PER NFPA 12. COORDINATE FIXTURE LOCATIONS W/ CITY OF PORTLAND FIRE DEPARTMENT. THE OFFICE AND LIVING UNIT SYSTEMS SHALL COMMUNICATE IN CASE OF EMERGENCY.

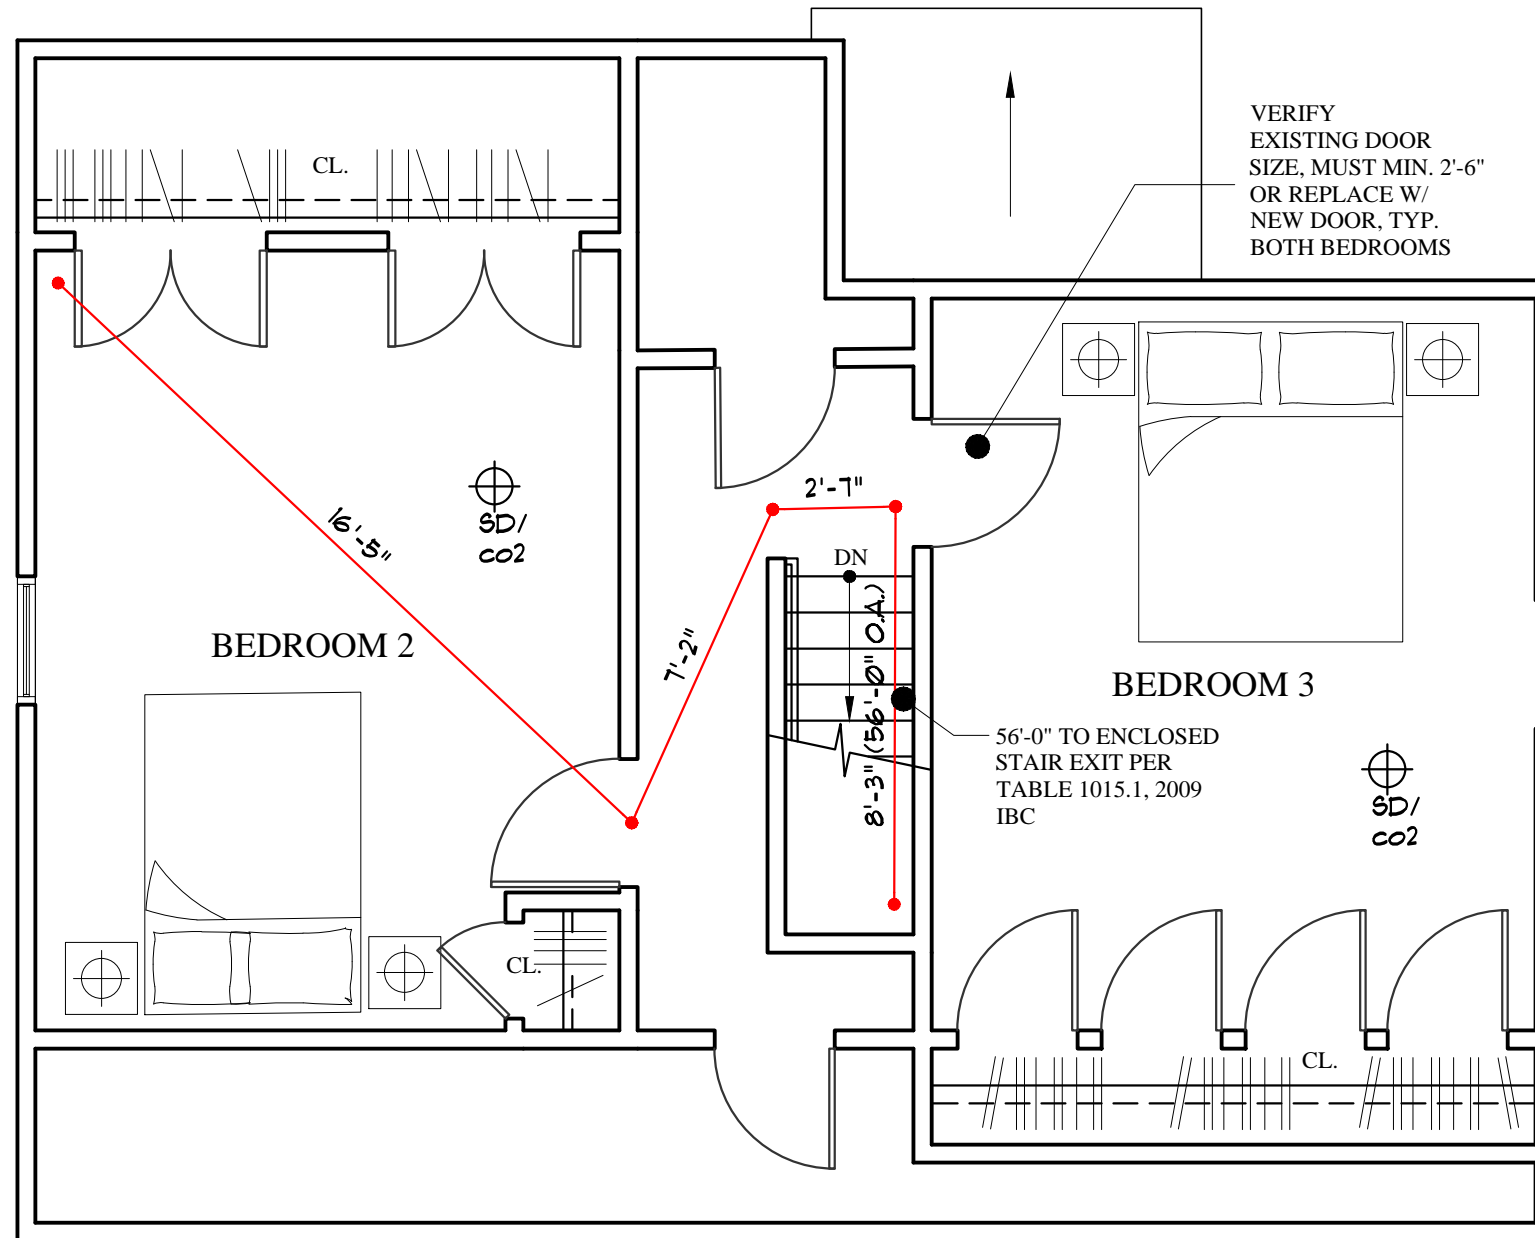

NOTE: ALL WALLS THIS FLOOR PLAN ARE EXISTING

THIRD FLOOR PLAN

SCALE: 1/4" = 1'-0" FINISHED AREA = 541 SF

BUILDING PERMIT SET: NOVEMBER 18, 2015