



Bob's Clam Hut
109 Cumberland Avenue
Portland, Maine

OWNER
Bob's Clam Hut
315 U.S. Route 1
Kilby, Maine
Telephone: (207) 439-4233
Contact: Michael Landgarten

DESIGNER
Paul Bennett Architect PC
25 West 31st Street, Floor 7
New York, New York 10001
Telephone: (212) 209-1177
Contact: Lisa Wright

DESIGNER
Bennett Engineering, Inc.
7 Bennett Road, P.O. Box 297
Freeport, ME 04032
Telephone: (207) 865-9475
Contact: William Bennett

KITCHEN CONSULTANT
TriMark
505 Collins Street
South Westboro, MA 02703-8039
Telephone: (508) 399-6000
Contact: Ed Dresser

REV	NO	DATE	COMMENTS
-----	----	------	----------


PROJECT
Bob's Clam Hut
109 Cumberland Avenue
Portland, Maine

FILE

FIG. NO.


M-1.01

SEAL & SIGNATURE

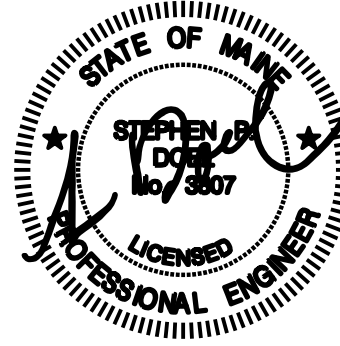


DESIGNER
PAUL BENNETT ARCHITECT PC
25 WEST 31ST STREET, NEW YORK, NEW YORK 10001
TEL. (212) 209-1177


ISSUED FOR PERMIT

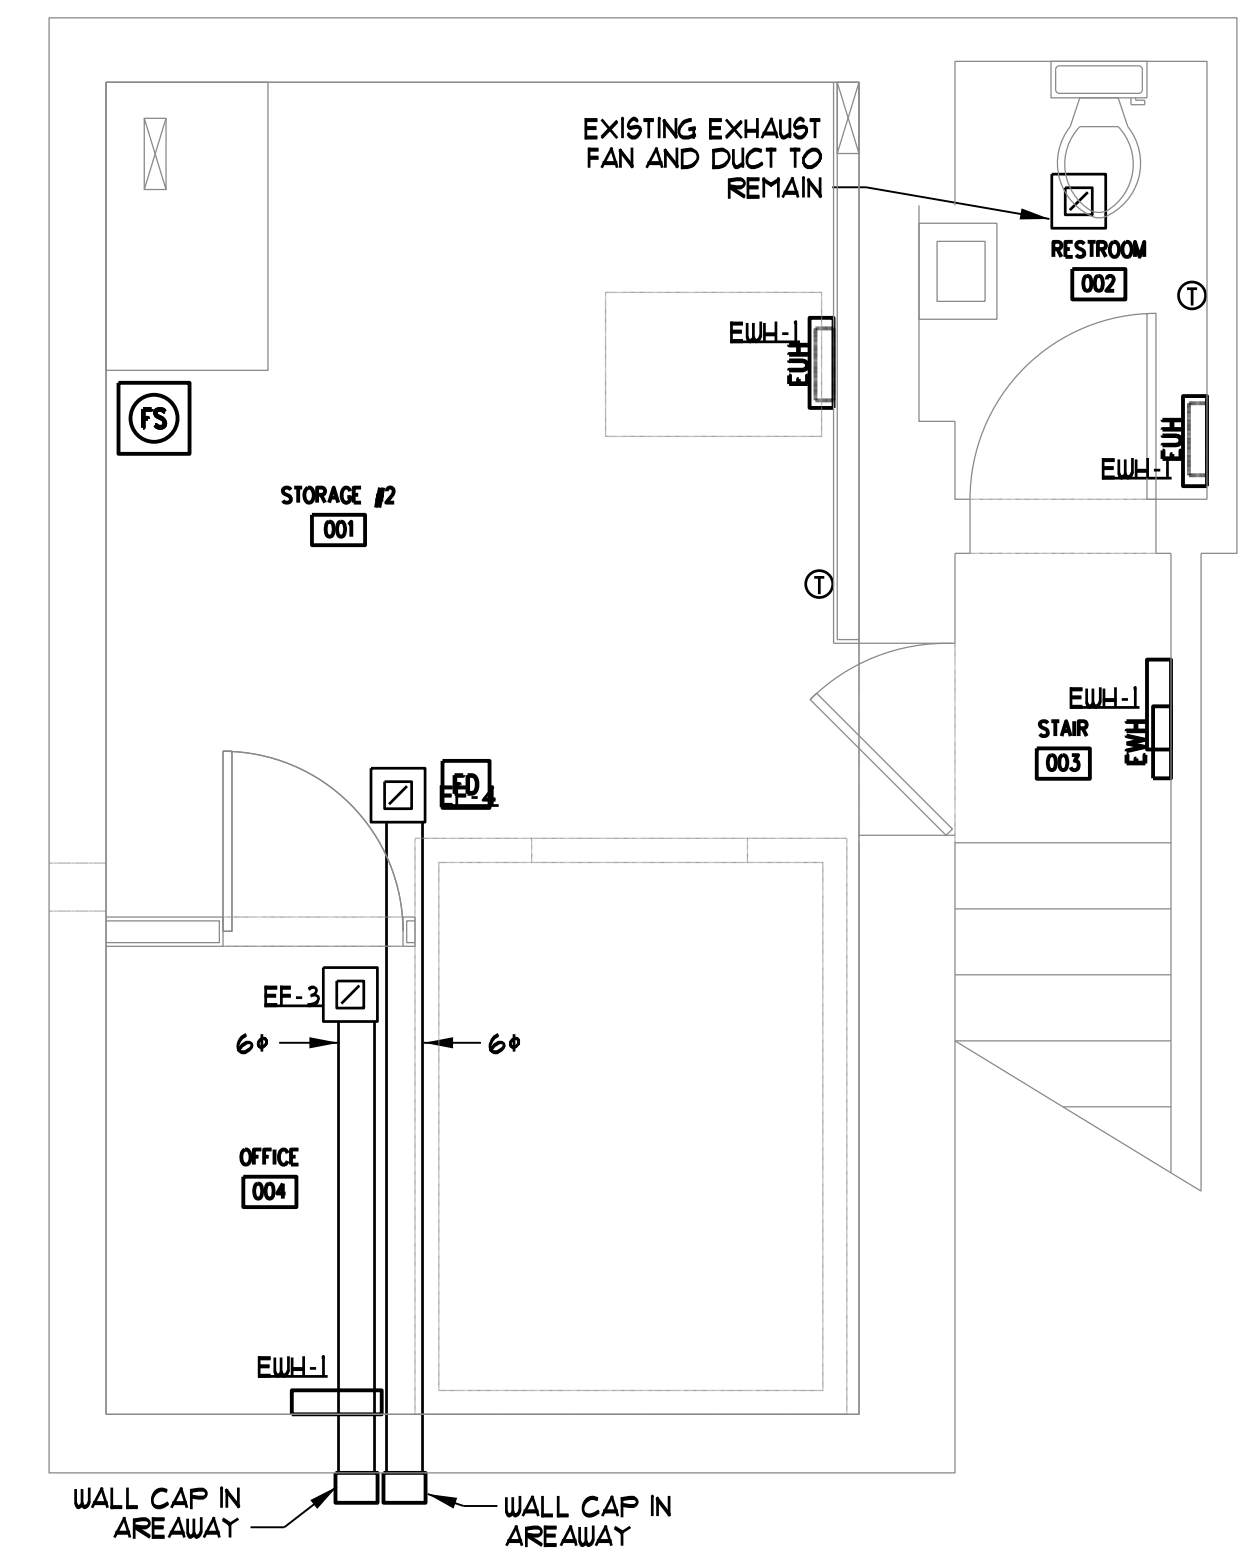


BASEMENT MECHANICAL PLAN
SCALE - 3/8" = 1'-0"

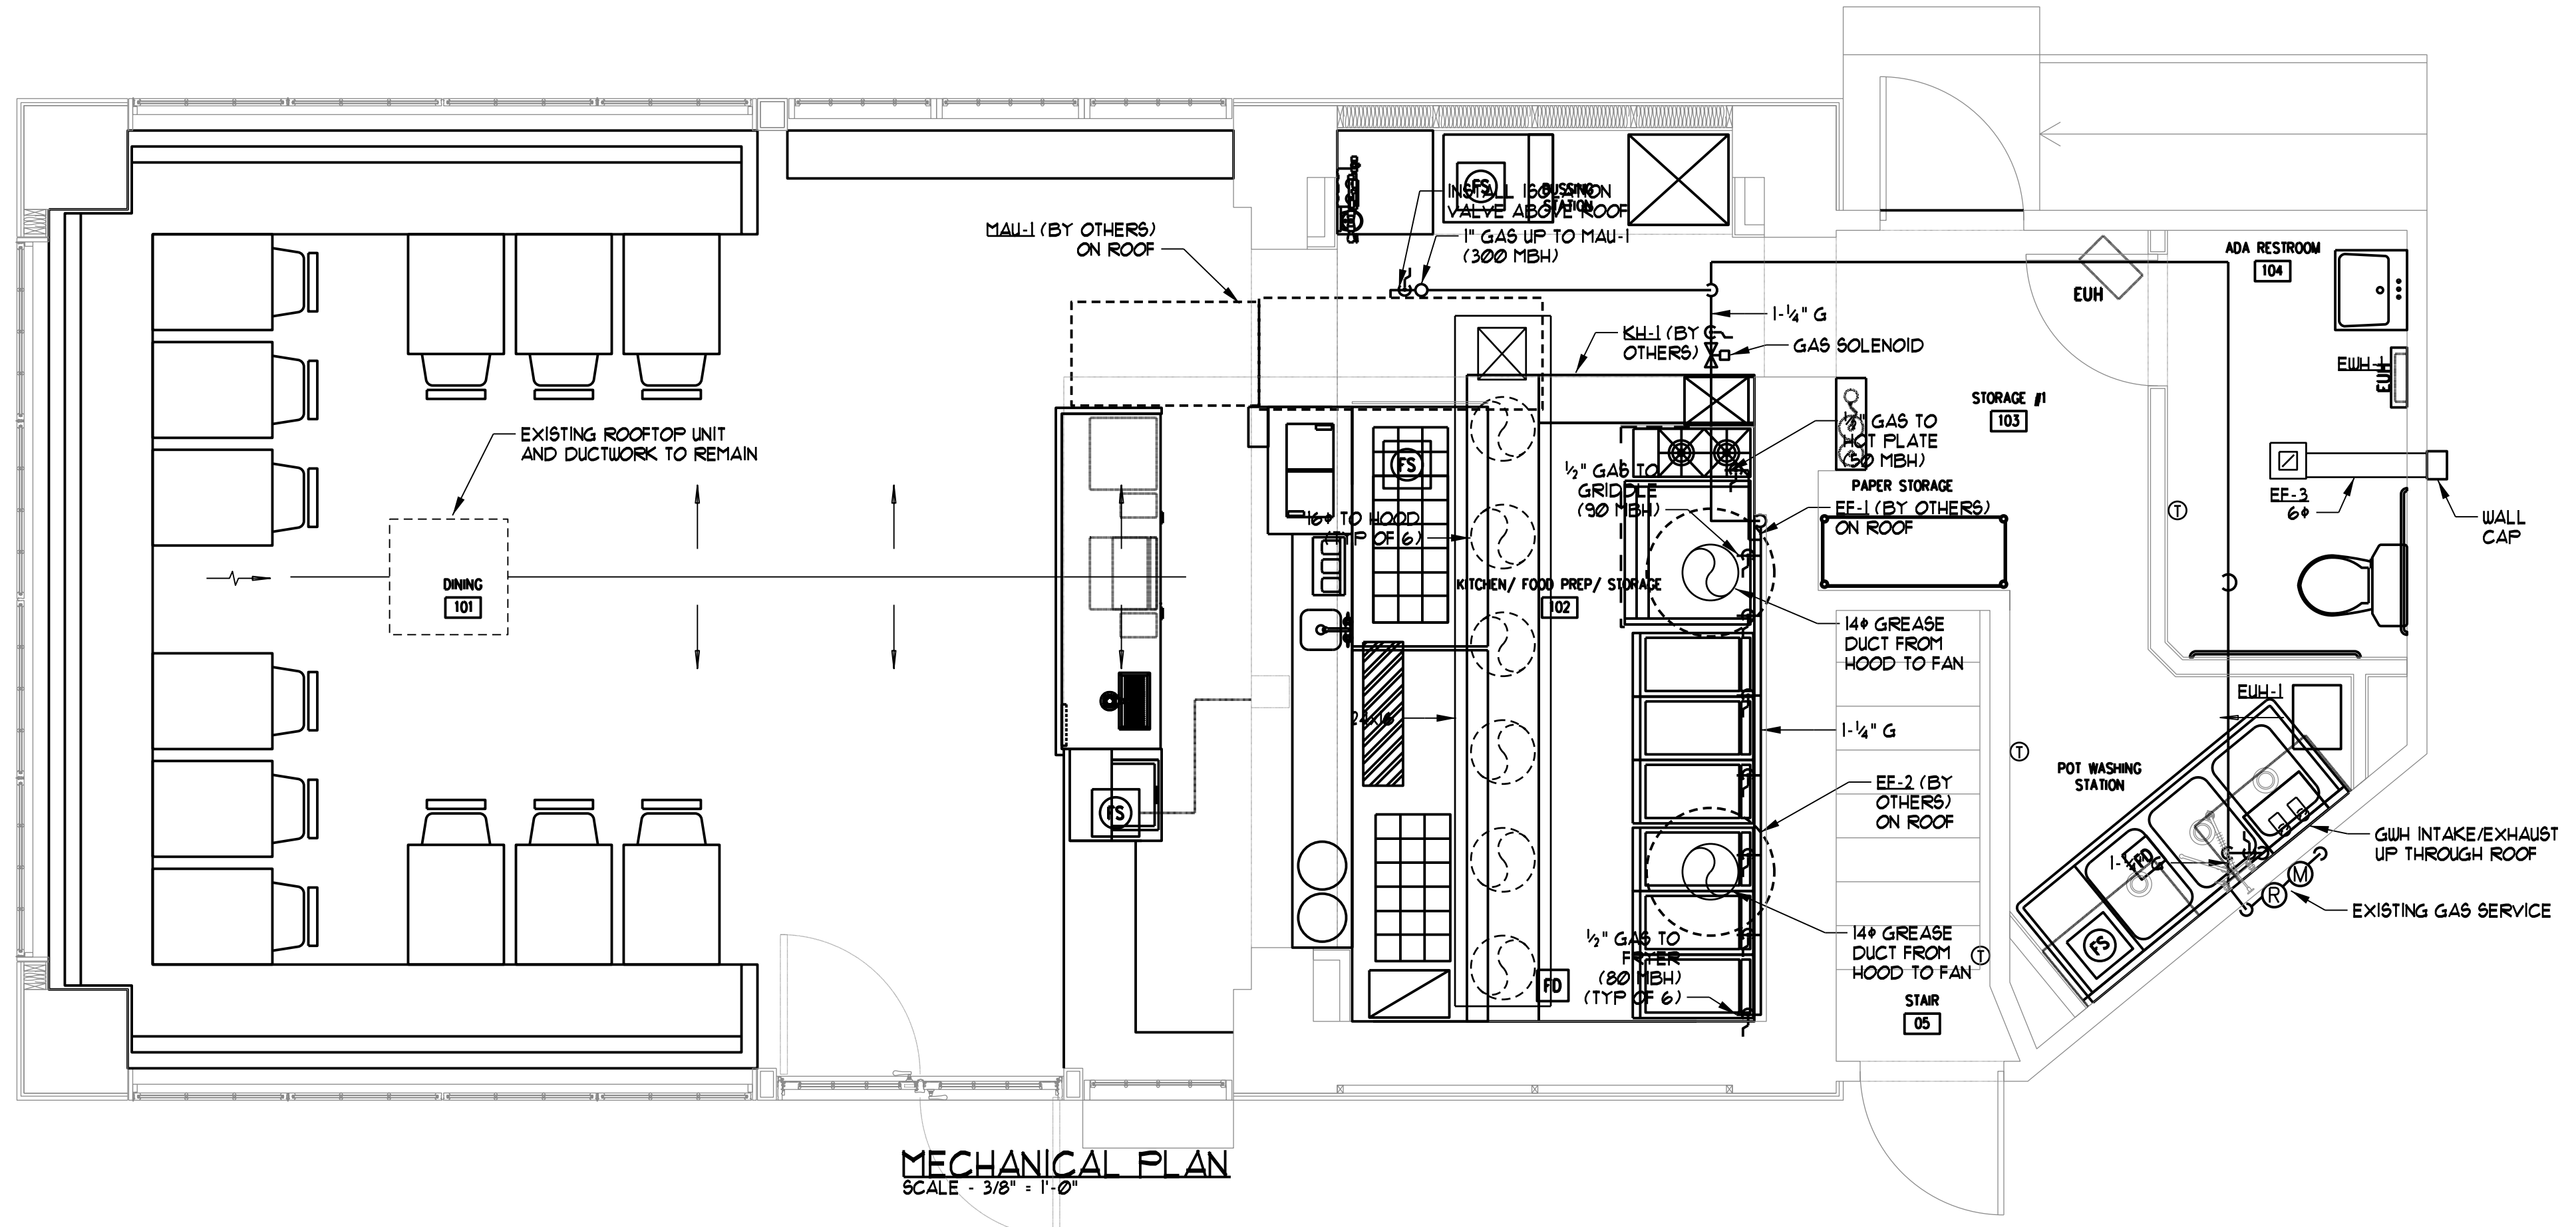

MECHANICAL PLAN
SCALE - 3/8" = 1'-0"

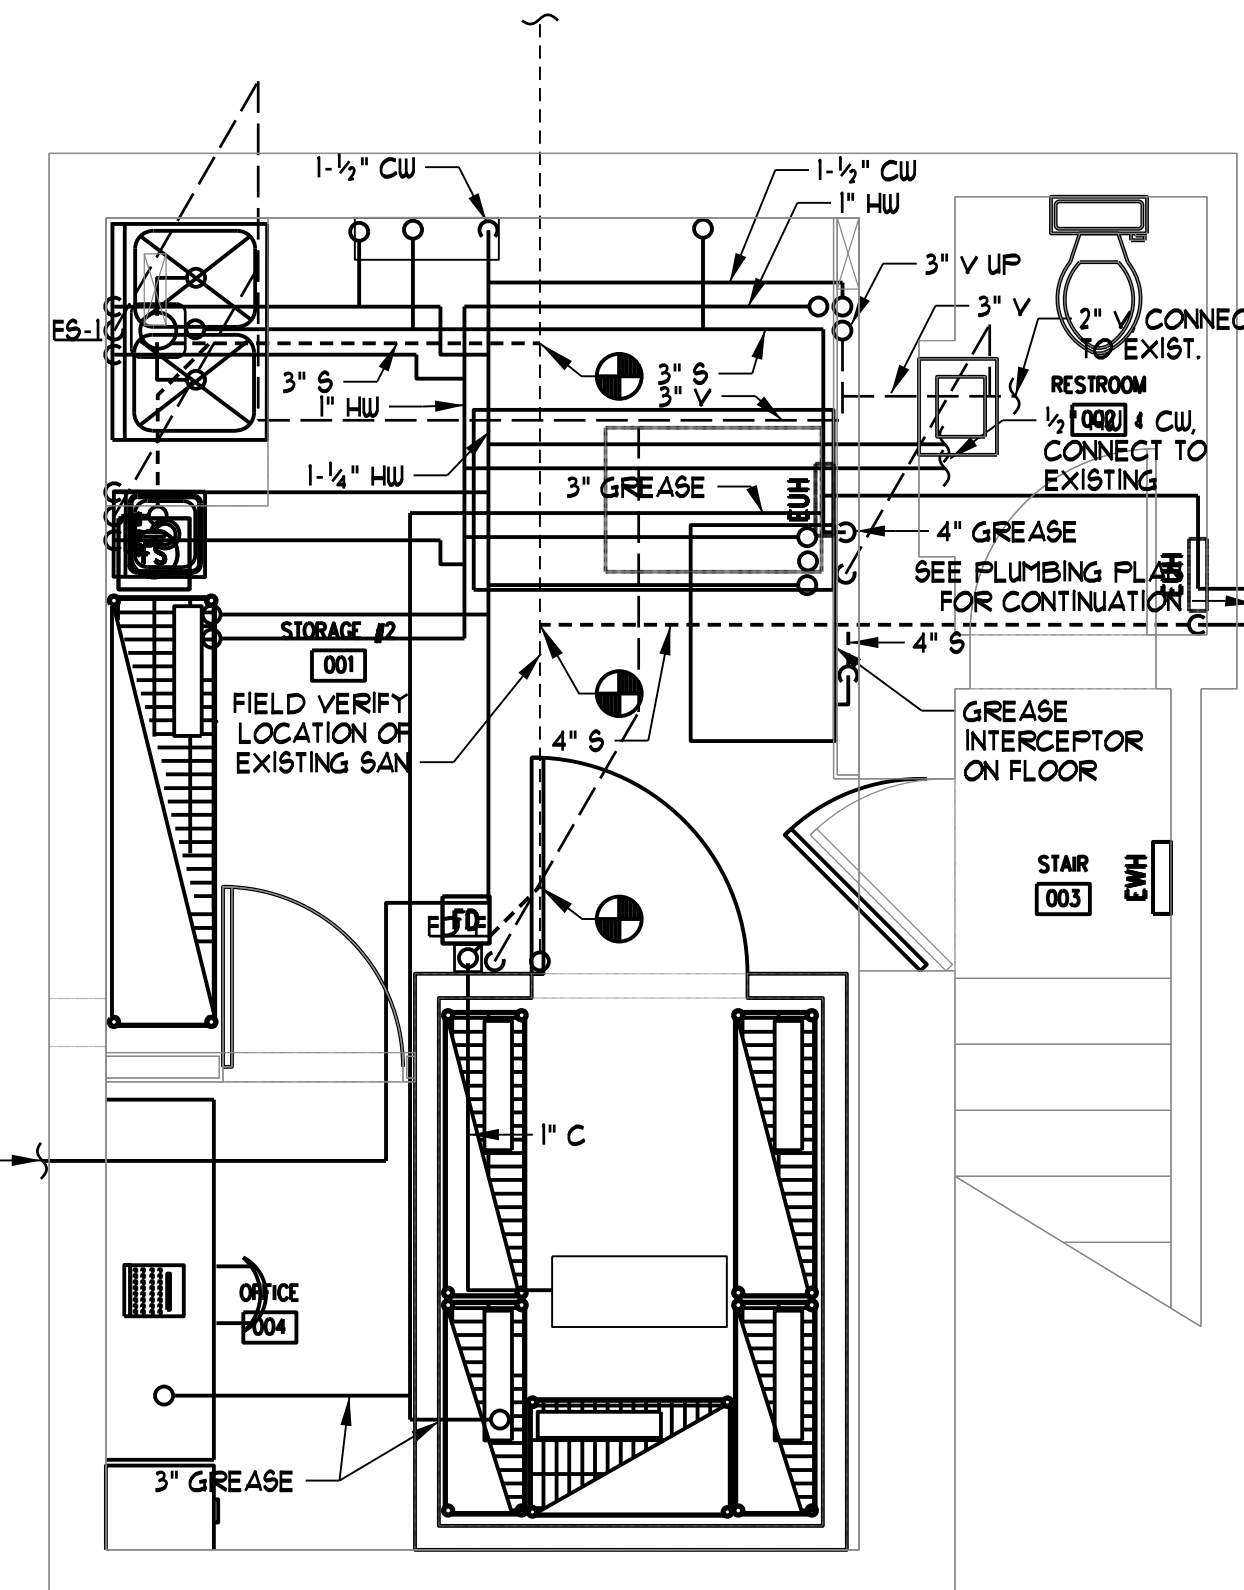

BASEMENT PLUMBING PLAN
SCALE - 3/8" = 1'-0"

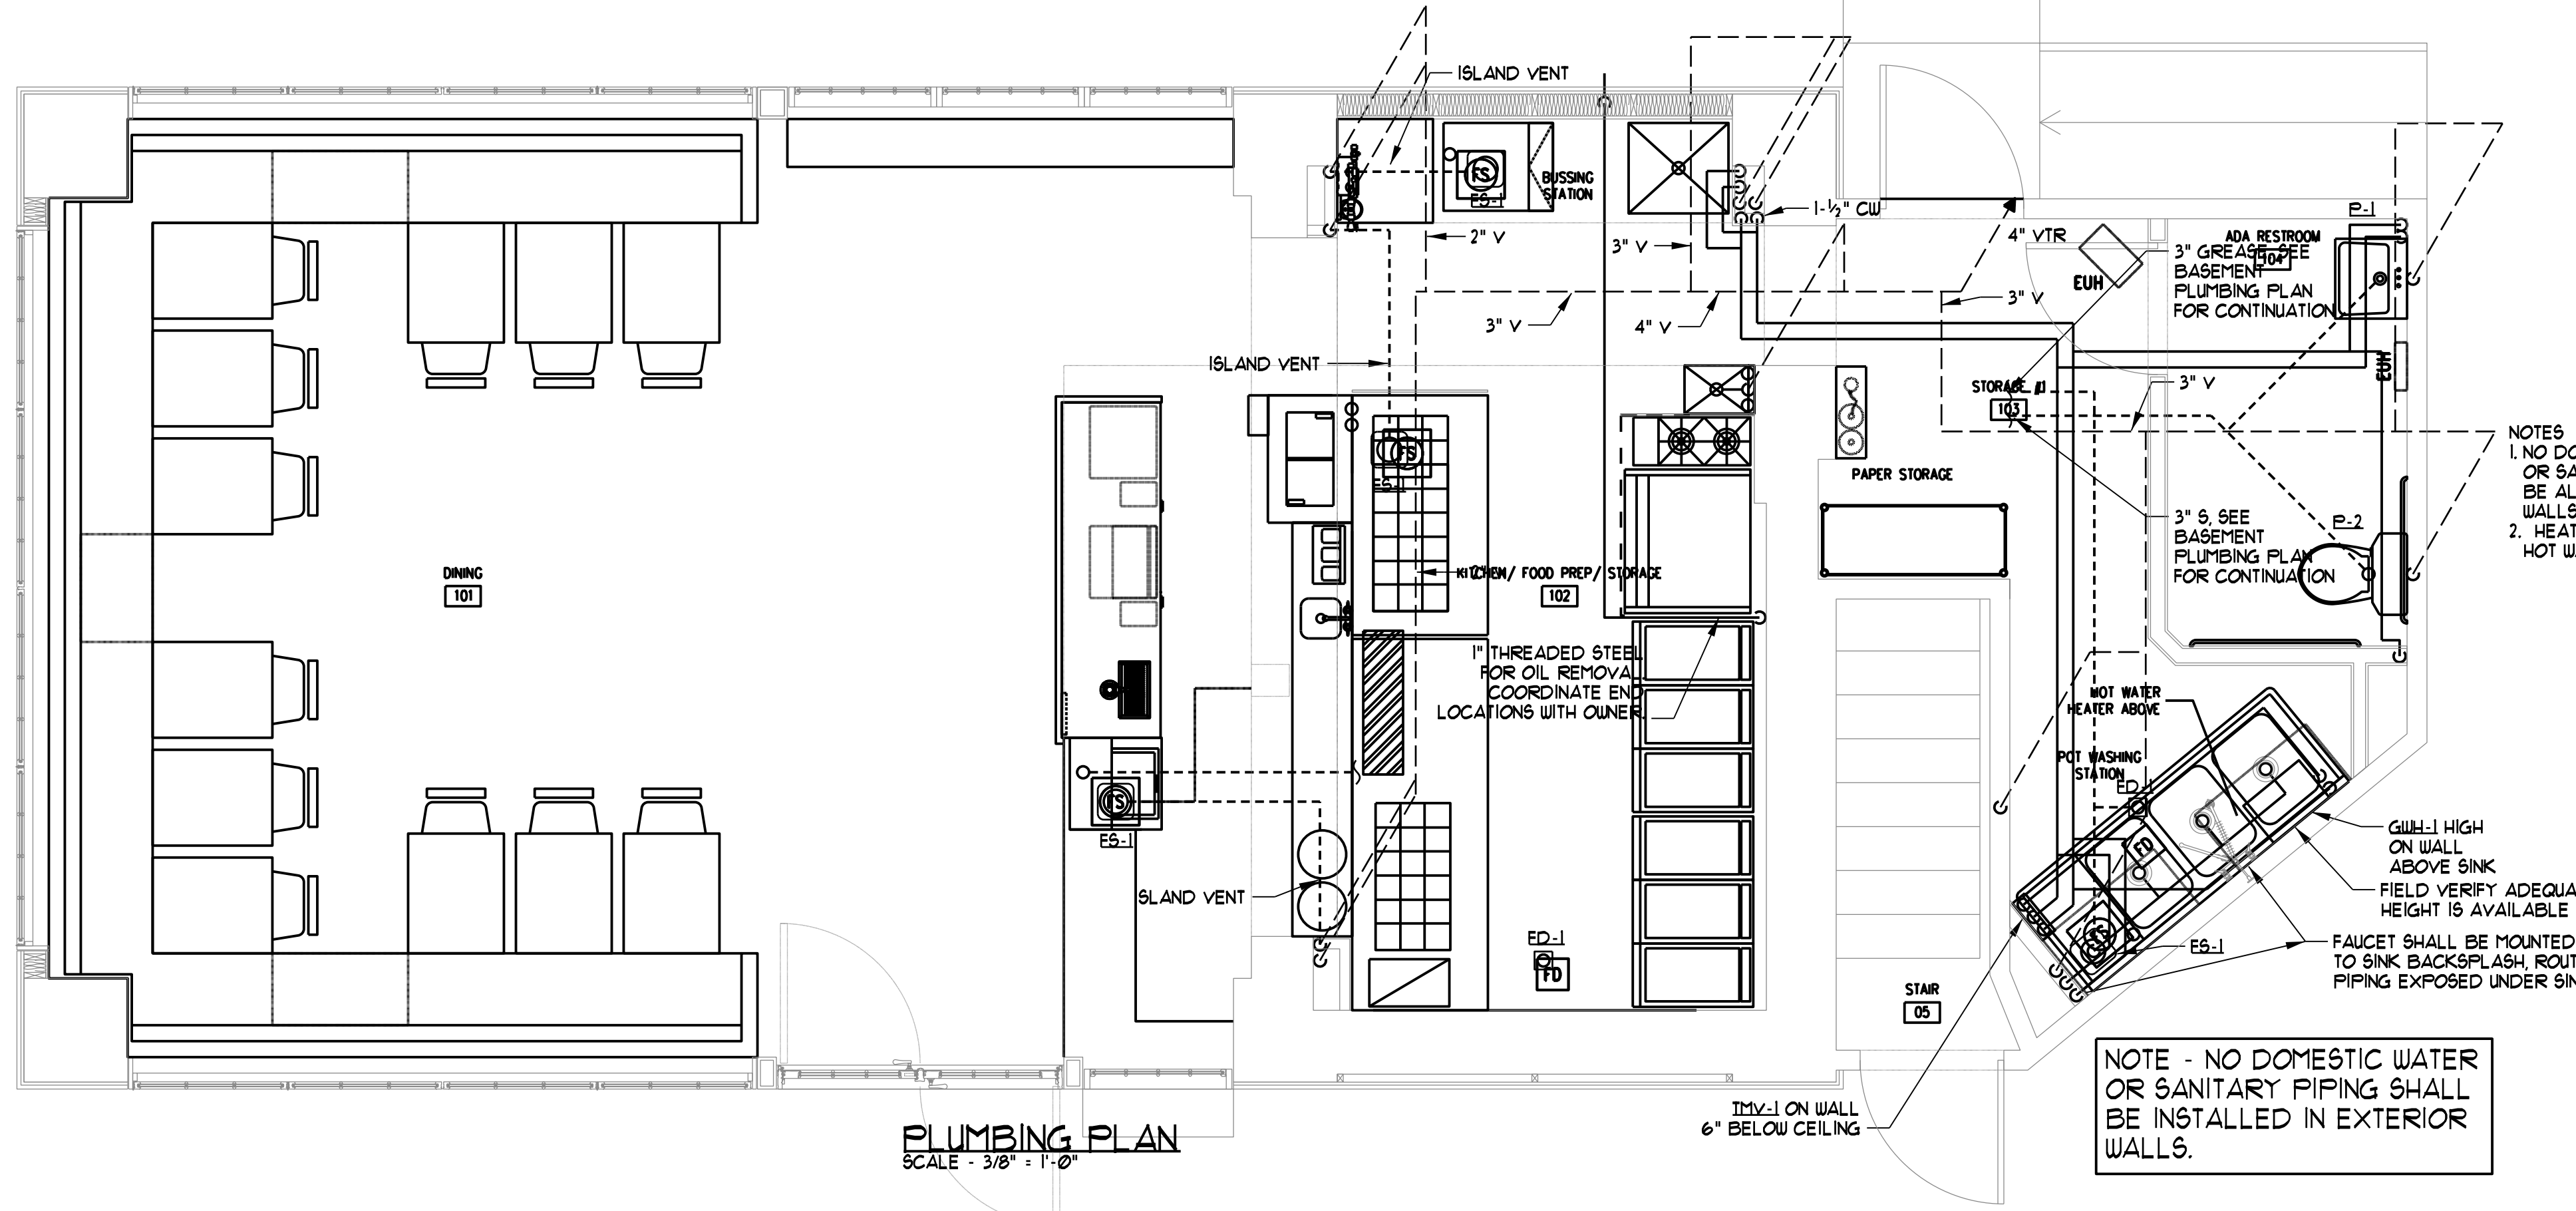

PLUMBING PLAN
SCALE - 3/8" = 1'-0"

- NOTES
1. NO DOMESTIC WATER OR SANITARY PIPING SHALL BE ALLOWED IN EXTERIOR WALLS.
 2. HEAT TRACE ALL DOMESTIC HOT WATER PIPING.

NOTE - NO DOMESTIC WATER OR SANITARY PIPING SHALL BE INSTALLED IN EXTERIOR WALLS.

1/2" CU UNDERSLAB TO SODA DISPENSER

1" THREADED STEEL FOR OIL REMOVAL COORDINATE END LOCATIONS WITH OWNER

3" GREASE TRAP SEE BASEMENT PLUMBING PLAN FOR CONTINUATION

3" GREASE TRAP SEE BASEMENT PLUMBING PLAN FOR CONTINUATION

