


SCALE 1/16" = 1'-0"  
 SCALE 1/8" = 1'-0"  
 SCALE 1/4" = 1'-0"

No Work In This Area  
 (existing apartments)

★ sprinkles

pull station →

Fire alarm

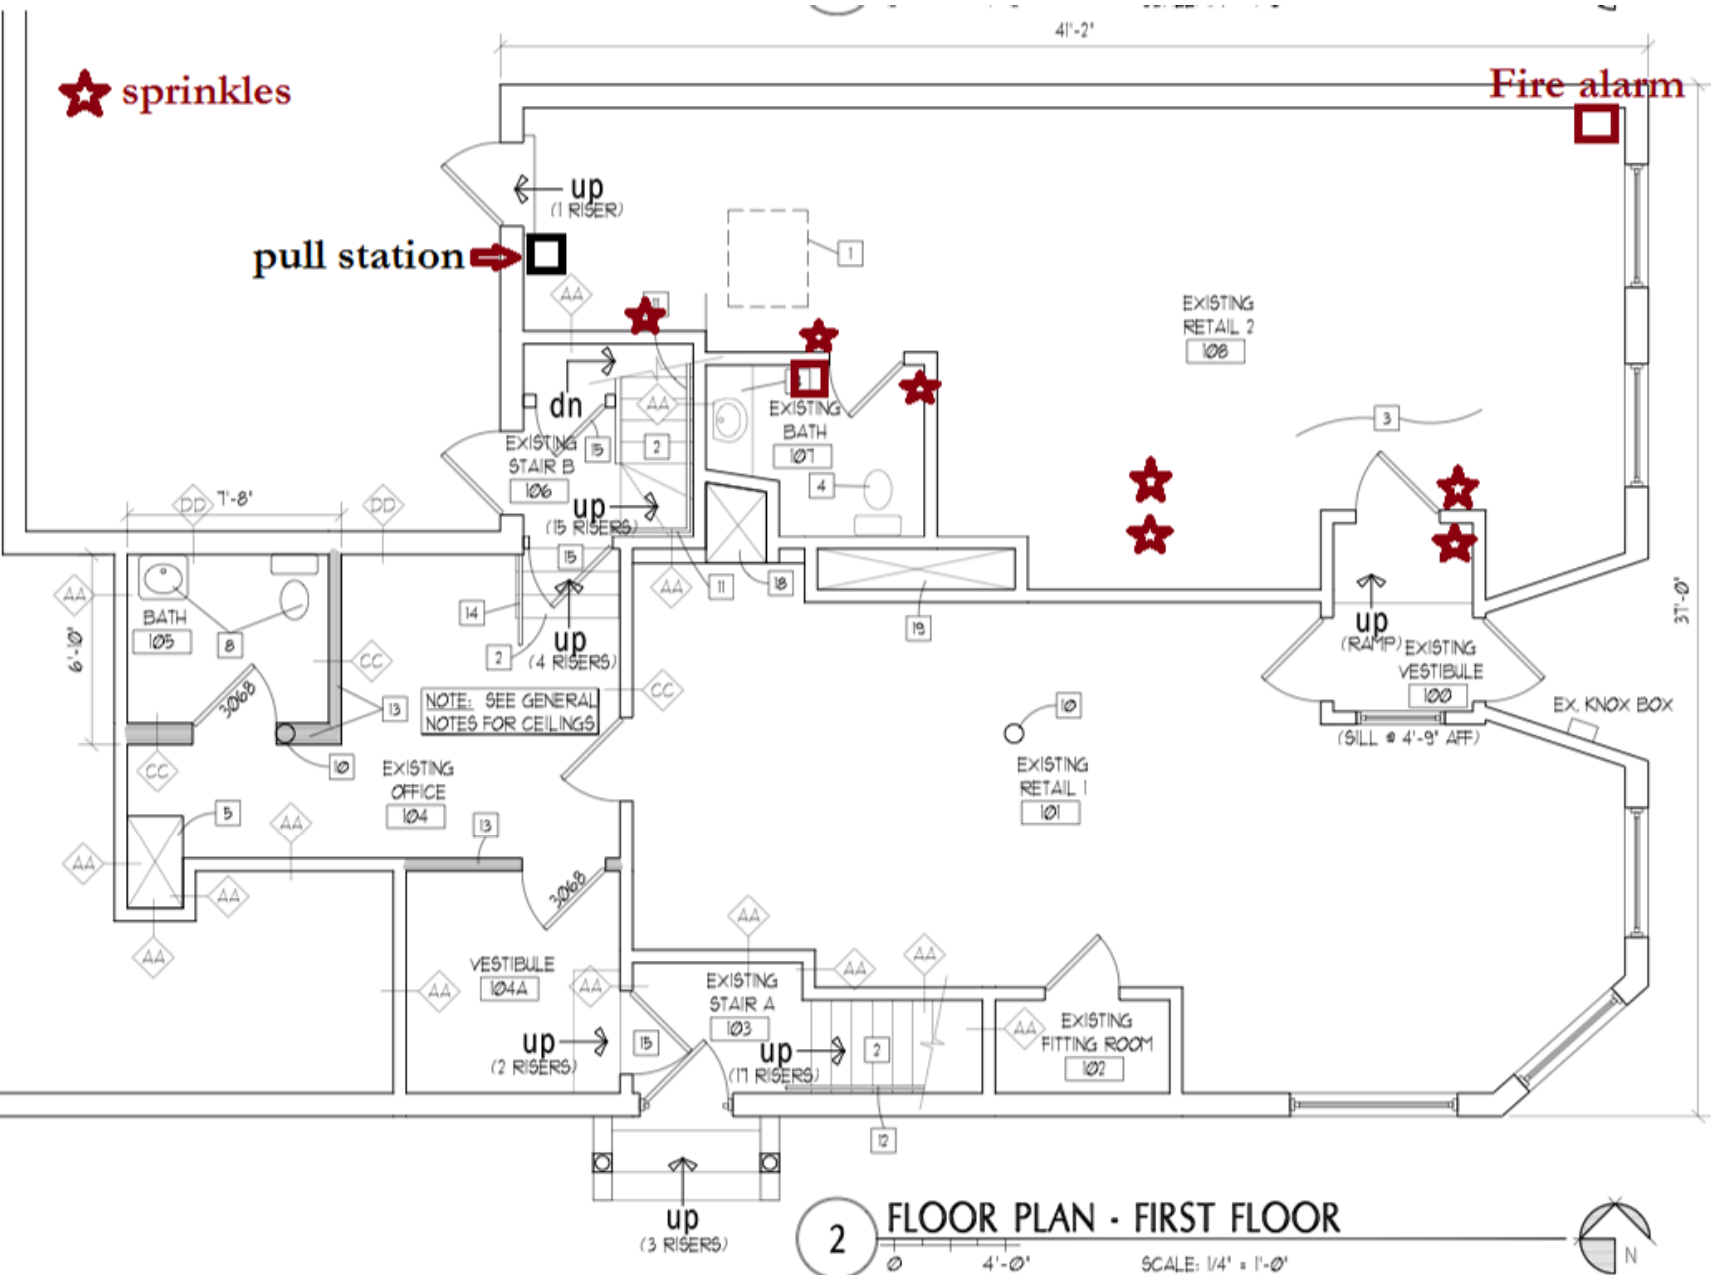

2 FLOOR PLAN - FIRST FLOOR  
 SCALE: 1/4" = 1'-0"

