



DEMOLITION NOTES:


- △ REMOVE WINDOW.
- △ REMOVE WALL.
- △ REMOVE DOOR AND FRAME.
- △ REMOVE CHIMNEY.
- △ REMOVE APPLIANCES.
- △ REMOVE PLUMBING FIXTURE.
- △ REMOVE/STORE TOILET FOR REINSTALLATION.
- △ REMOVE EXTERIOR WOOD STAIR.
- △ REMOVE KITCHEN CABINETS AND COUNTER.
- △ REMOVE EXTERIOR WOOD DECK.
- △ REMOVE STAIRS.
- △ REMOVE ROOF.

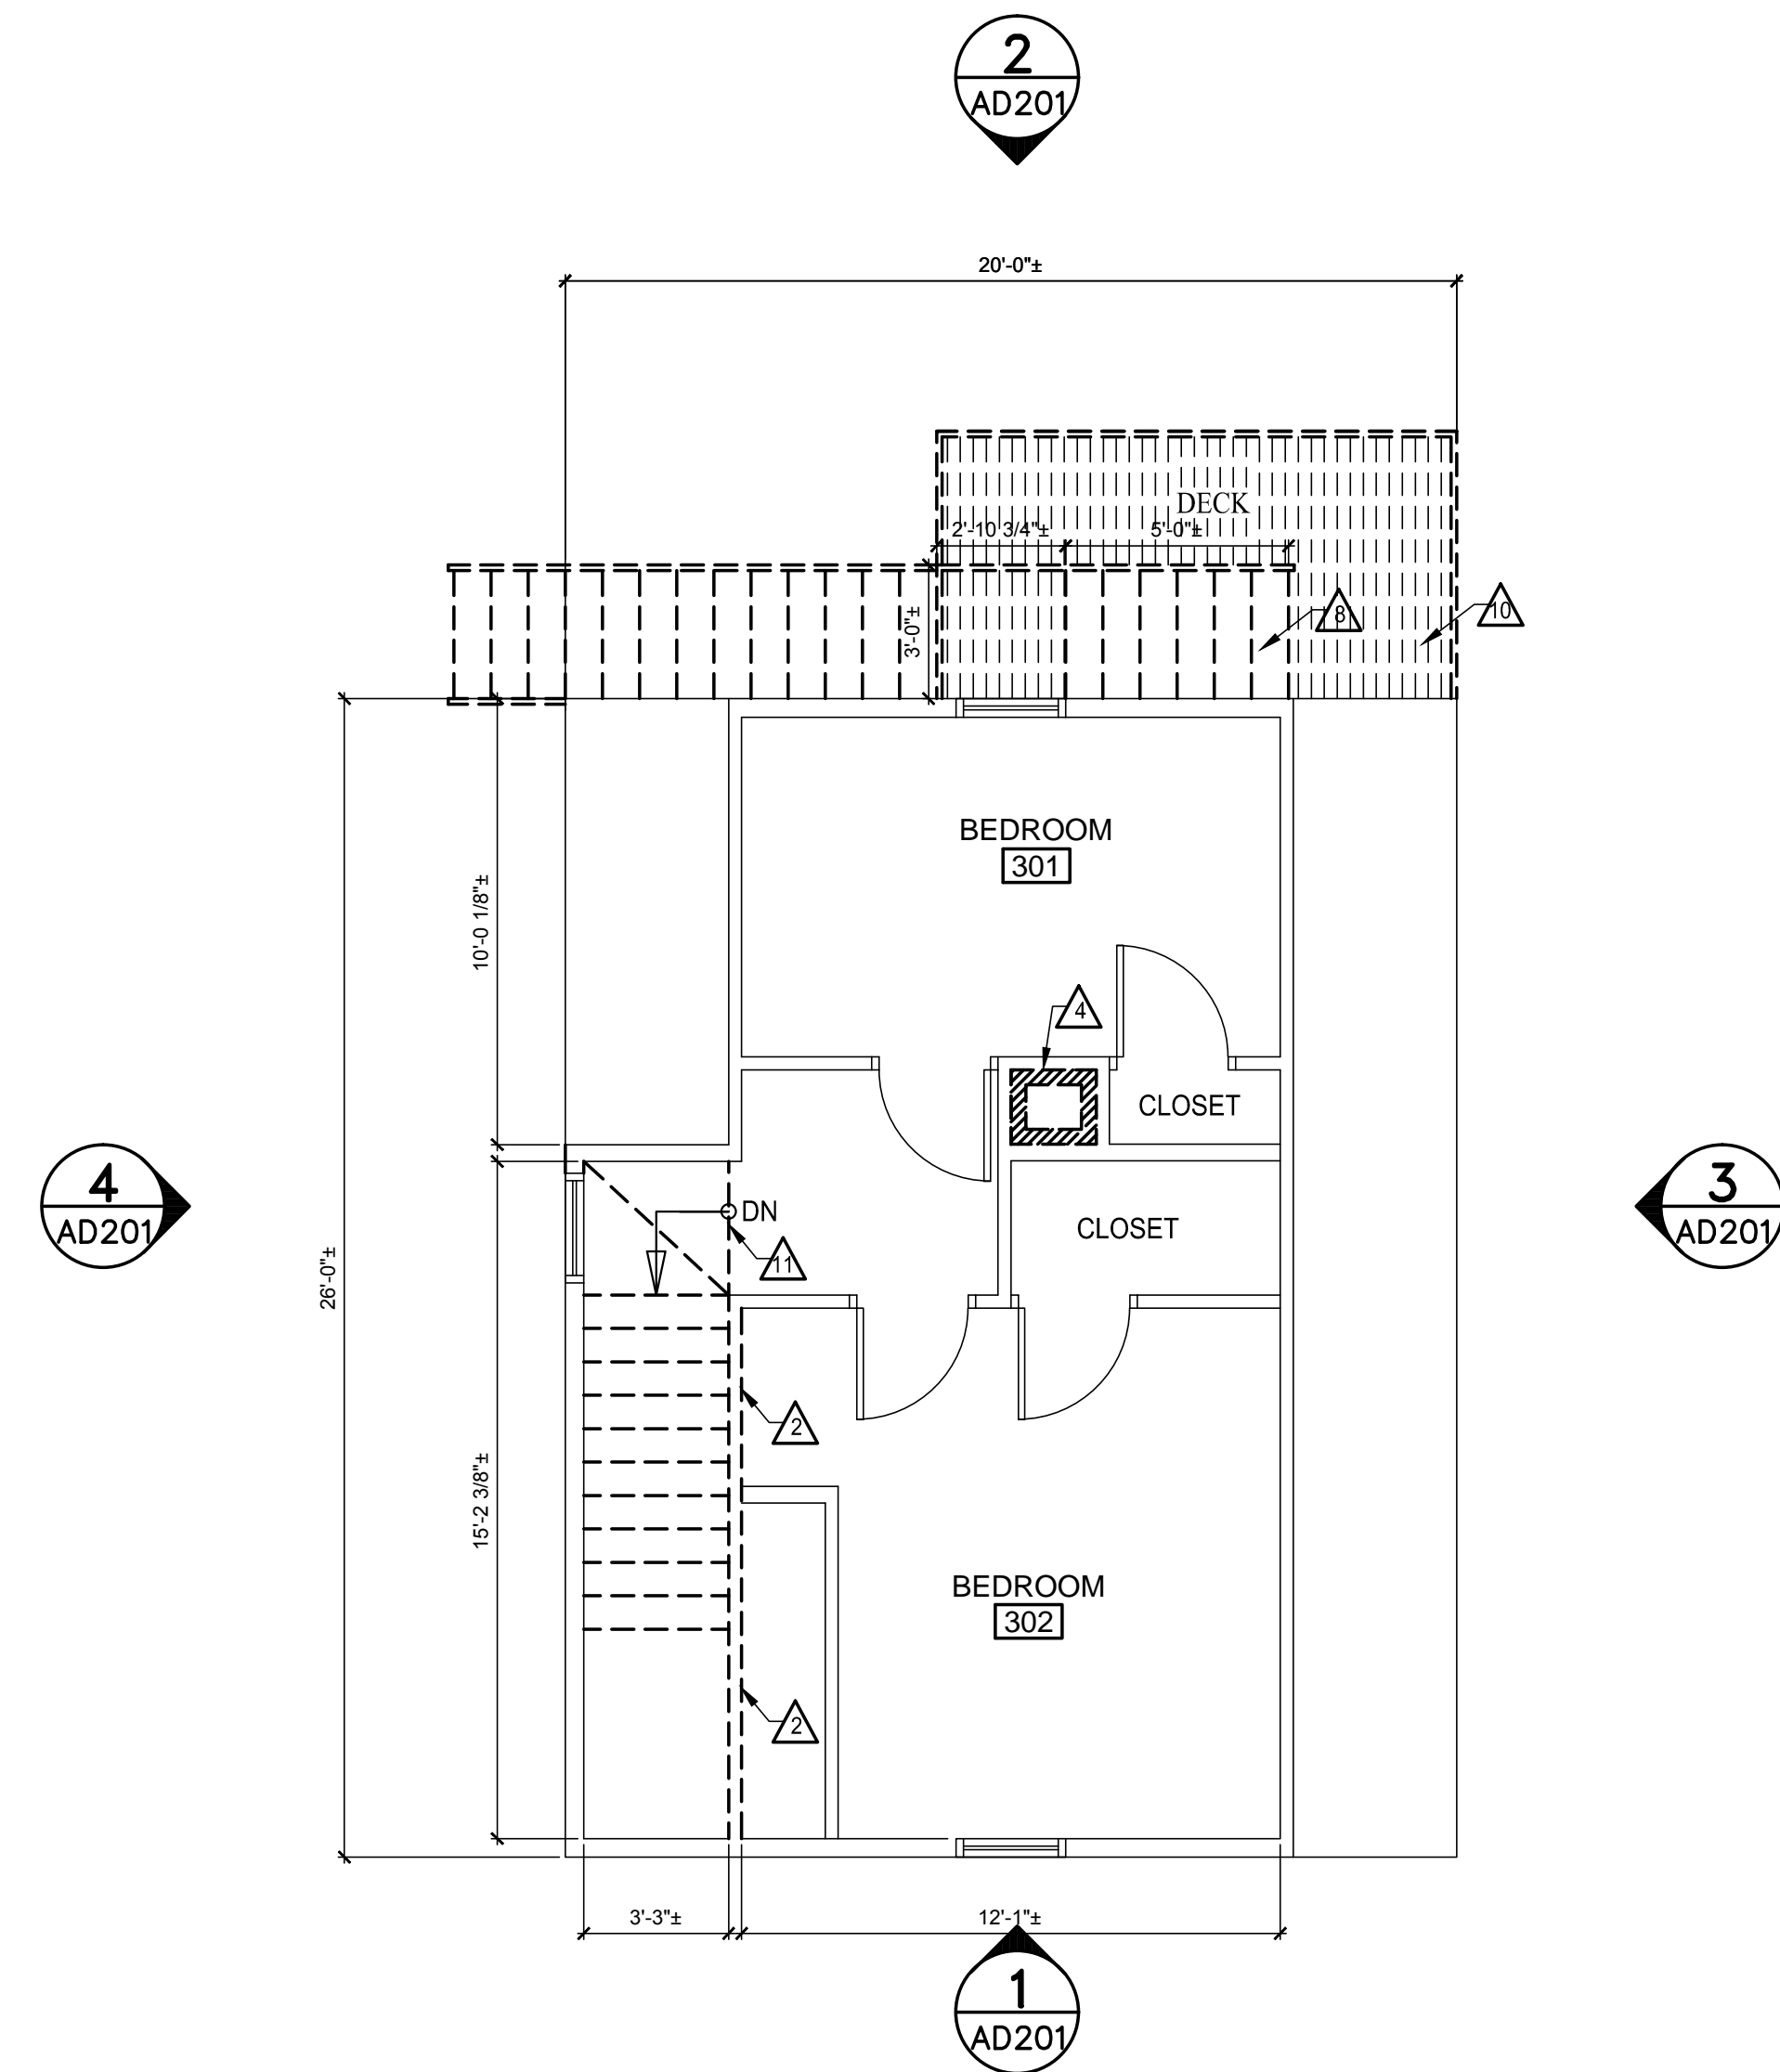

1 DEMO SECOND FLOOR
AD102 SCALE: 1/4"=1'-0"

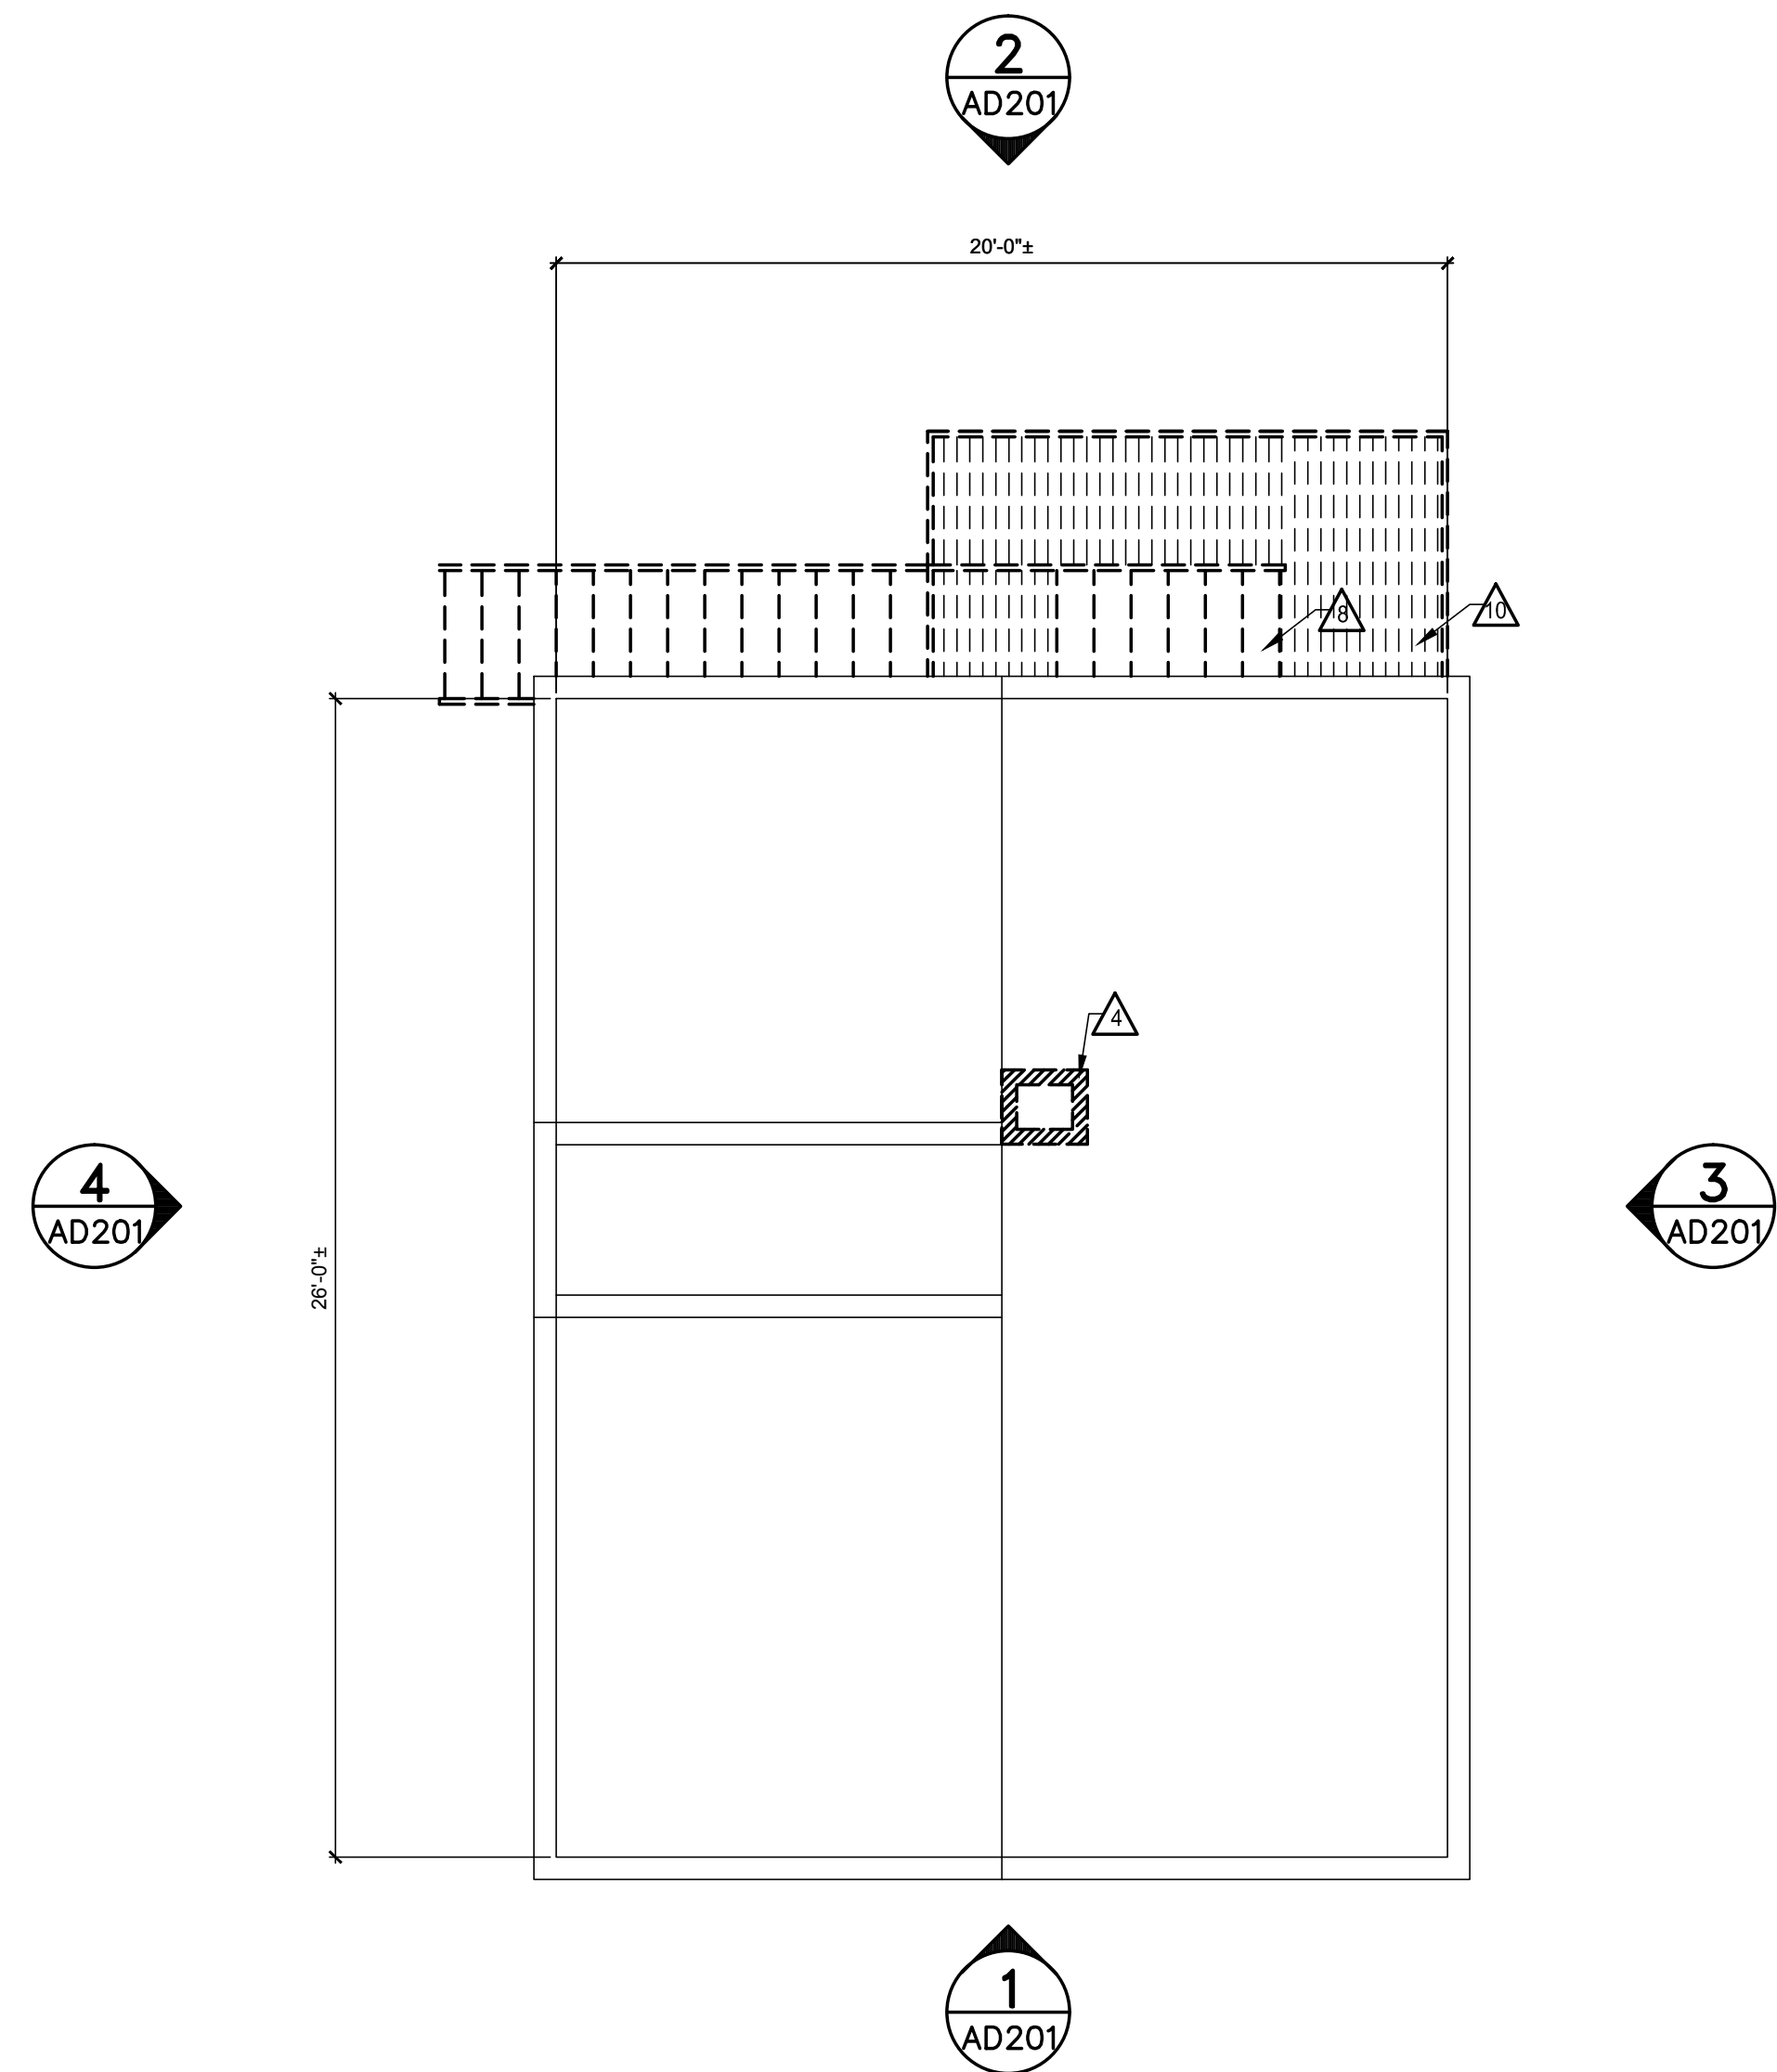

2 DEMO ROOF PLAN
AD102 SCALE: 1/4"=1'-0"

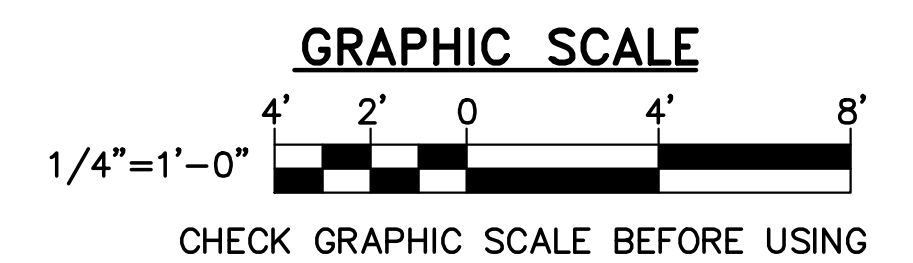

DESIGNED BY: NJD
DRAWN BY: NJD
CHECKED BY: NJD
PROJECT: XXXXX.XX

UNLEVEL HOUSE
12 ROMASCO LN, PORTLAND, ME

DEMO
SECOND
FLOOR AND
ROOF PLANS

SCALE: AS NOTED
DATE: 3-30-12
DWG.: AD102
SHEET: OF -