

Gawron Turgeon ARCHITECTS
 19 Black Point Road
 Scarborough, Maine 04074
 Tel: 207-883-5222 Fax: 207-883-0361

GOODWILL INDUSTRIES
 75 WASHINGTON AVENUE - THIRD FLOOR
 PORTLAND, MAINE


REVISIONS	DATE	DESCRIPTION	PREPARED BY
1	08.21.13		
2			

DATE	08.21.13
PROJECT #	PR0113
DRAWN BY:	DLP
CHECKED BY:	NET
DRAWING SCALE	AS NOTED

SHEET TITLE
THIRD FLOOR POWER PLAN
LEGEND/NOTES

A200

© COPYRIGHT 1982-2011
 ALL RIGHTS RESERVED
 NO PART OF THIS DOCUMENT
 MAY BE REPRODUCED OR
 TRANSMITTED IN ANY FORM OR
 BY ANY MEANS, ELECTRONIC OR
 MECHANICAL, WITHOUT PERMISSION
 OF THE ARCHITECT

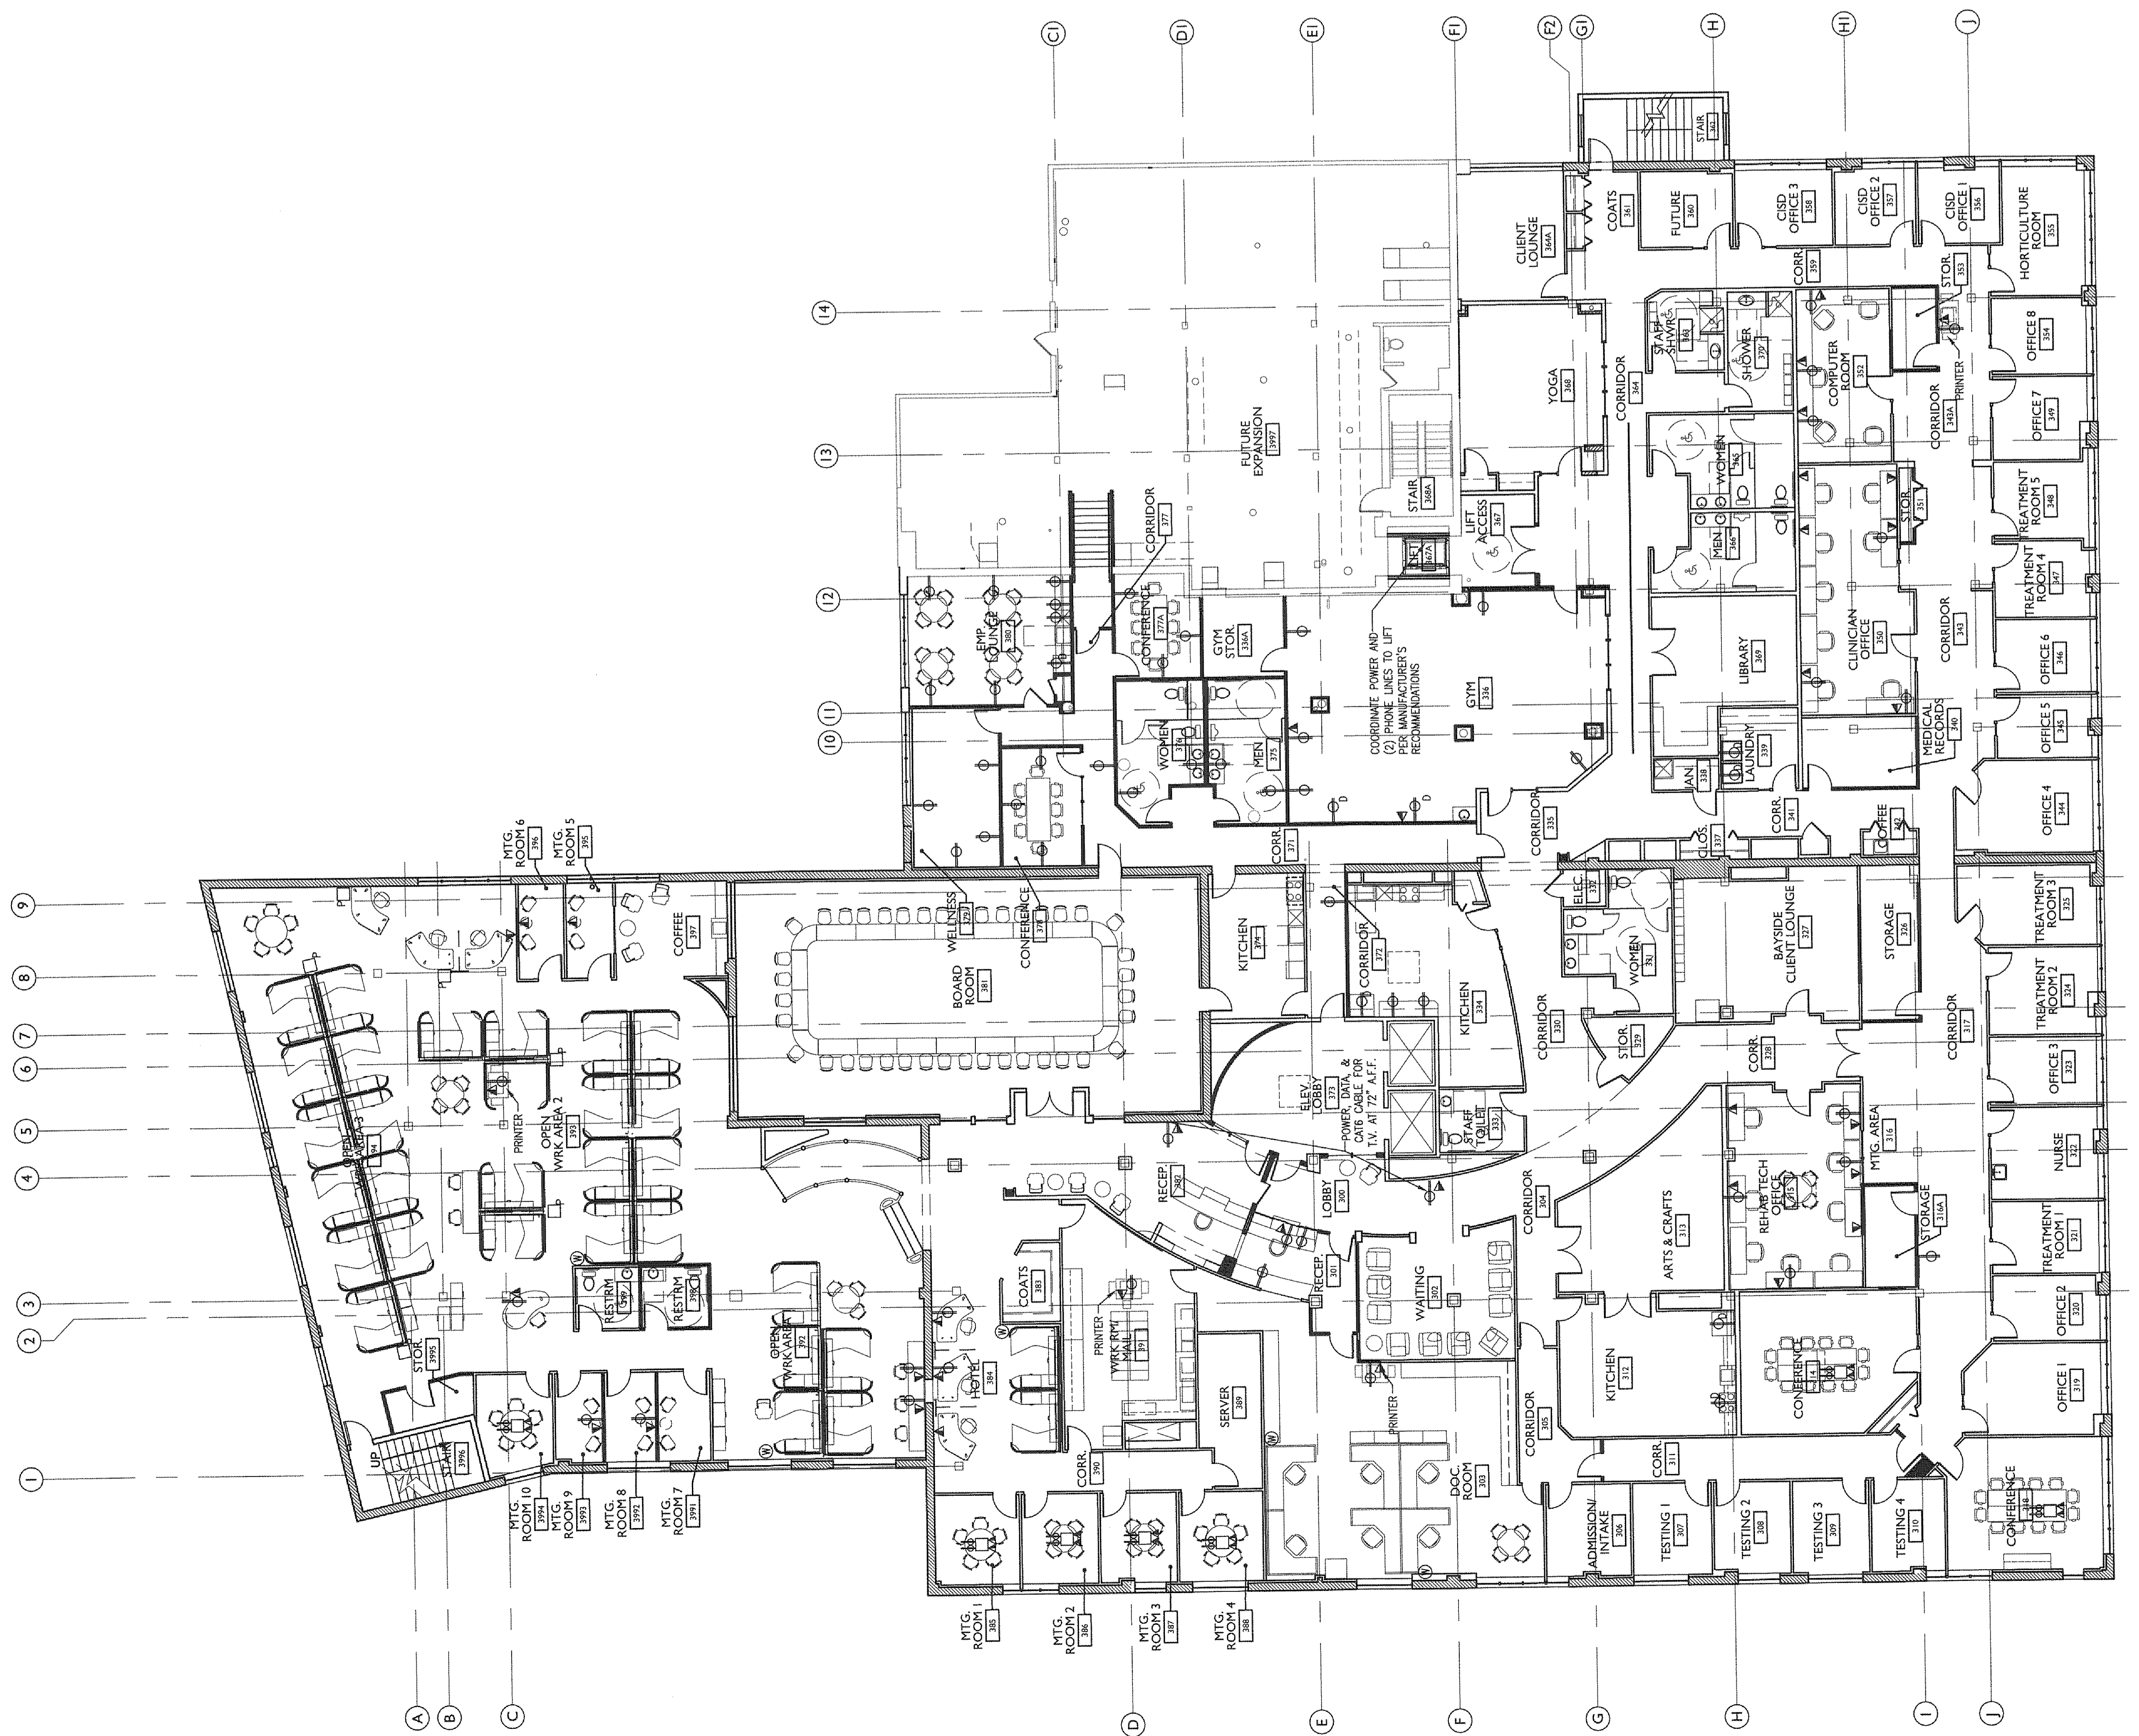

- POWER PLAN LEGEND**
- ⊕ DUPLEX OUTLET
 - ⊕ DUPLEX OUTLET, DEDICATED
 - ⊕ TEL/DATA OUTLET
 - ⊕ NEW ELECTRICAL WHP
 - ⊕ POWER POLE
 - ⊕ FLOOR BOX - 2 POWER, 2 DATA
1. CORNER THAT ALL EXISTING POWER AND DATA IS IN WORKING ORDER
 2. PROVIDE POWER TO TENANT SUPPLIED SECURITY SYSTEM
 3. REFER TO EX200 FOR EXISTING CONDITION POWER PLAN
 4. COORDINATE LOCATION OF OWNERS SUPPLIED DVNA VISION MONITOR W/ TENANT

AI THIRD FLOOR POWER PLAN

A15 LEGEND / NOTES

A18 NOT USED

322'-11 1/2" 2 3 4 5 6 7 8 9 10 11 12 13 14 15 16 17 18 19 20 21 22 23 24