

Gawron
Turgeon
ARCHITECTS

75 Black Point Road
Portland, ME 04106
www.gawronturgeon.com
207.883.6397 or 207.883.6396 fax

GOODWILL INDUSTRIES
75 WASHINGTON AVENUE - THIRD FLOOR
PORTLAND, MAINE

#	DATE	DESCRIPTION
1	08.31.13	PERMIT SET


DATE	08.31.13
PROJECT #	07011
DRAWN BY:	DLP
CHECKED BY:	NET
DRAWING SCALE	AS NOTED

SHEET TITLE
THIRD FLOOR REFLECTED CEILING PLAN

A300

© COPYRIGHT 1995-2001
ALL RIGHTS RESERVED
THIS DOCUMENT IS THE PROPERTY OF
GAWRON TURGEON ARCHITECTS & ASSOCIATES

NI15 NOT USED

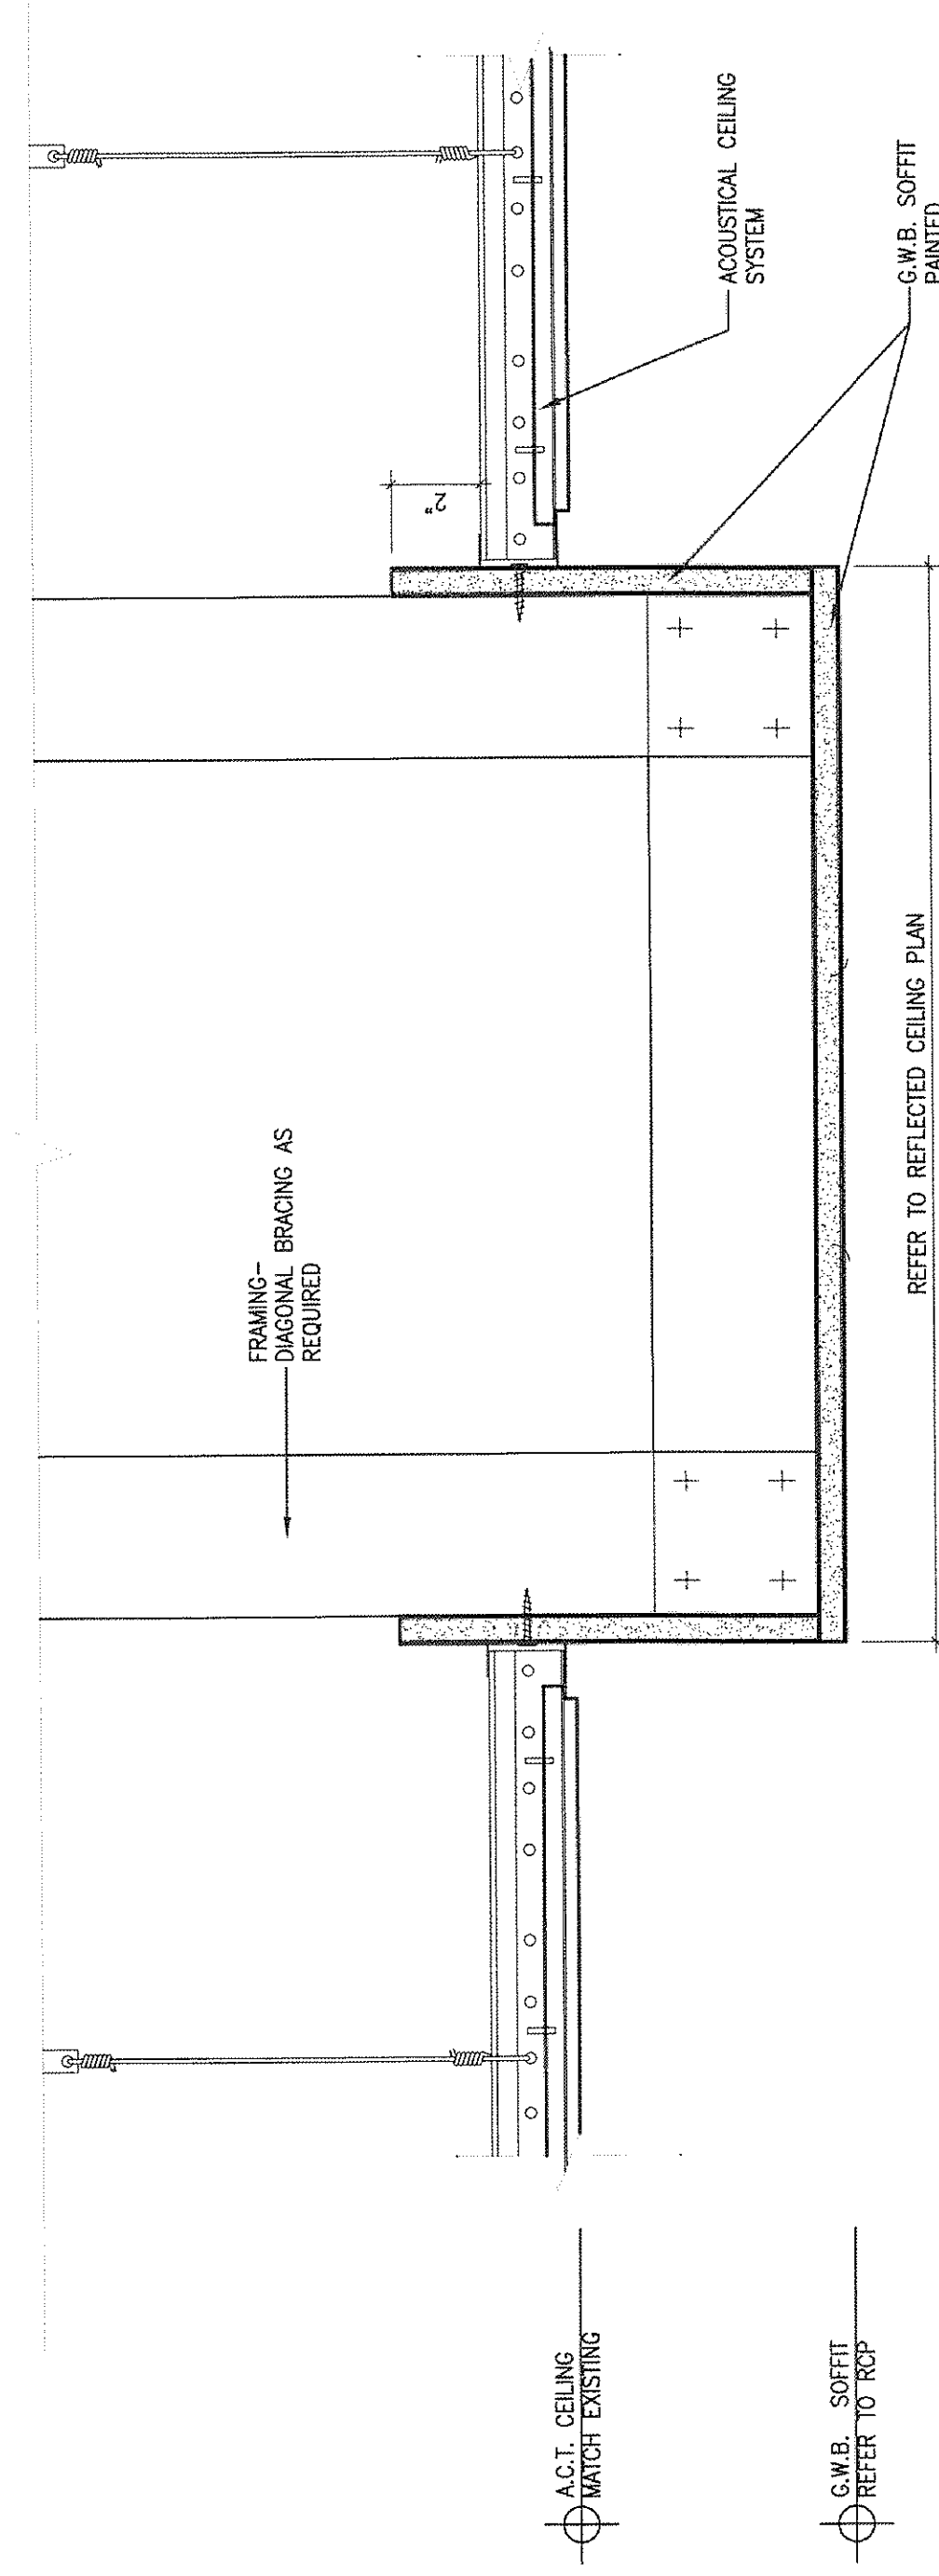

E15 SOFFIT DETAIL

3/8"=1'-0"


LIGHT FIXTURE LEGEND

- 16" DIAMETER INDUSTRIAL LIGHTING MATCH EXISTING FOR USE IN FUTURE LABORATORY PENDULITE-LED PENDANT, #1270/4248-70 WAT
- RECESSED FLUORESCENT LIGHT
- RELOCATED 2'x4' LIGHT FIXTURE APPROX. 28" AVAILABLE TO BE RELOCATED
- UNDER-CABINET LIGHTING
- ACT - CEILING TILE TO MATCH EXISTING TILE INSTALLED ON THIRD

GENERAL NOTES

1. SALVAGE AND REUSE 2'x4' PARABOLIC LIGHT FIXTURES - RELAMP AS NECESSARY. VERIFY CONDITION OF BALLASTS.
2. RELOCATE EXISTING FIXTURE
3. MOVE EXISTING FIXTURE PER PLAN
4. INDEPENDENTLY SWITCH ALL OFFICES, MEETING ROOMS, AND CONFERENCE ROOMS.
5. ELECTRICAL SERVICE AND NFPA LIFE SAFETY BY DESIGN BUILD ELECTRICAL CONTRACTOR
6. PROVIDE HARDWARE CONNECTIONS TO TENANT SUPPLIED FURNITURE.

1. CHANGE WALL WASHER TO A NEW RECESSED FLUORESCENT FIXTURE
2. RELOCATE EXISTING FIXTURE
3. MOVE EXISTING FIXTURE PER PLAN
4. OWNER SUPPLIED, CM TO INSTALL REFER TO DETAILS FOR UNISTRUT AND HEADER
5. PATCH/REPAIR G.W.B. SOFFIT AS NEEDED DUE TO DEMO/CONSTRUCTION

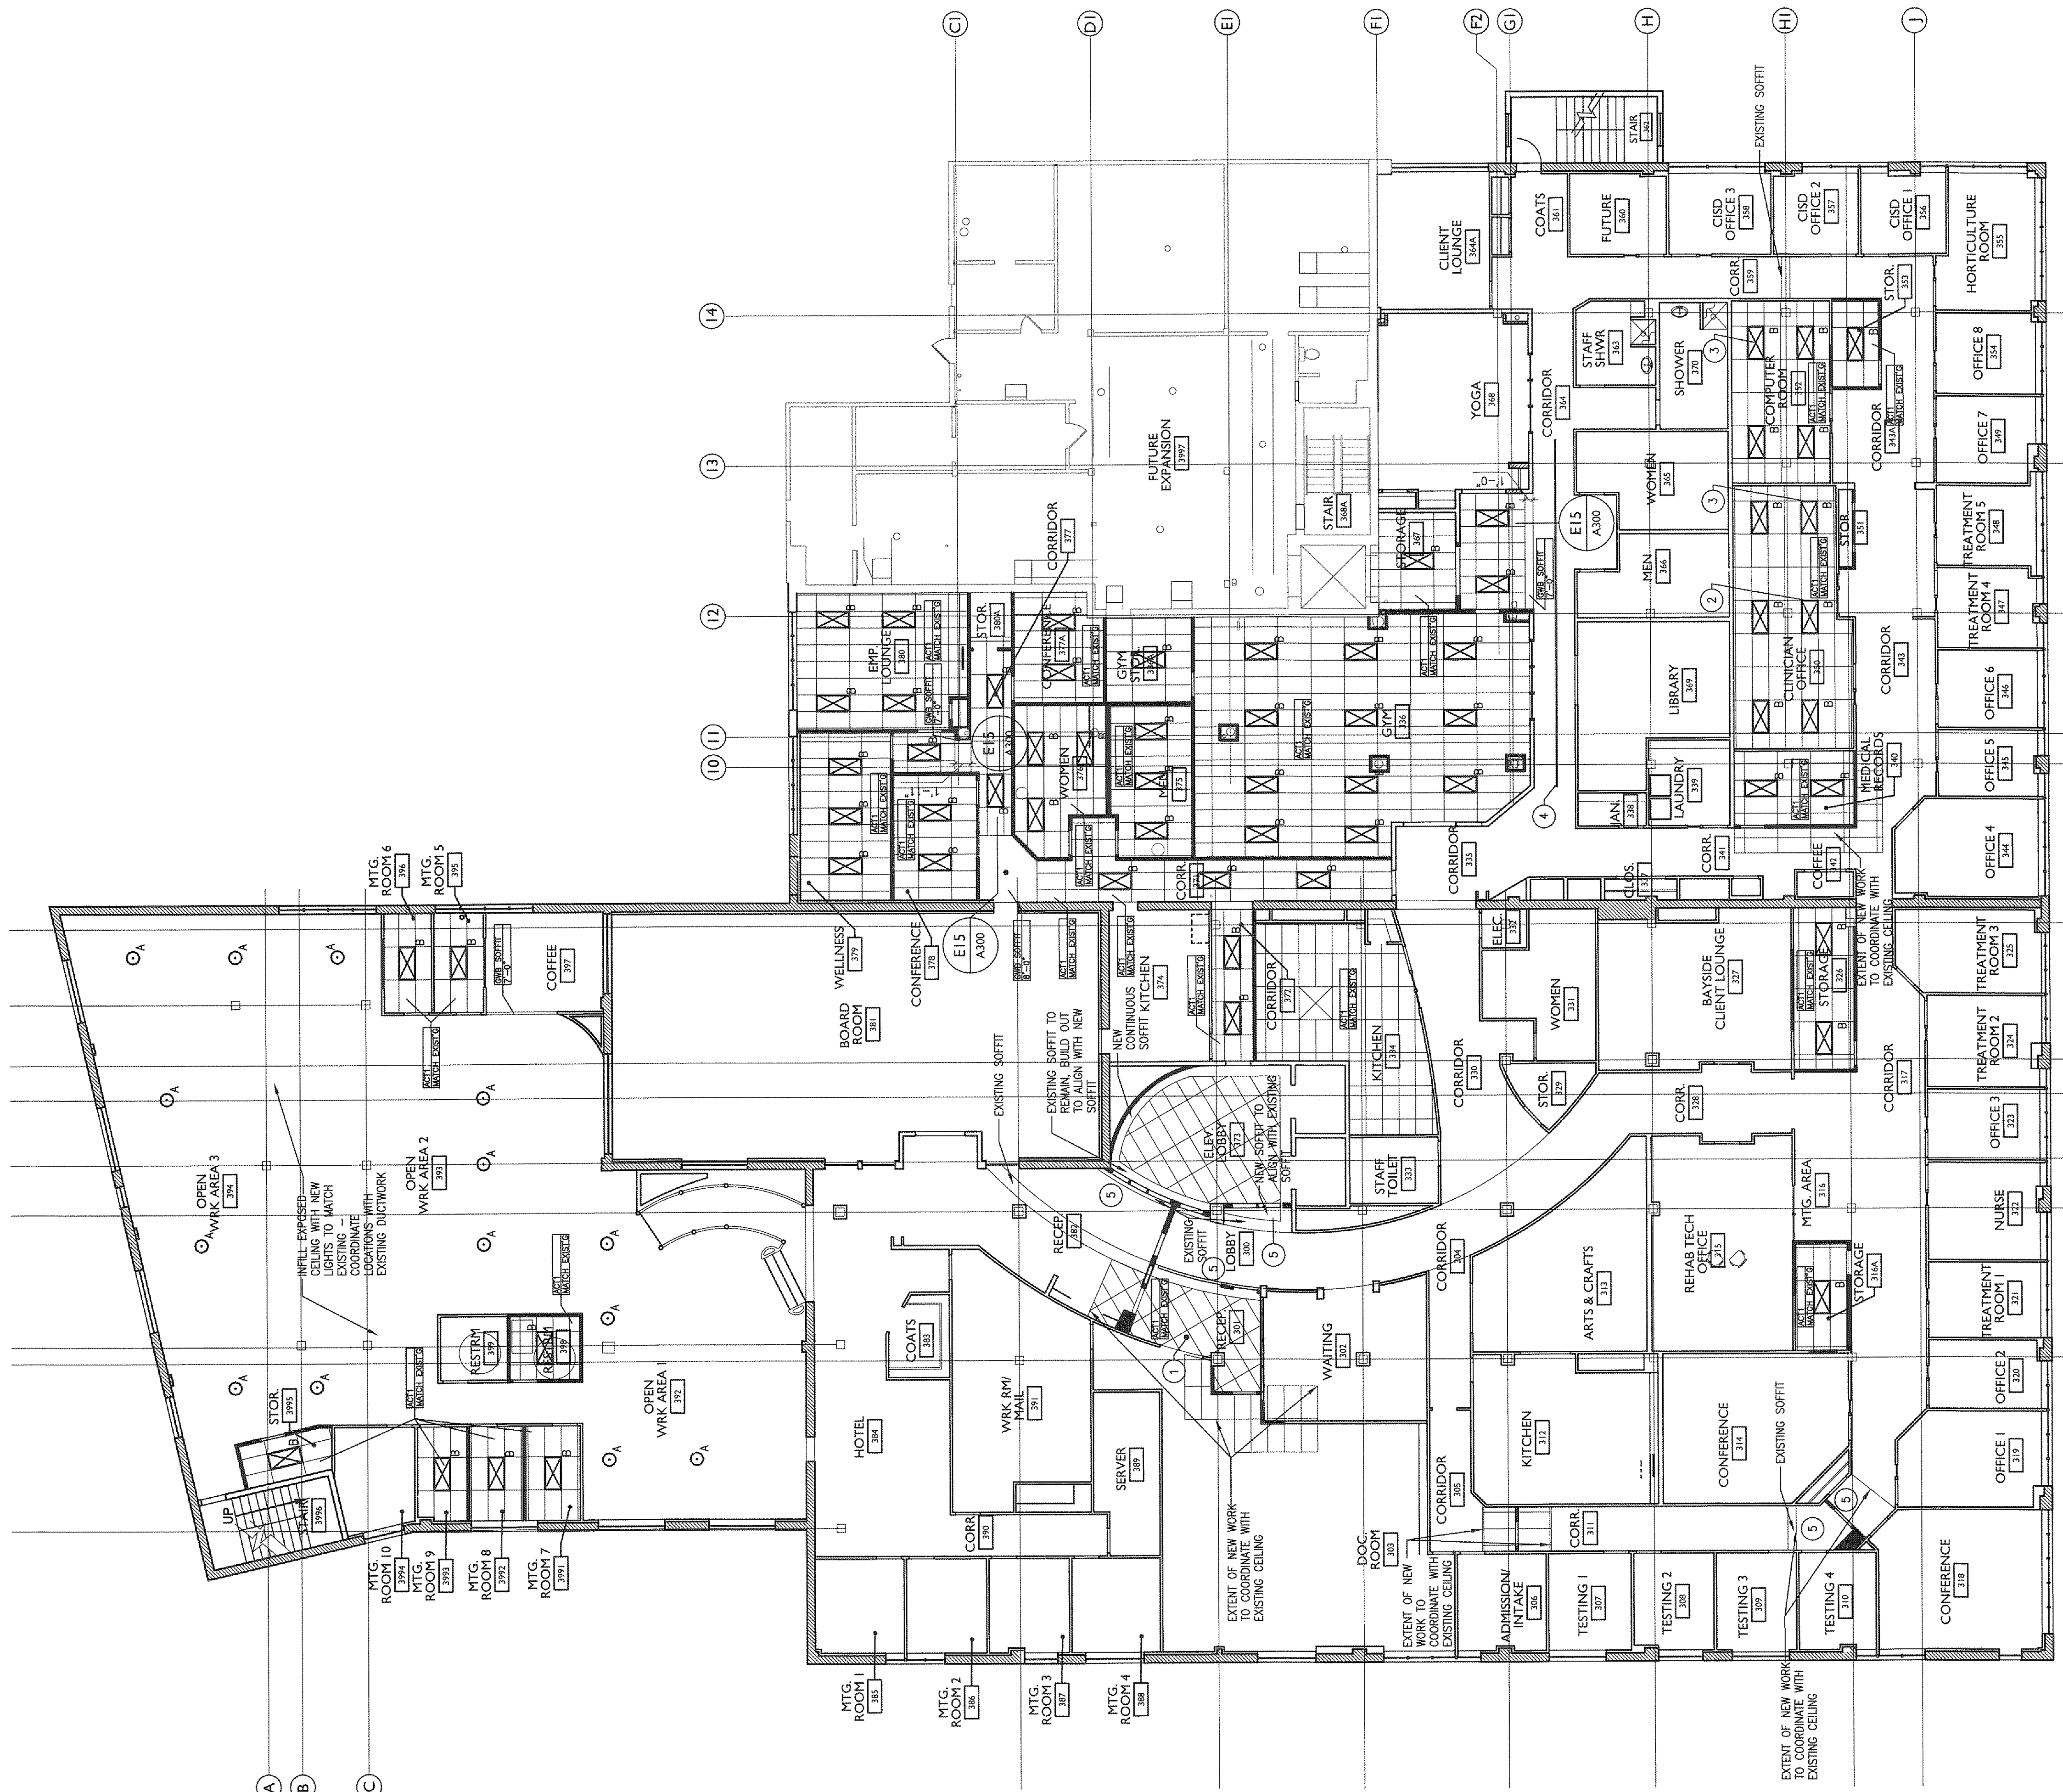

A1 THIRD FLOOR REFLECTED CEILING PLAN



A15 LIGHTING LEGEND AND NOTES

DATE: 08.31.13
SCALE: 3/8"=1'-0"