



© 2014 RYAN SENATORE ARCHITECTURE

RESTAURANT FIT-UP
75 WASHINGTON AVENUE
PORTLAND, MAINE



RYAN SENATORE
ARCHITECTURE
565 CONGRESS STREET
SUITE 304
PORTLAND, MAINE 04101
207-650-6414
senatorearchitecture.com

CONSULTANTS:

REVISIONS:

DATE: OCTOBER 17, 2014

PROJECT No. 1437

DRAWN BY:


CHECKED BY: RJS

SCALE: AS NOTED

SHEET TITLE:

REFLECTED
CEILING PLAN

A1-2

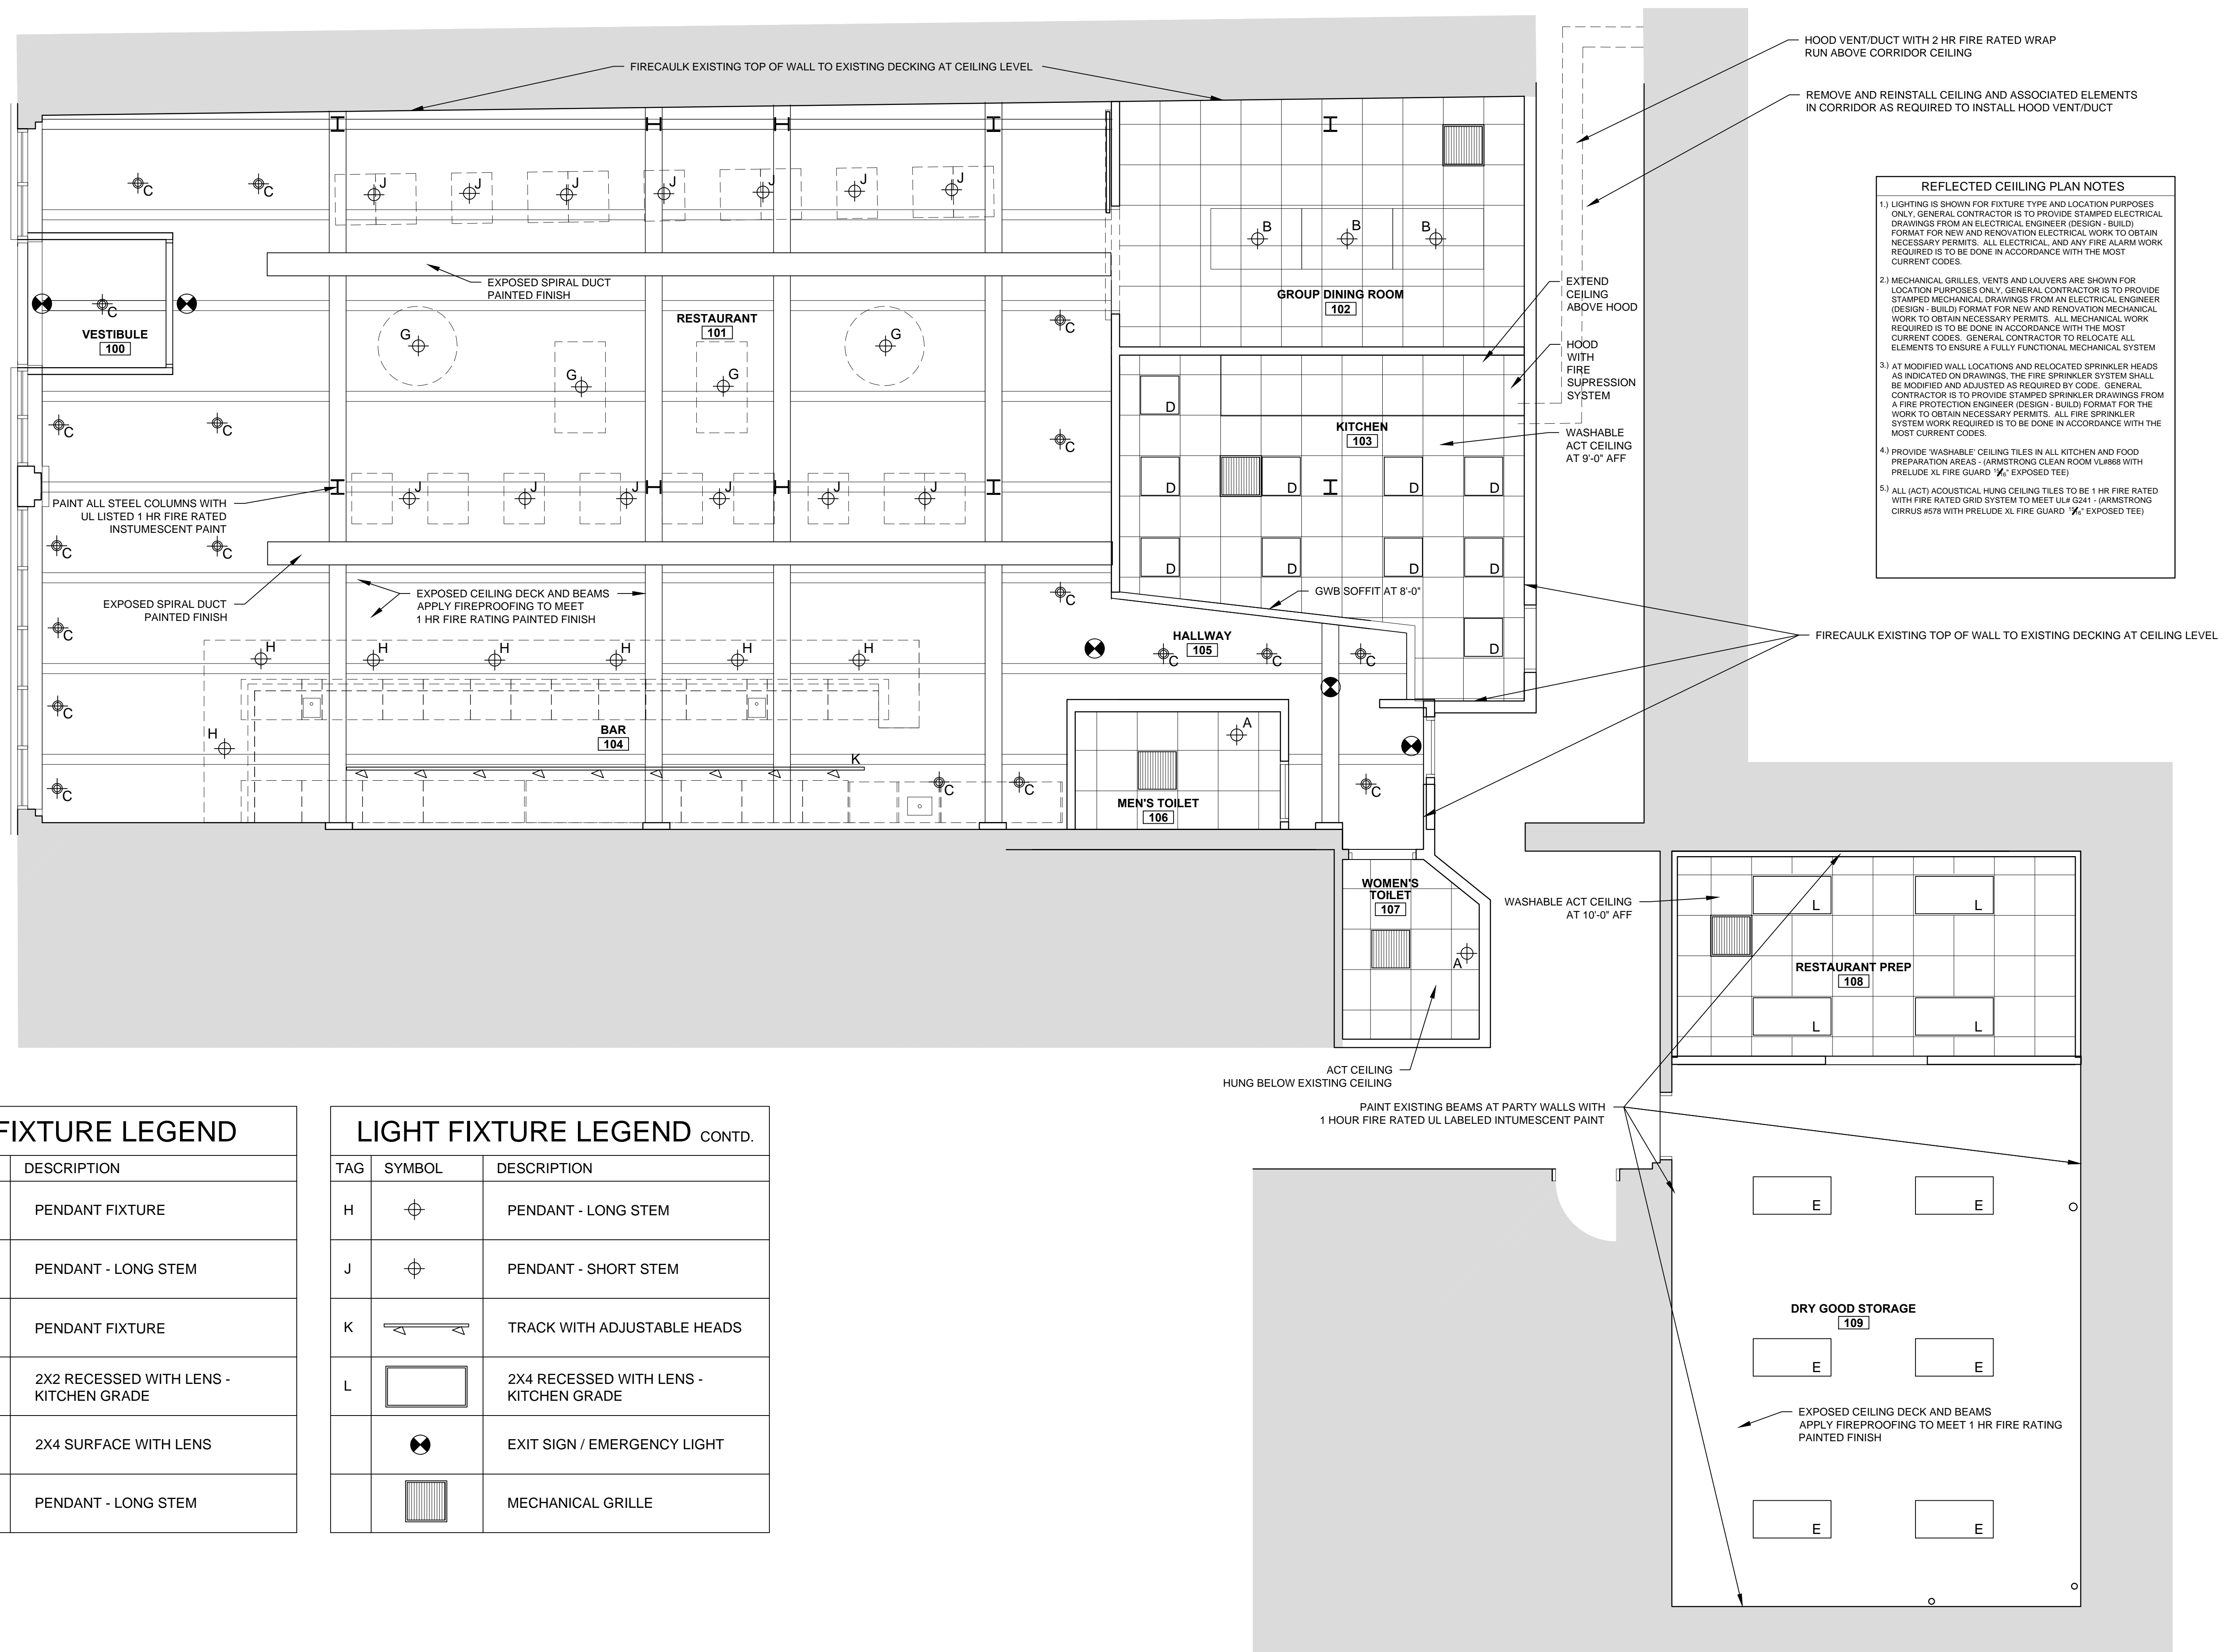

REFLECTED CEILING PLAN NOTES

- 1) LIGHTING IS SHOWN FOR FIXTURE TYPE AND LOCATION PURPOSES ONLY. GENERAL CONTRACTOR IS TO PROVIDE STAMPED ELECTRICAL DRAWINGS FROM AN ELECTRICAL ENGINEER (DESIGN - BUILD) FORMAT FOR NEW AND RENOVATION ELECTRICAL WORK TO OBTAIN NECESSARY PERMITS. ALL ELECTRICAL AND ANY FIRE ALARM WORK REQUIRED IS TO BE DONE IN ACCORDANCE WITH THE MOST CURRENT CODES.
- 2) MECHANICAL GRILLES, VENTS AND LOUVERS ARE SHOWN FOR LOCATION PURPOSES ONLY. GENERAL CONTRACTOR IS TO PROVIDE STAMPED MECHANICAL DRAWINGS FROM AN ELECTRICAL ENGINEER (DESIGN - BUILD) FORMAT FOR NEW AND RENOVATION MECHANICAL WORK TO OBTAIN NECESSARY PERMITS. ALL MECHANICAL WORK REQUIRED IS TO BE DONE IN ACCORDANCE WITH THE MOST CURRENT CODES. GENERAL CONTRACTOR TO RELOCATE ALL ELEMENTS TO ENSURE A FULLY FUNCTIONAL MECHANICAL SYSTEM.
- 3) AT MODIFIED WALL LOCATIONS AND RELOCATED SPRINKLER HEADS AS INDICATED ON DRAWINGS, THE FIRE SPRINKLER SYSTEM SHALL BE MODIFIED AND ADJUSTED AS REQUIRED BY CODE. GENERAL CONTRACTOR IS TO PROVIDE STAMPED SPRINKLER DRAWINGS FROM A FIRE PROTECTION ENGINEER (DESIGN - BUILD) FORMAT FOR THE WORK TO OBTAIN NECESSARY PERMITS. ALL FIRE SPRINKLER SYSTEM WORK REQUIRED IS TO BE DONE IN ACCORDANCE WITH THE MOST CURRENT CODES.
- 4) PROVIDE 'WASHABLE' CEILING TILES IN ALL KITCHEN AND FOOD PREPARATION AREAS - (ARMSTRONG CLEAN ROOM VL4868 WITH PRELUDE XL FIRE GUARD 'X'; EXPOSED TEE)
- 5) ALL (ACT) ACOUSTICAL HUNG CEILING TILES TO BE 1 HR FIRE RATED WITH FIRE RATED GRID SYSTEM TO MEET L1E Q241 - (ARMSTRONG CIRRUS #578 WITH PRELUDE XL FIRE GUARD 'X'; EXPOSED TEE)

LIGHT FIXTURE LEGEND		
TAG	SYMBOL	DESCRIPTION
A	⊕	PENDANT FIXTURE
B	⊕	PENDANT - LONG STEM
C	⊕	PENDANT FIXTURE
D	□	2X2 RECESSED WITH LENS - KITCHEN GRADE
E	▭	2X4 SURFACE WITH LENS
G	⊕	PENDANT - LONG STEM

LIGHT FIXTURE LEGEND CONTD.		
TAG	SYMBOL	DESCRIPTION
H	⊕	PENDANT - LONG STEM
J	⊕	PENDANT - SHORT STEM
K	⎯⎯⎯	TRACK WITH ADJUSTABLE HEADS
L	▭	2X4 RECESSED WITH LENS - KITCHEN GRADE
	⊙	EXIT SIGN / EMERGENCY LIGHT
	▭	MECHANICAL GRILLE

1 REFLECTED CEILING PLAN
1/4" = 1'-0"