

REVISION	DESCRIPTION	DATE
0	ISSUED FOR REVIEW & APPROVAL	10/14/2016


RESERVED FOR CITY STAMP

CUNNINGHAM
 Security Systems
 10 Princes Point Road, Yarmouth, Maine 04096
 Office: 207.846.3350 • Fax: 207.846.6080

SPOTME T1
75 WASHINGTON AVENUE
PORTLAND, MAINE 04101
FIRE ALARM PLAN

DRAWN	JPB UNICAD JOB #16809
CHECKED	WAYNE B. HAWES NCET # 90496
DATE	10/14/2016
REVISION	0
SCALE	1/8"=1'-0"

FA-2

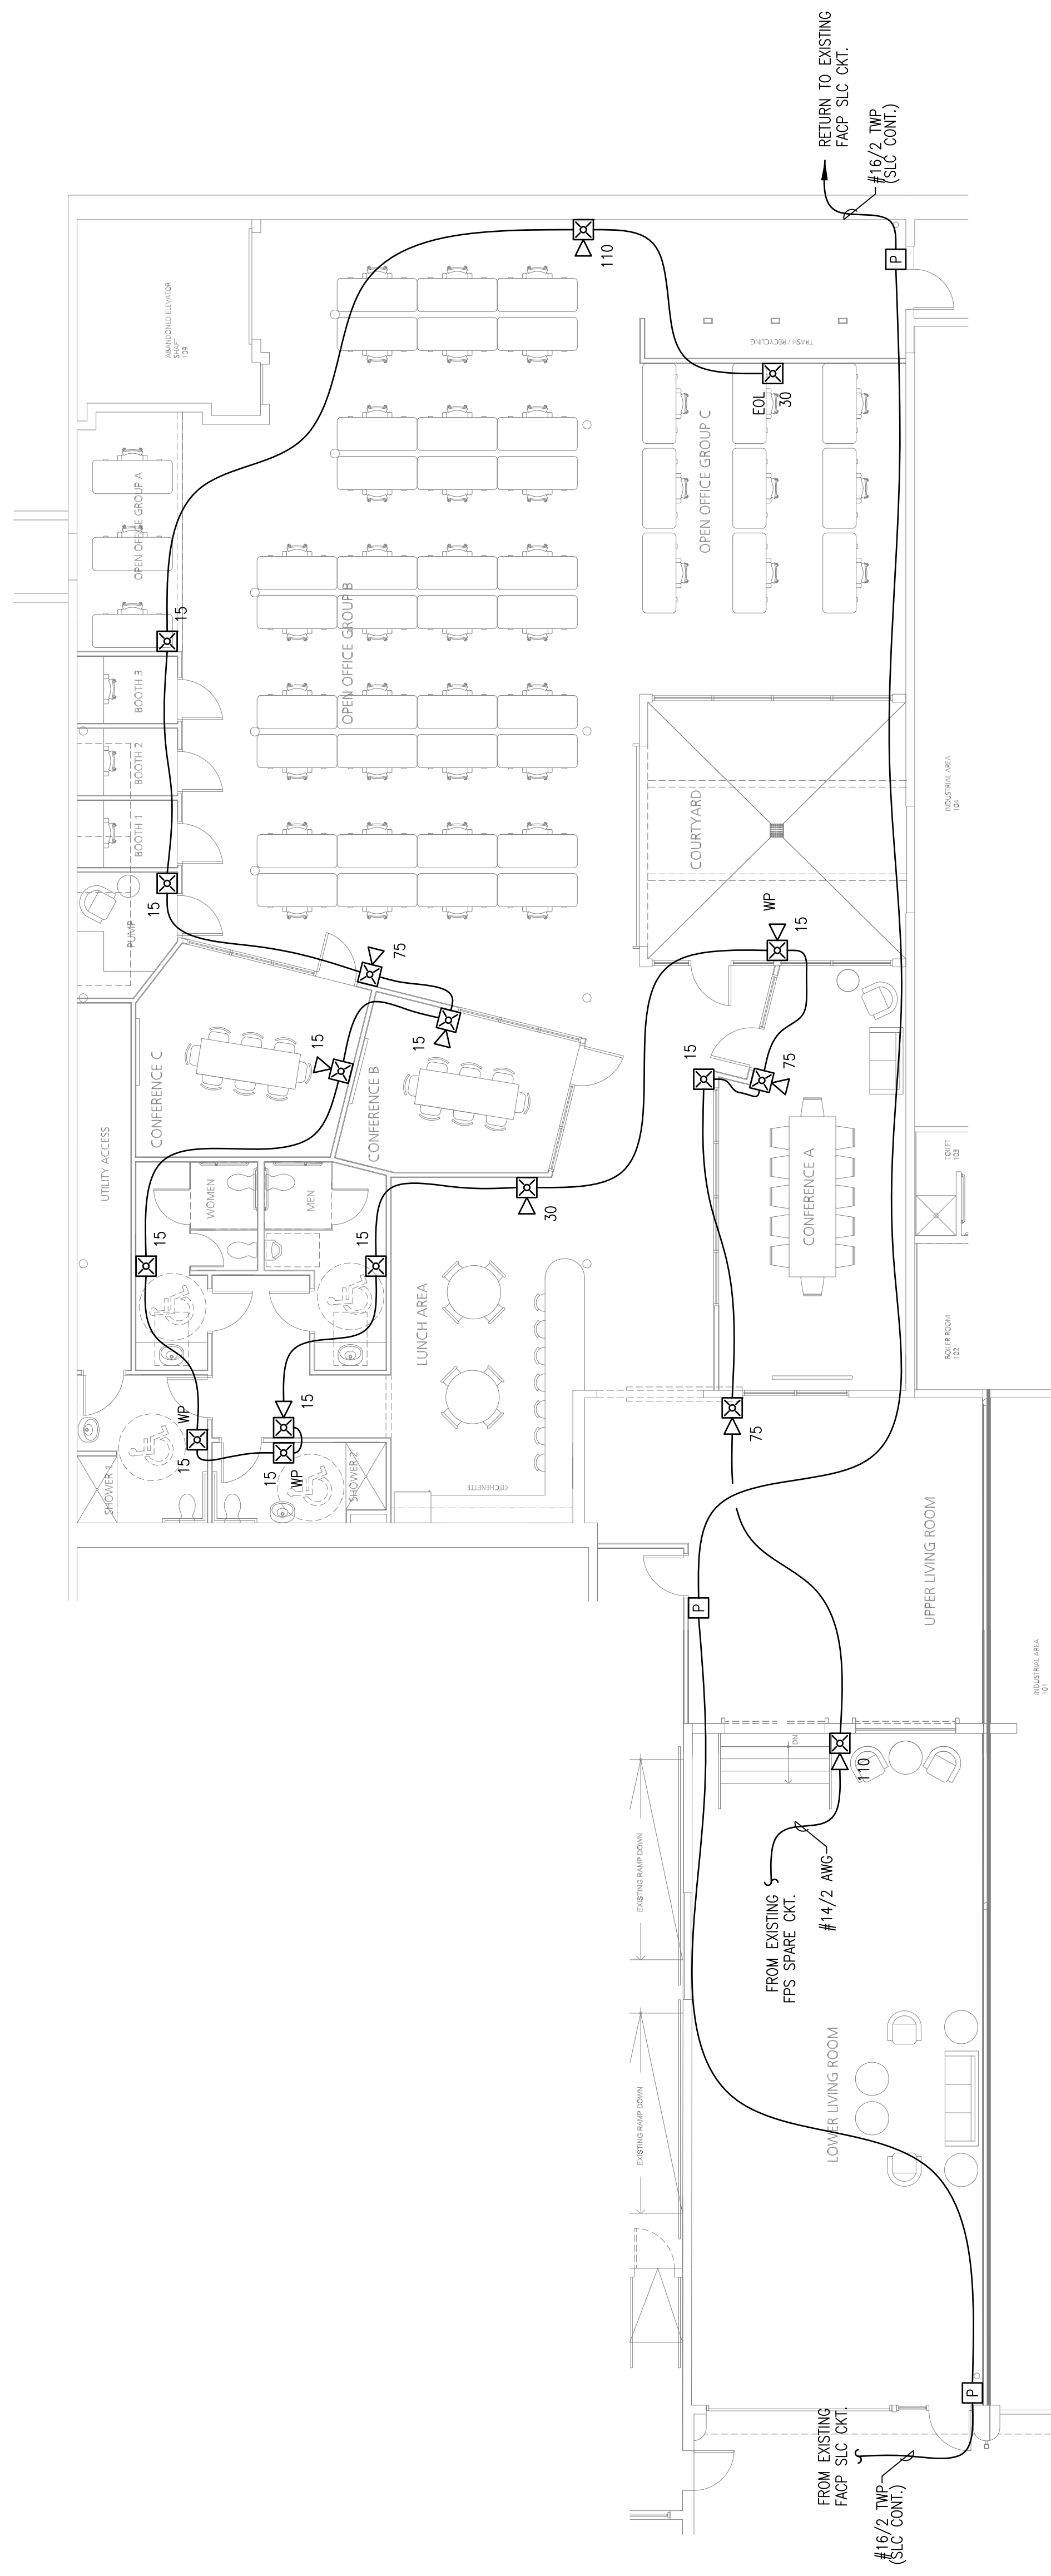

FIRE ALARM PLAN
 SCALE: 1/8"=1'-0"