


SYMBOLS	
E	EXISTING
CRD	CEILING RADIATION DAMPER
FD	FIRE DAMPER
SWR	SIDEWALL REGISTER
BOD	BOTTOM OF DUCT
AP	DUCT ACCESS PANEL
---	EXISTING DUCT
⊕	CONNECT TO EXISTING

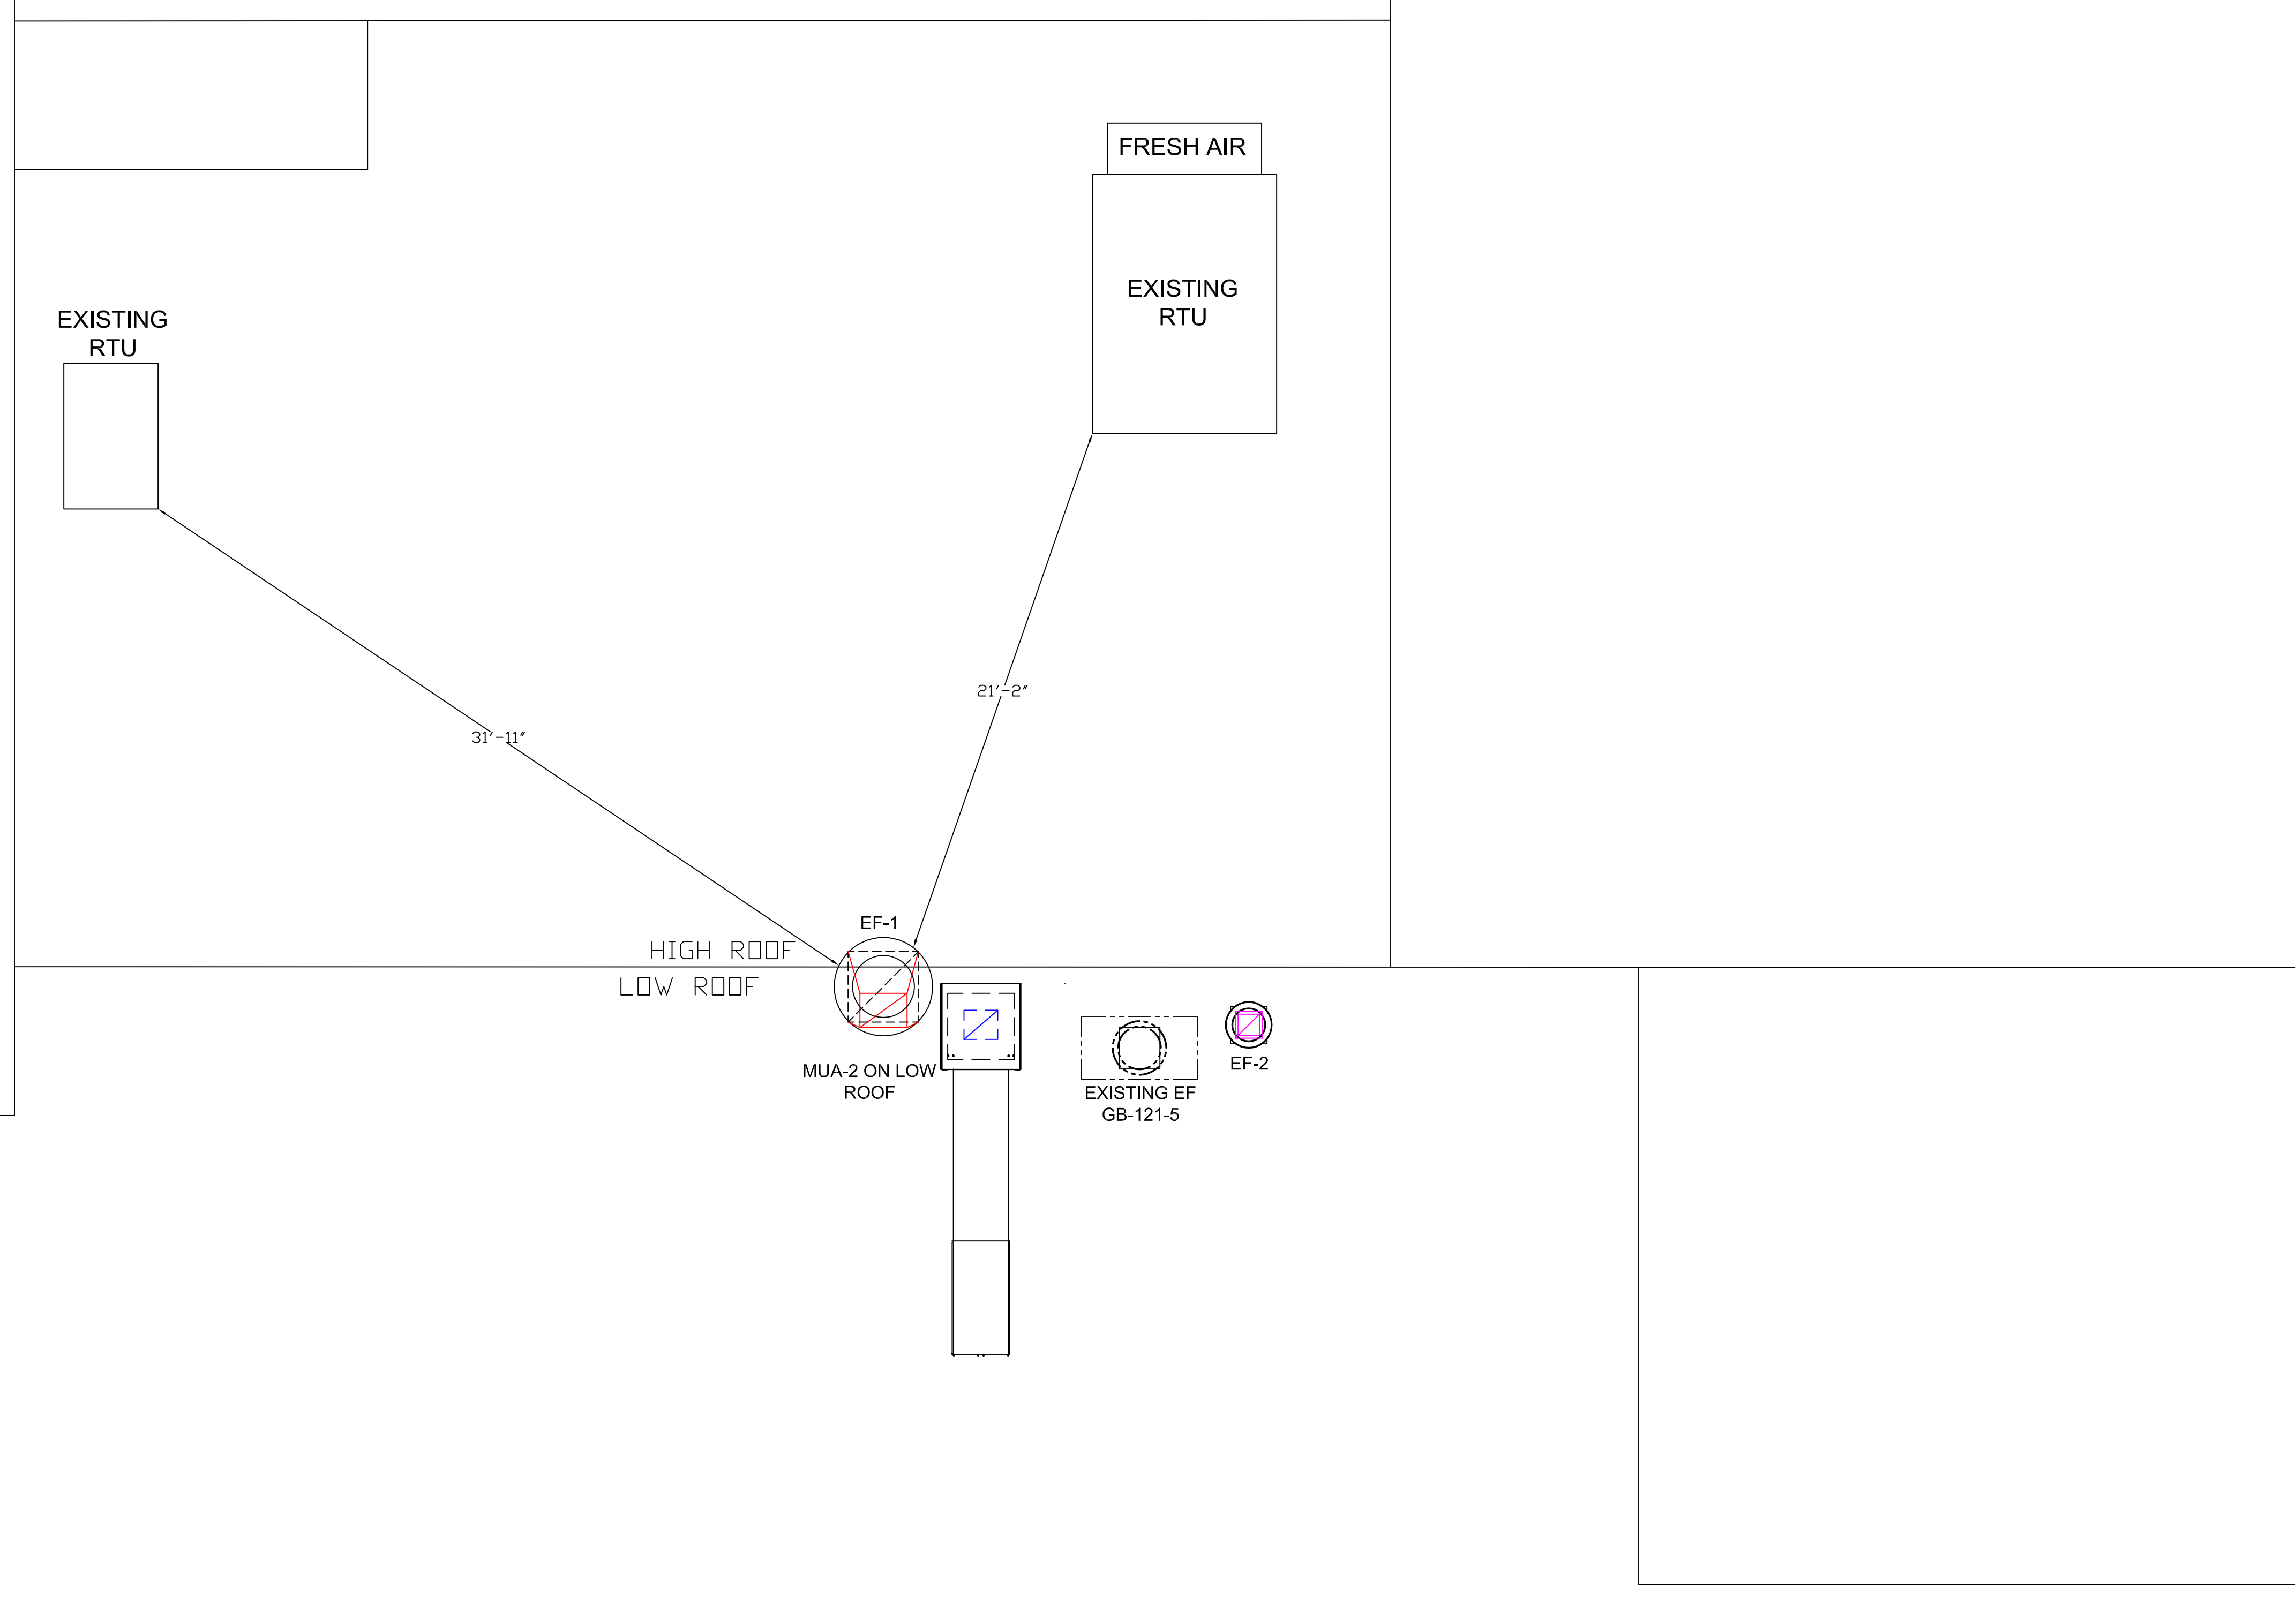

EXISTING
CONDENSER

Halley's
Metal Shop, Inc.
Since 1917



HALEY'S METAL SHOP, INC.
539 ELM STREET
BIDDEFORD, MAINE 04005
PH: 207-284-8571, FAX: 207-284-9597


DATE: 08/20/15

SCALE: 1/4"=1'-0"

**ROUSTABOUT RESTAURANT
PORTLAND, MAINE
PARTIAL ROOF PLAN**

HVAC

M-4

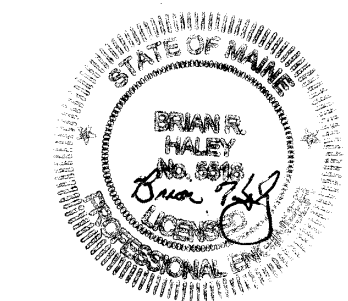

FOR CONSTRUCTION