


GENERAL CONTRACTOR ON RECORD:
 LANDMARC CONSTRUCTION
 MARC GAONON
 207-699-2572



SPECIAL APPLICATIONS:
 NO. DESCRIPTION:
 1. FIRE CAULK WALL PENETRATION WHERE REQUIRED TO MEET BUILDING SPECIFIC RATINGS.

LEGEND:
 ○ IN PIPE RISER UP
 ○ IN PIPE RISER DOWN
 ○ POSITIONED IN WELDED STEEL SYSTEM RISER
 ○ EXISTING OUTLET


DESIGN NOTES:
 ALL PIPING 1/2" & LARGER TO BE SCHEDULE 40 WITH GROOVED FITTING.
 ALL PIPING 1/4" & SMALLER TO BE SCHEDULE 40 WITH APPROPRIATE FITTING. AND USE OF SPRINKLER HEADS SHALL BE IN ACCORDANCE WITH NFPA 13. POSITION, LOCATION, SPACING, AND USE OF HANGERS SHALL BE IN ACCORDANCE WITH NFPA 13. HIGH TEST FIRE PROTECTION IS TO BE IN WORK AT EXISTING PIPING INSIDE THE BUILDING. DIMENSIONS AND LOCATIONS GIVEN FOR SPRINKLER ACTUAL FIELD CONDITIONS TO ACCOMMODATE OWNER TO PROVIDE ADEQUATE HEAT THROUGHOUT BUILDING TO PREVENT PROPERTY DAMAGE AND ALL MECHANICAL, ELECTRICAL AND PLUMBING TRAVELS TO OCCUR WITHIN THE BUILDING. ALL ELEVATION WORK IS TO BE DONE BY OTHERS.
 HEAD LEGEND:
 GLOBE
 MODEL QLS5601
 14 7/16" K=5.6
 155' MAX SPACING= 196 SQ FT
 200' MAX SPACING= 110 SQ FT
 GLOBE
 MODEL QLS5615
 31 7/16" K=5.6
 1/2" BRASS UPRIGHT DEFLECTION SPRINGS 2" BELOW WOOD CEILING
 155' MAX SPACING= 196 SQ FT
 200' MAX SPACING= 110 SQ FT
 GLOBE
 MODEL QLS535
 14 7/16" K=5.6
 1/2" WHITE DRY PENDENT MAX SPACING= 130 SQ FT

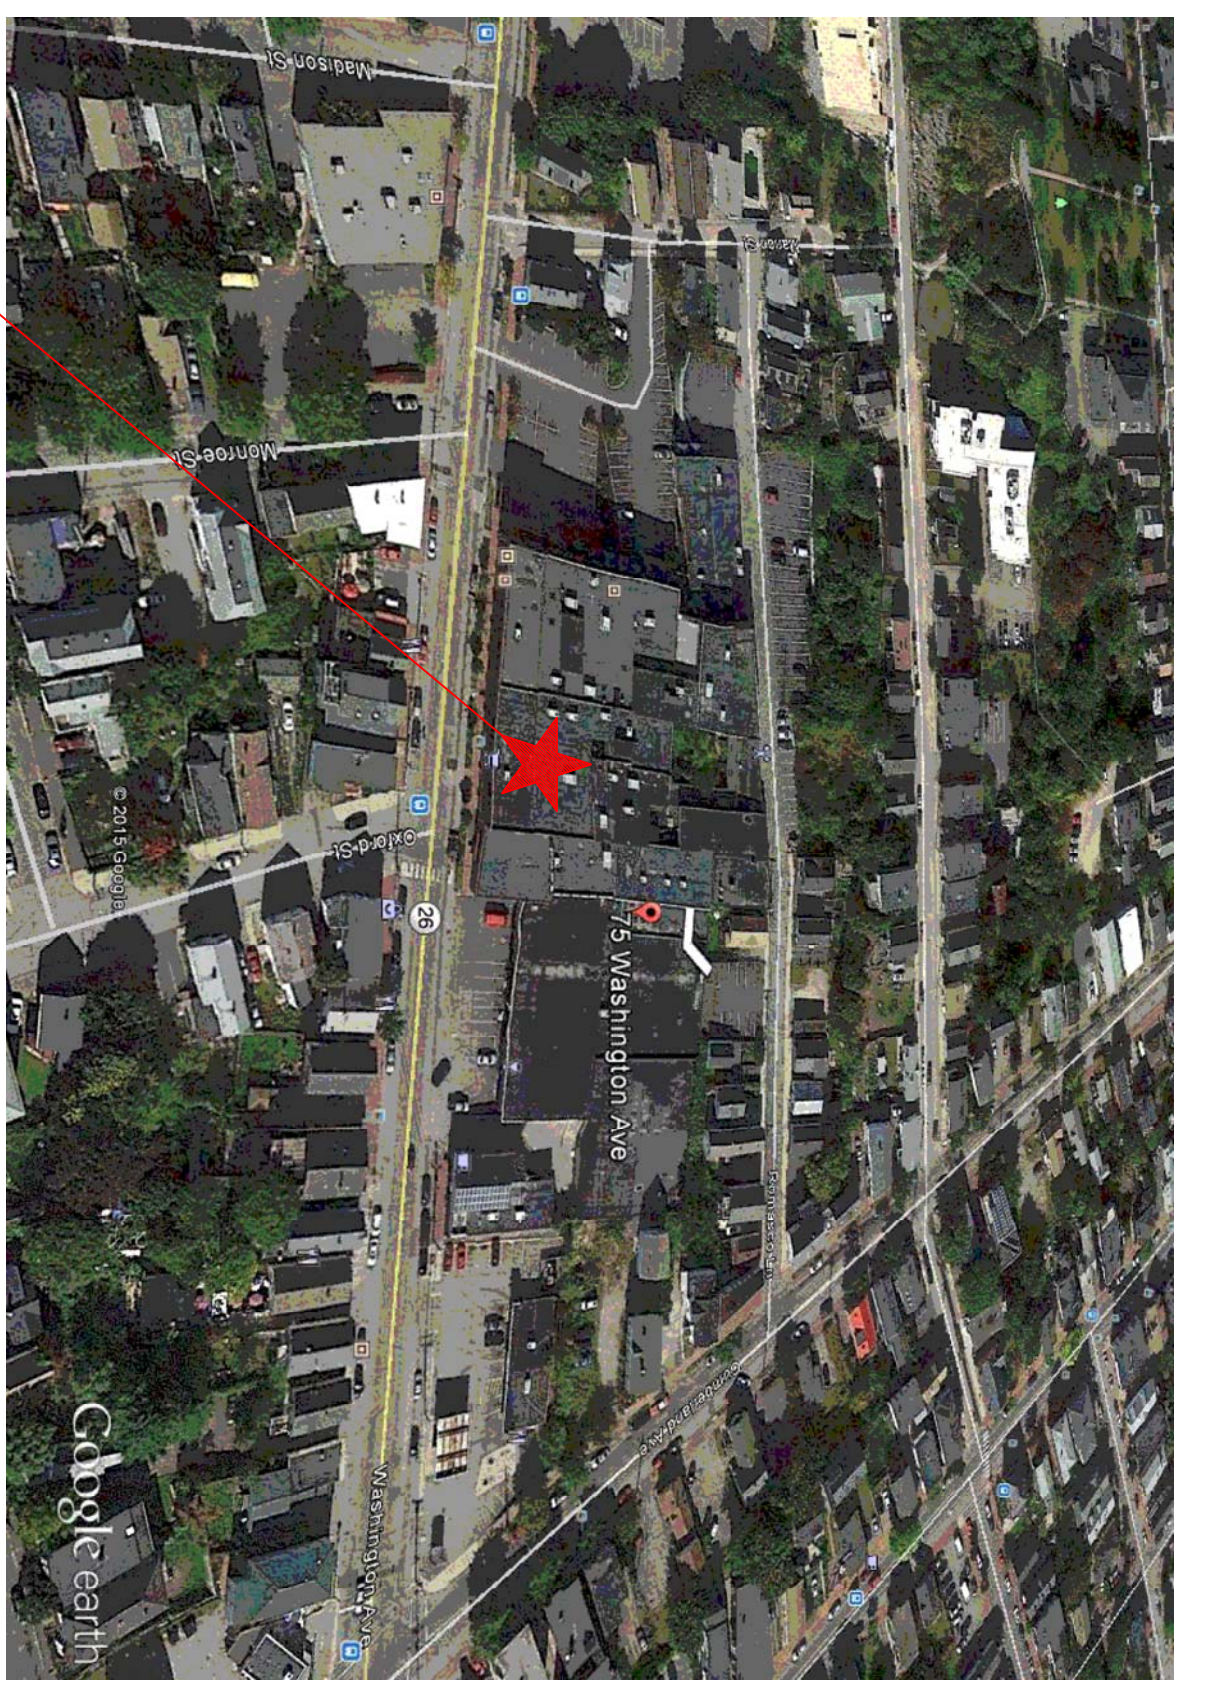

Plot Plan
 SCALE: NTS

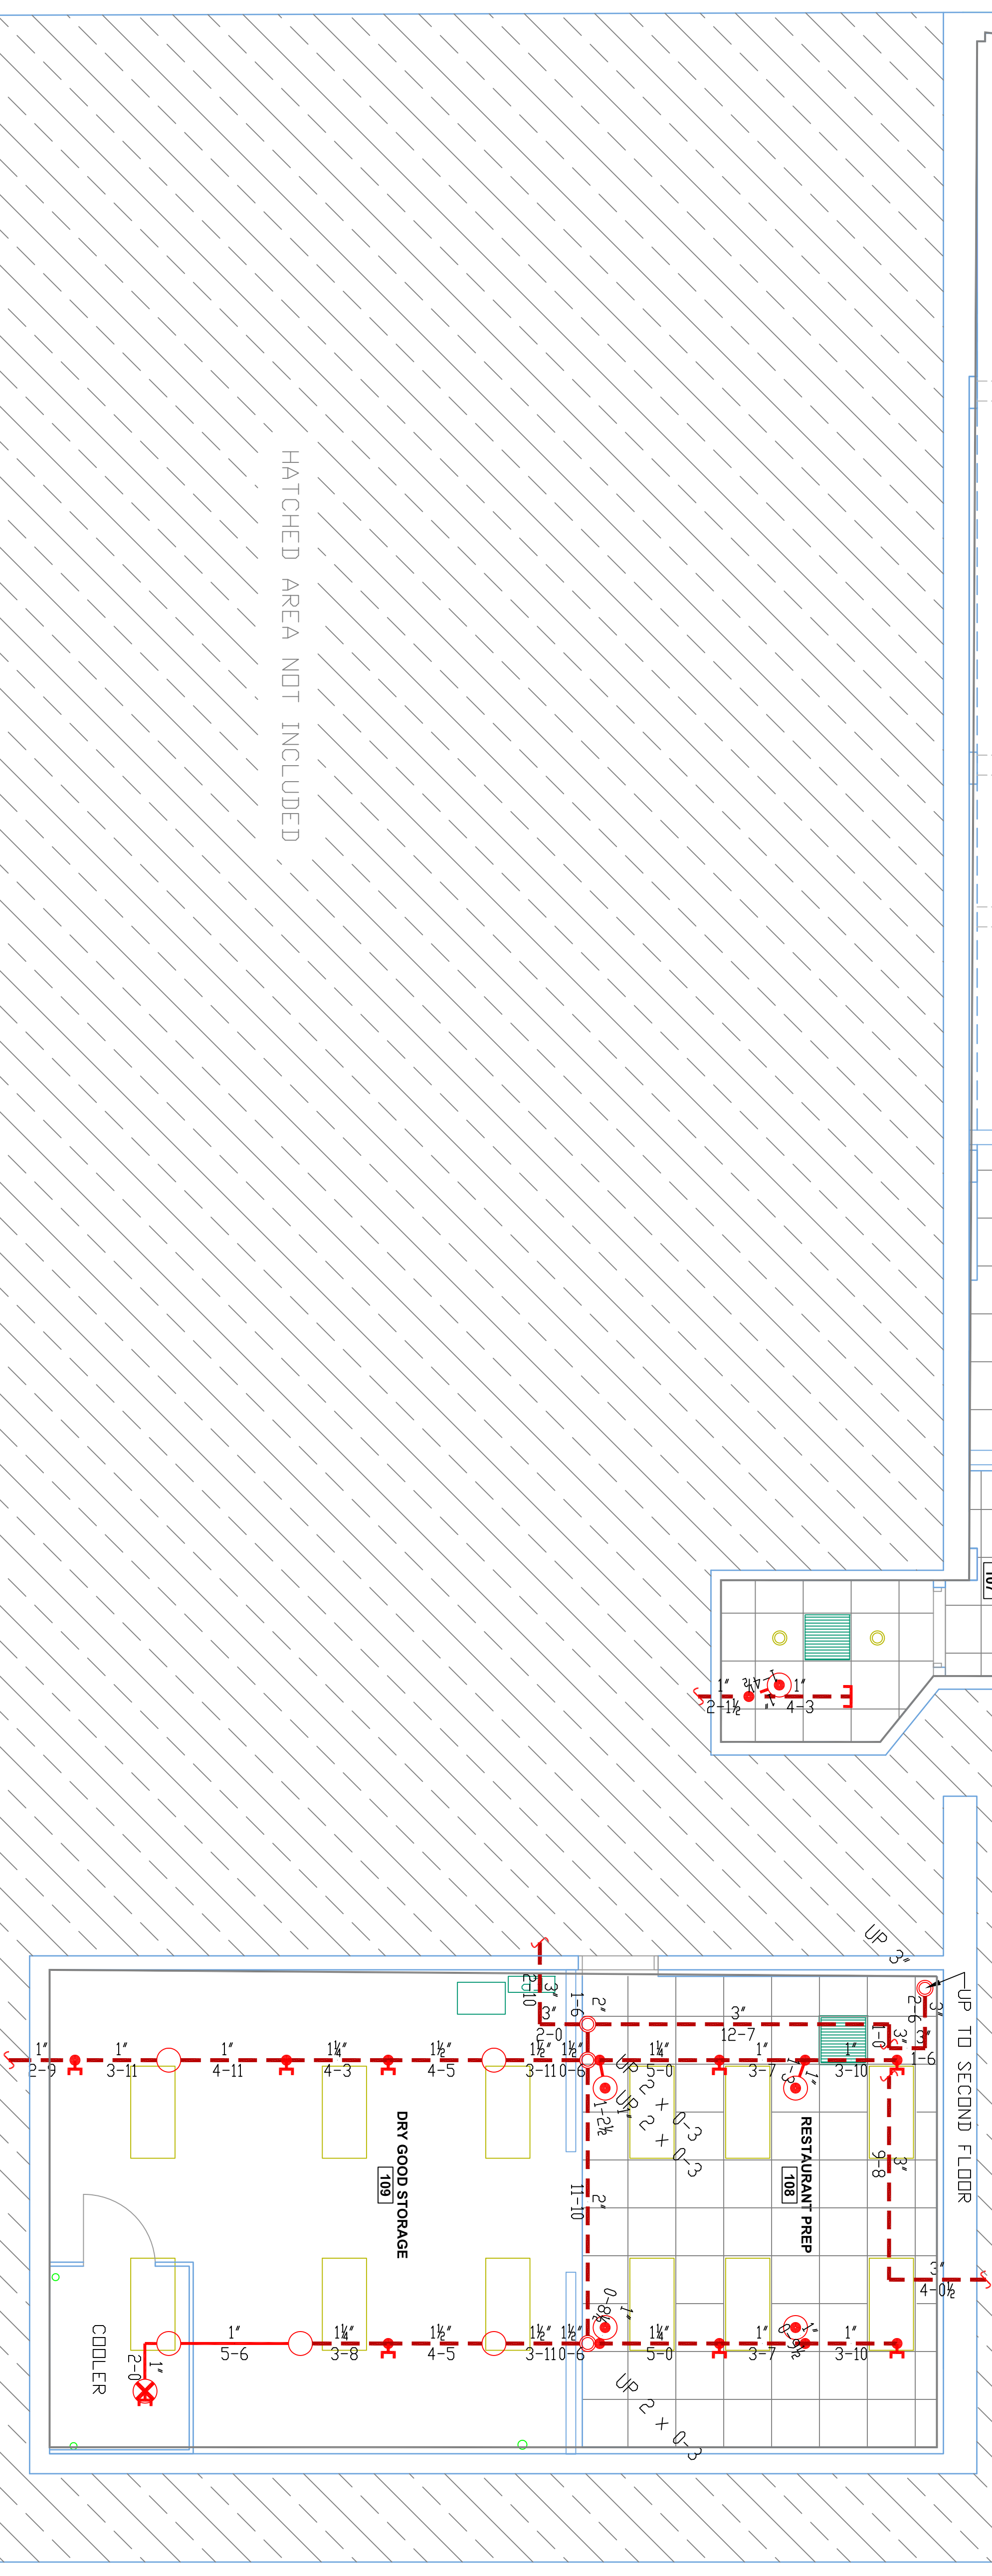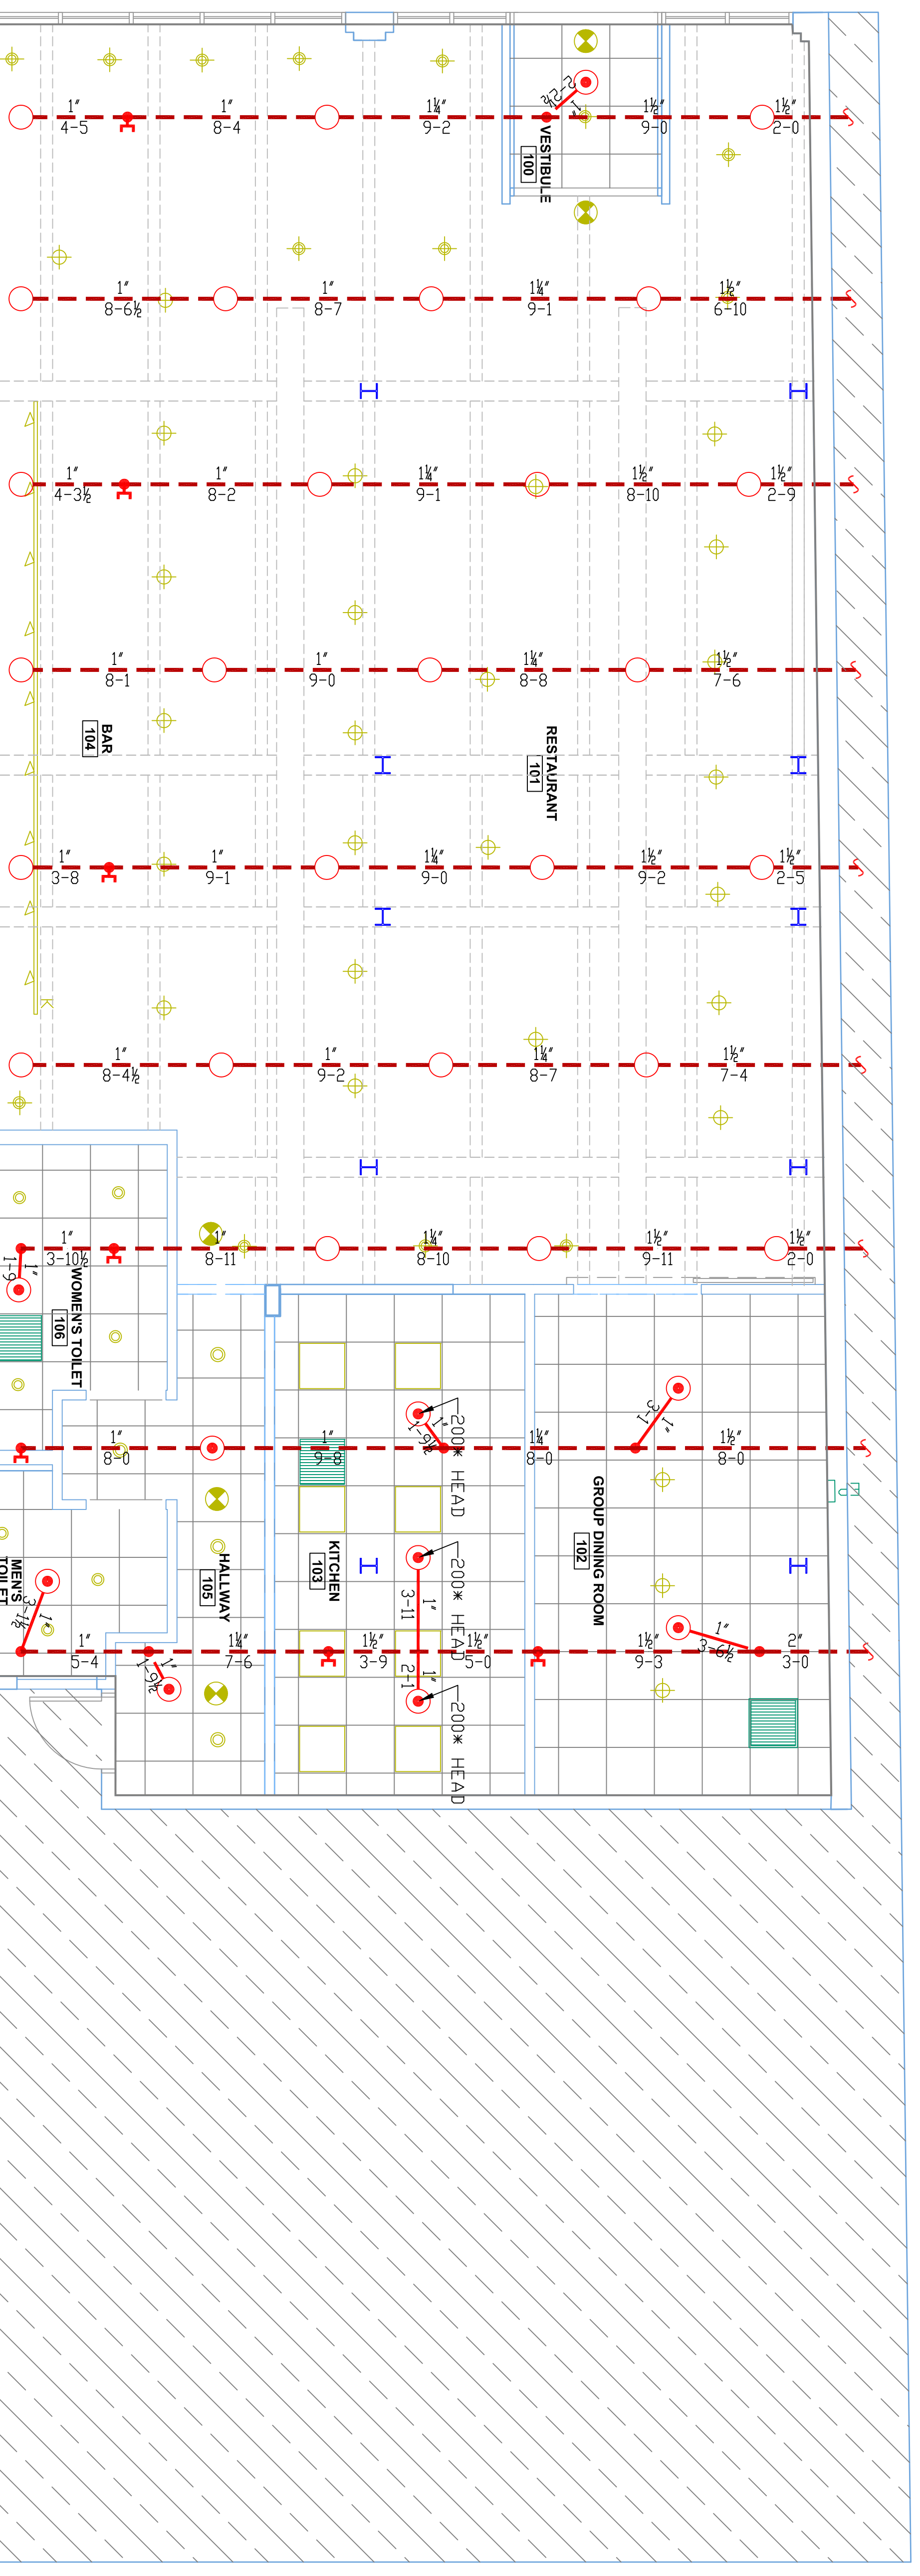

PROJECT DESCRIPTION
 BUILDING CONST.:
 THE AREA OF DESIGN IS 1 LEVEL AND IS CONSTRUCTED OF WOOD, BRICK AND CONCRETE. STEEL PIPING THROUGHOUT.
 BUILDING OCCUPANCY:
 THE KITCHEN AND PREP AREAS ARE DESIGNED AS A LIGHT HAZARD. THE REMAINING TENANT SPACE IS LIGHT HAZARD.
 SPRINKLER SYSTEM DESIGN:
 THIS IS A DRY SPRINKLER SYSTEM BEING RECOMMENDED TO MEET NFPA 13 2010Ed. SYSTEM CODES RESPECTING AN NFPA 13 2010Ed. SYSTEM.

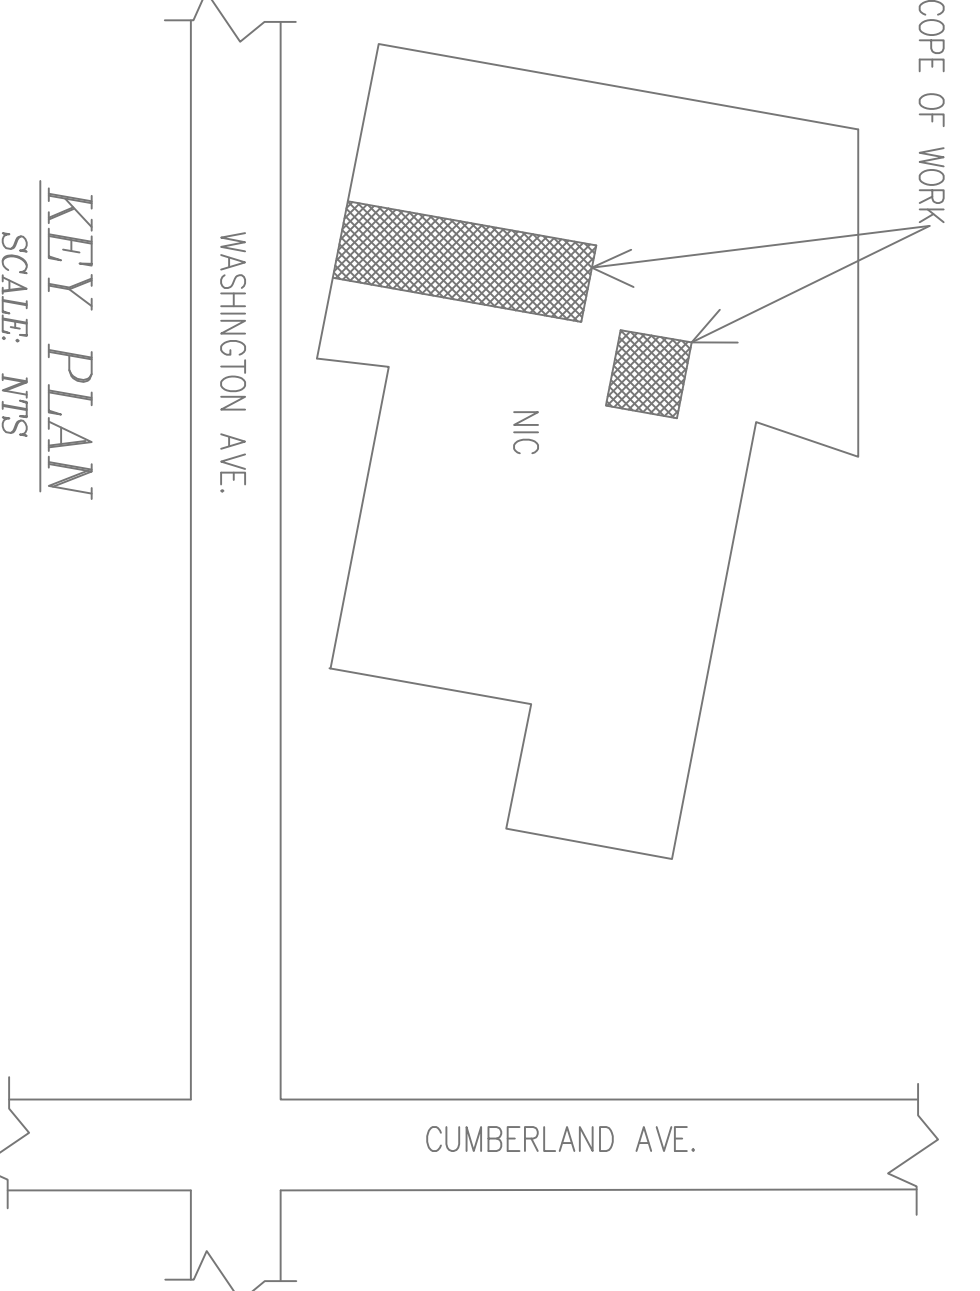

TENANT FIT UP SPACE
 SCALE - 1/4" = 1'-0"
 TOTAL PROTECTED AREA = 3,400 SQ FT

OR APPROVED EQUAL
 TOTAL HEADS ON THIS SHEET: 45
 SCALE:
 1" = 10'-0"
 SCALE: 1/4" = 1'-0"

REVISIONS:
 NO. DATE: DESCRIPTION:
 DATE: JULY 23, 2015
 DESIGNER: ZD DENHILL
 CHECKER: JESSIE FERRELL
 NICET LEVEL: III 129601 RNS8908
 LOCATION:
 ROUSTABOUT RESTAURANT
 75 WASHINGTON AVE
 PORTLAND, ME
 DRAWING TITLE:
 ROUSTABOUT RESTAURANT
 FIRE PROTECTION PLAN
 (NFPA 13 2010Ed.)
 DRAWING NO.:
 FP-01