



HIGH ROOF
LOW ROOF

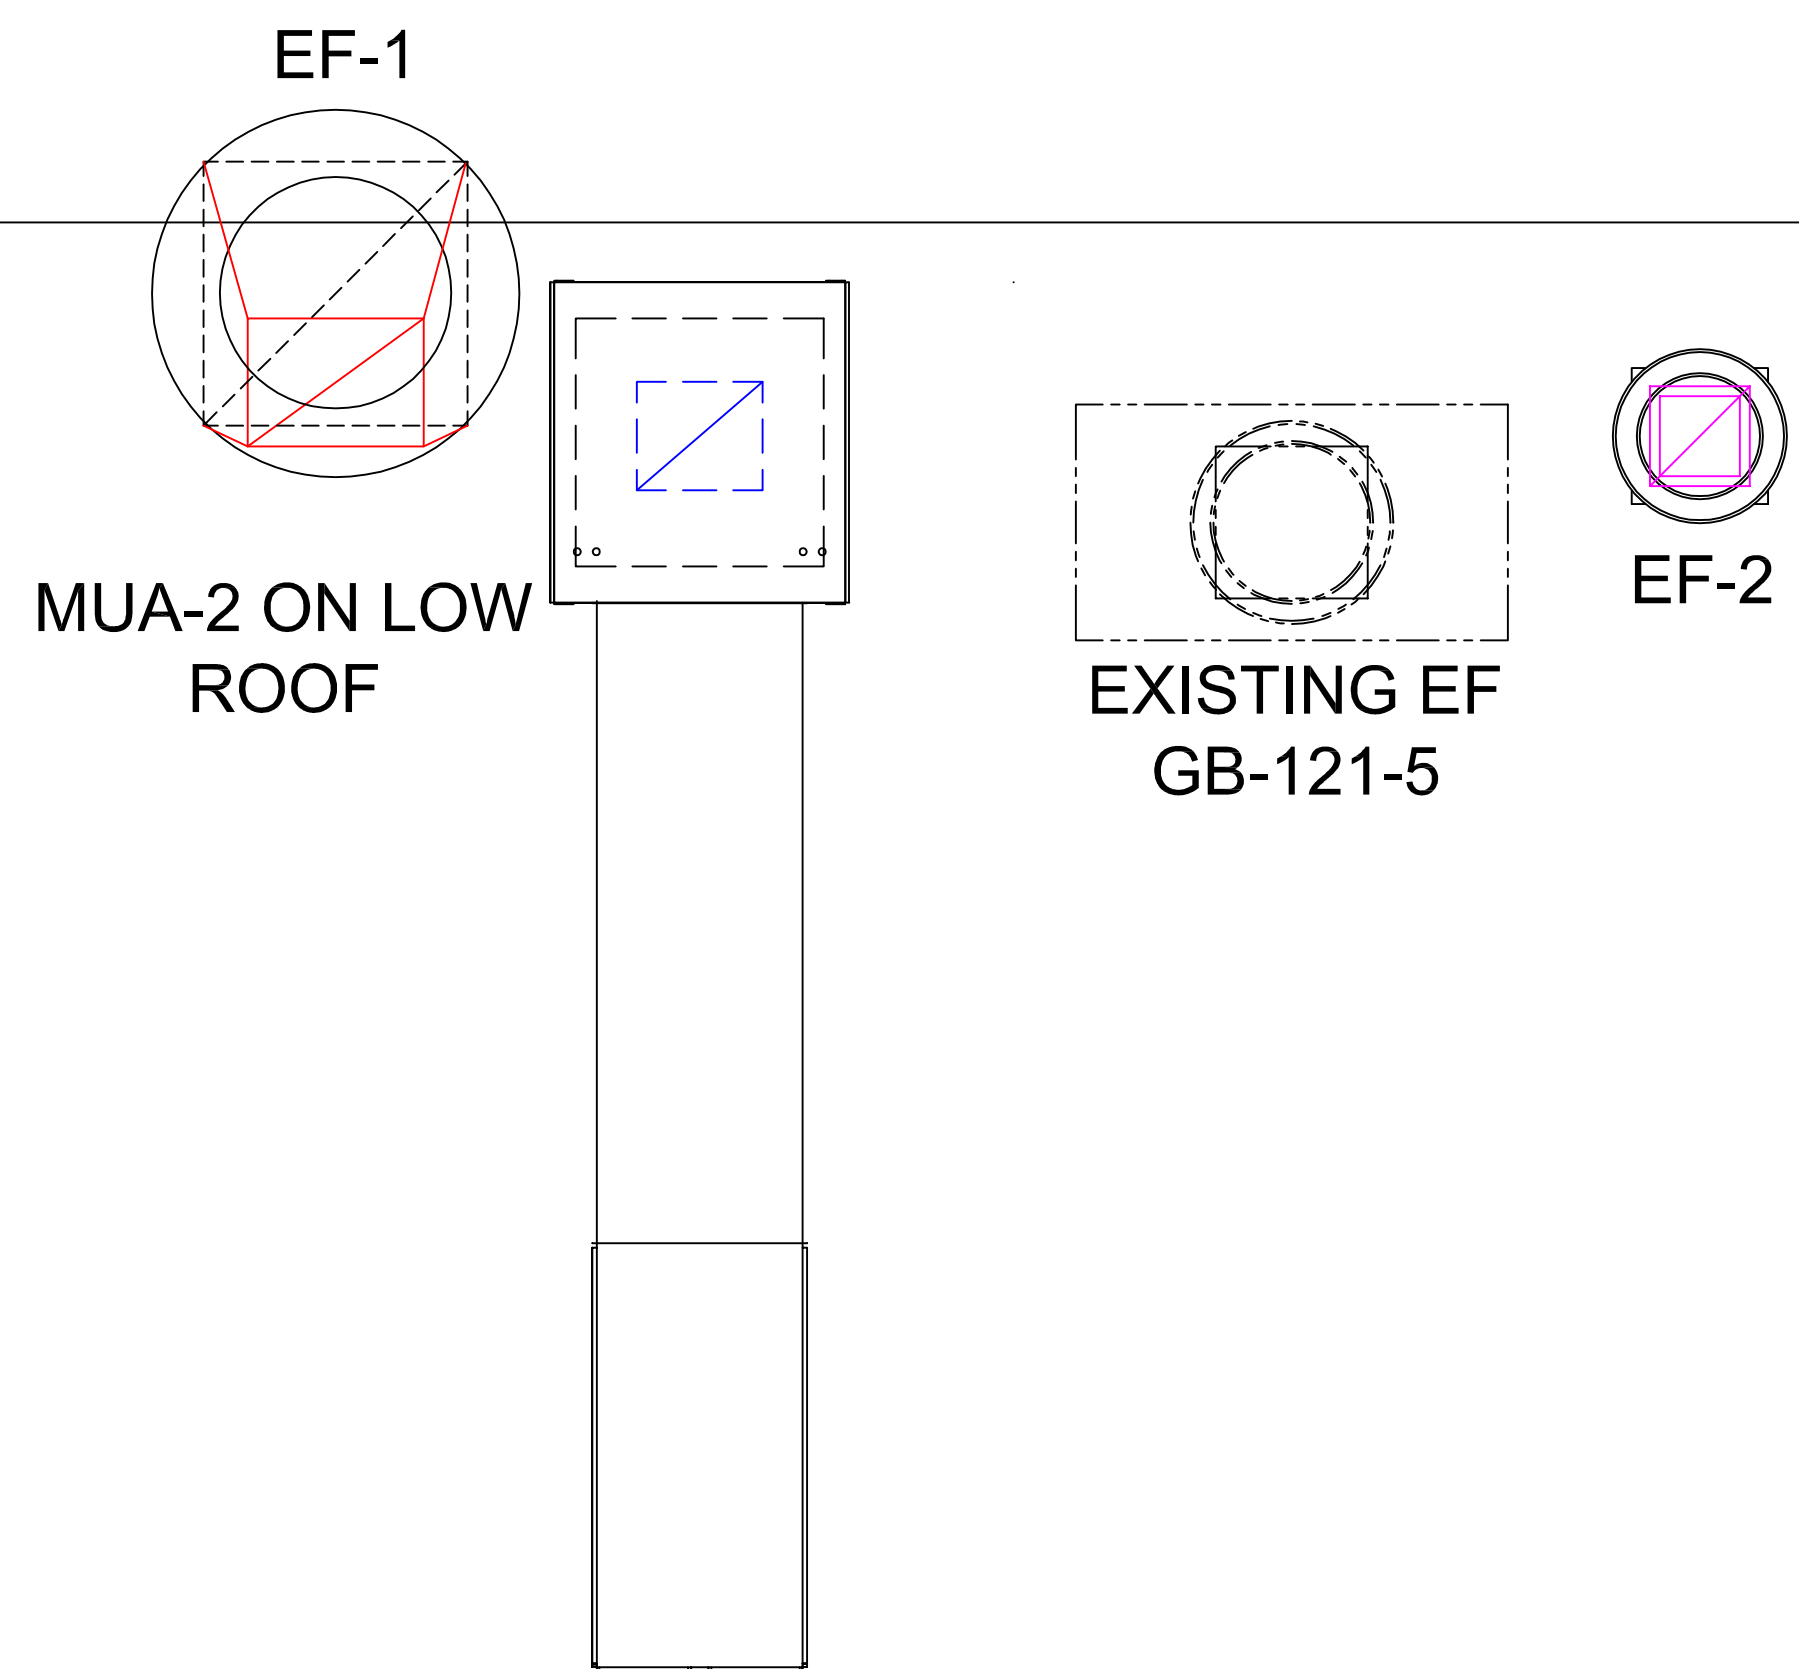


SYMBOLS	
E	EXISTING
CRD	CEILING RADIATION DAMPER
FD	FIRE DAMPER
SWR	SIDEWALL REGISTER
BDP	BOTTOM OF DUCT
AP	DUCT ACCESS PANEL
---	EXISTING DUCT
⊕	CONNECT TO EXISTING

ROOF PART PLAN

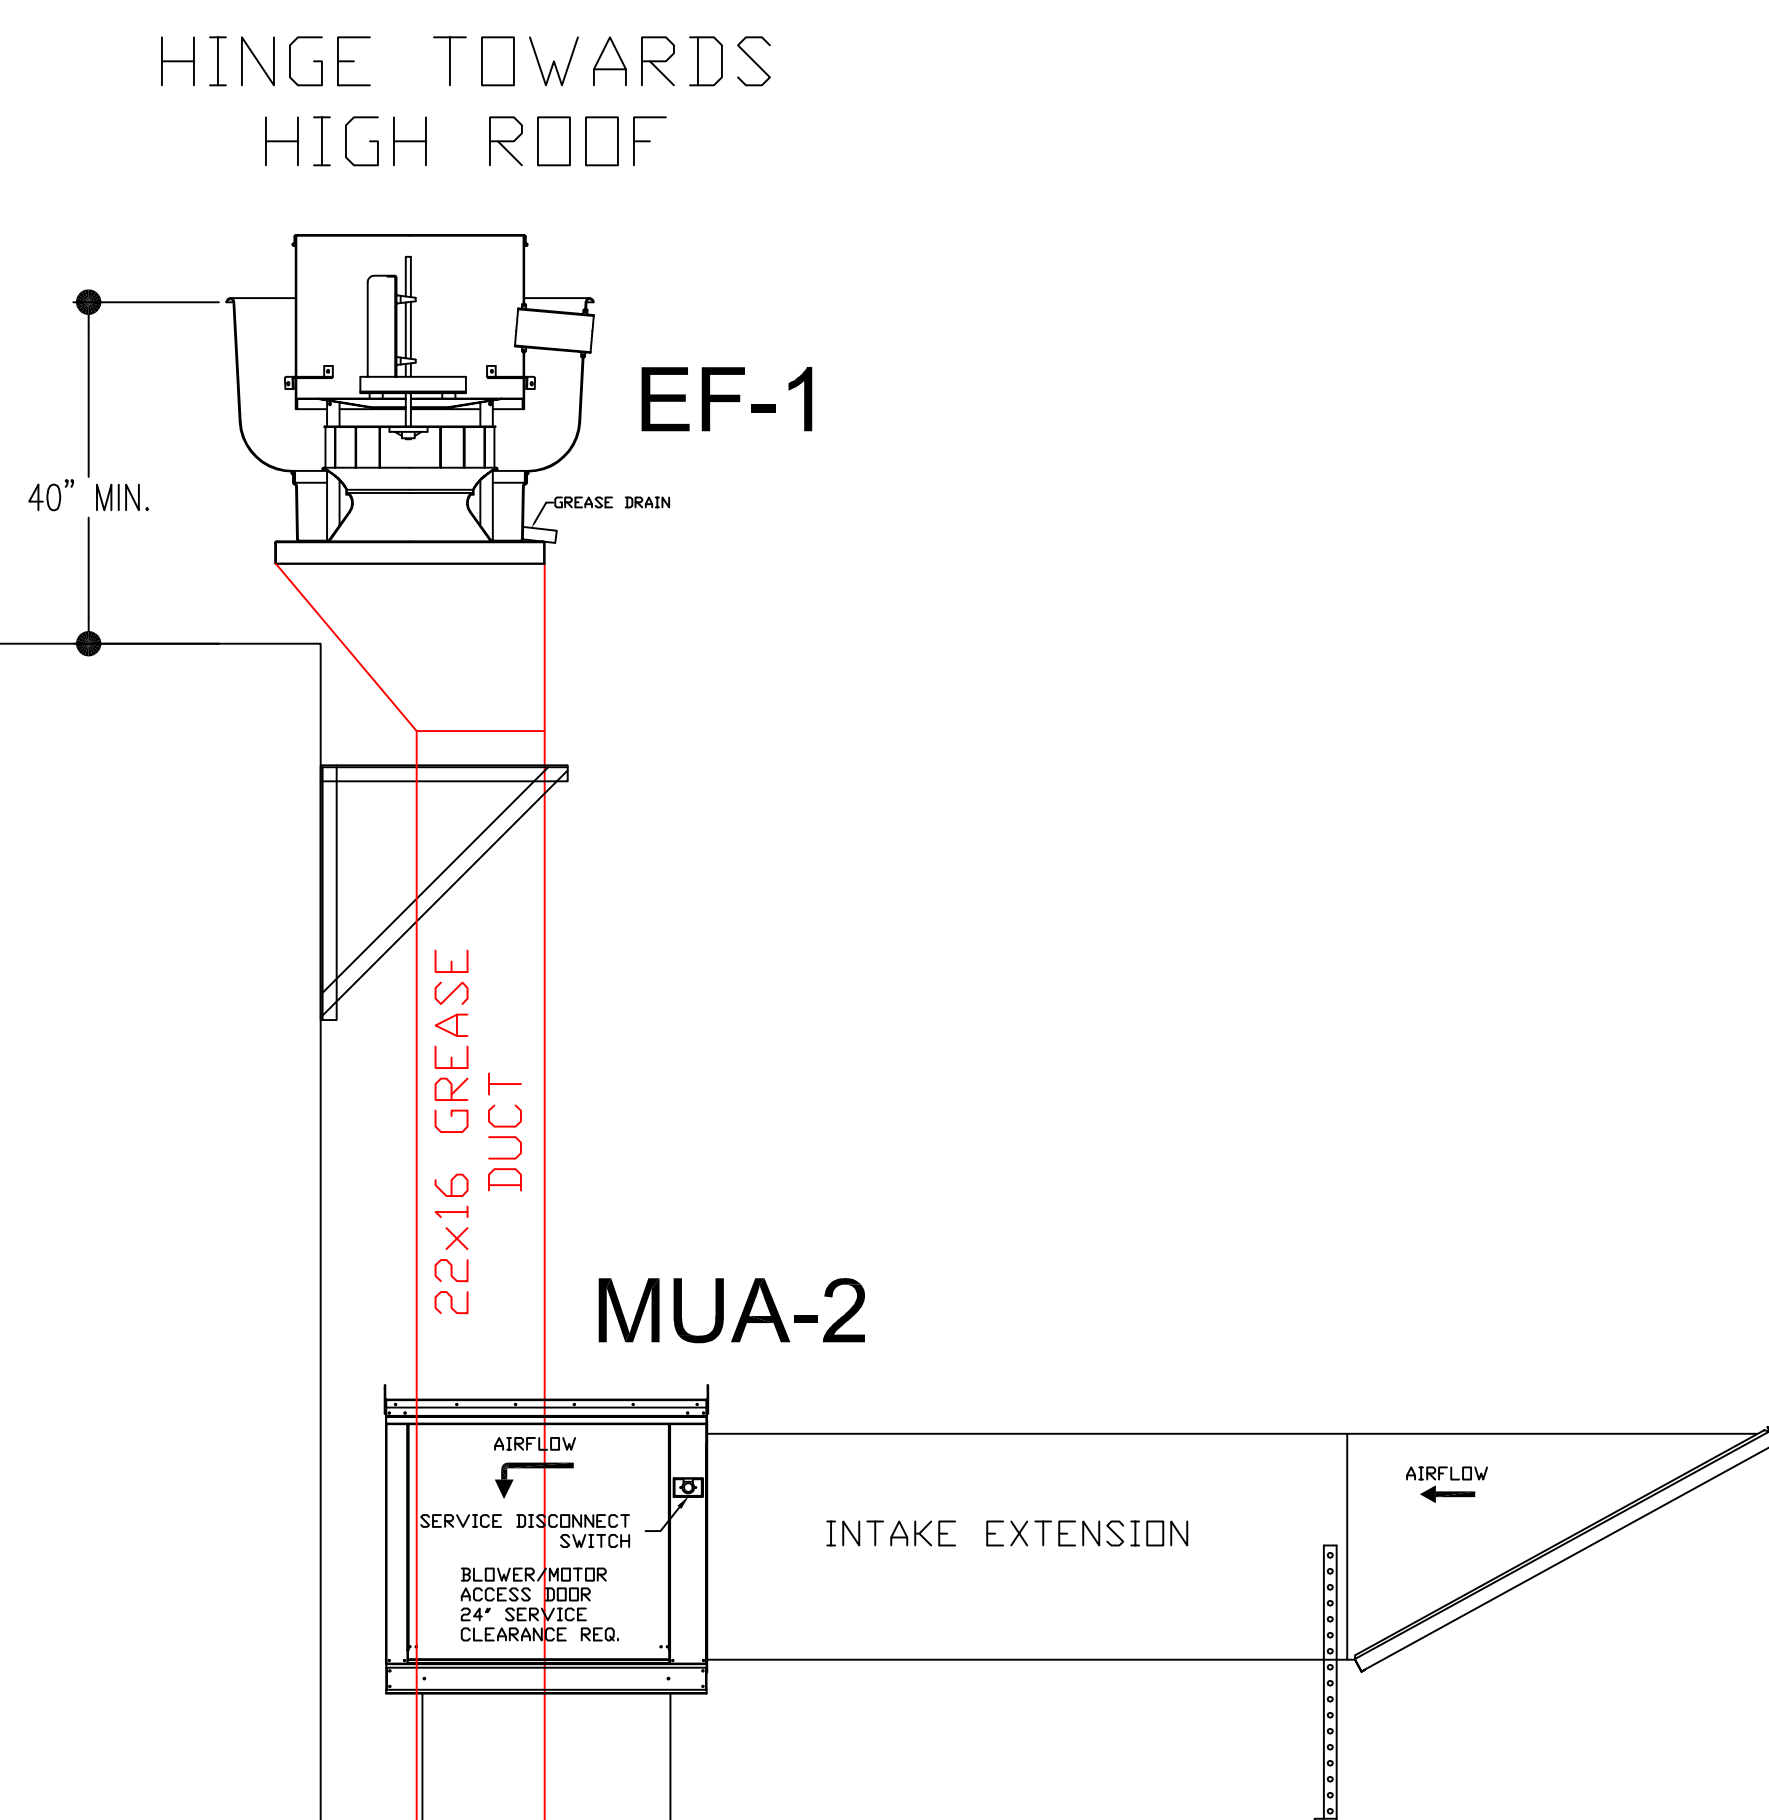


ROOF SIDE ELEVATION

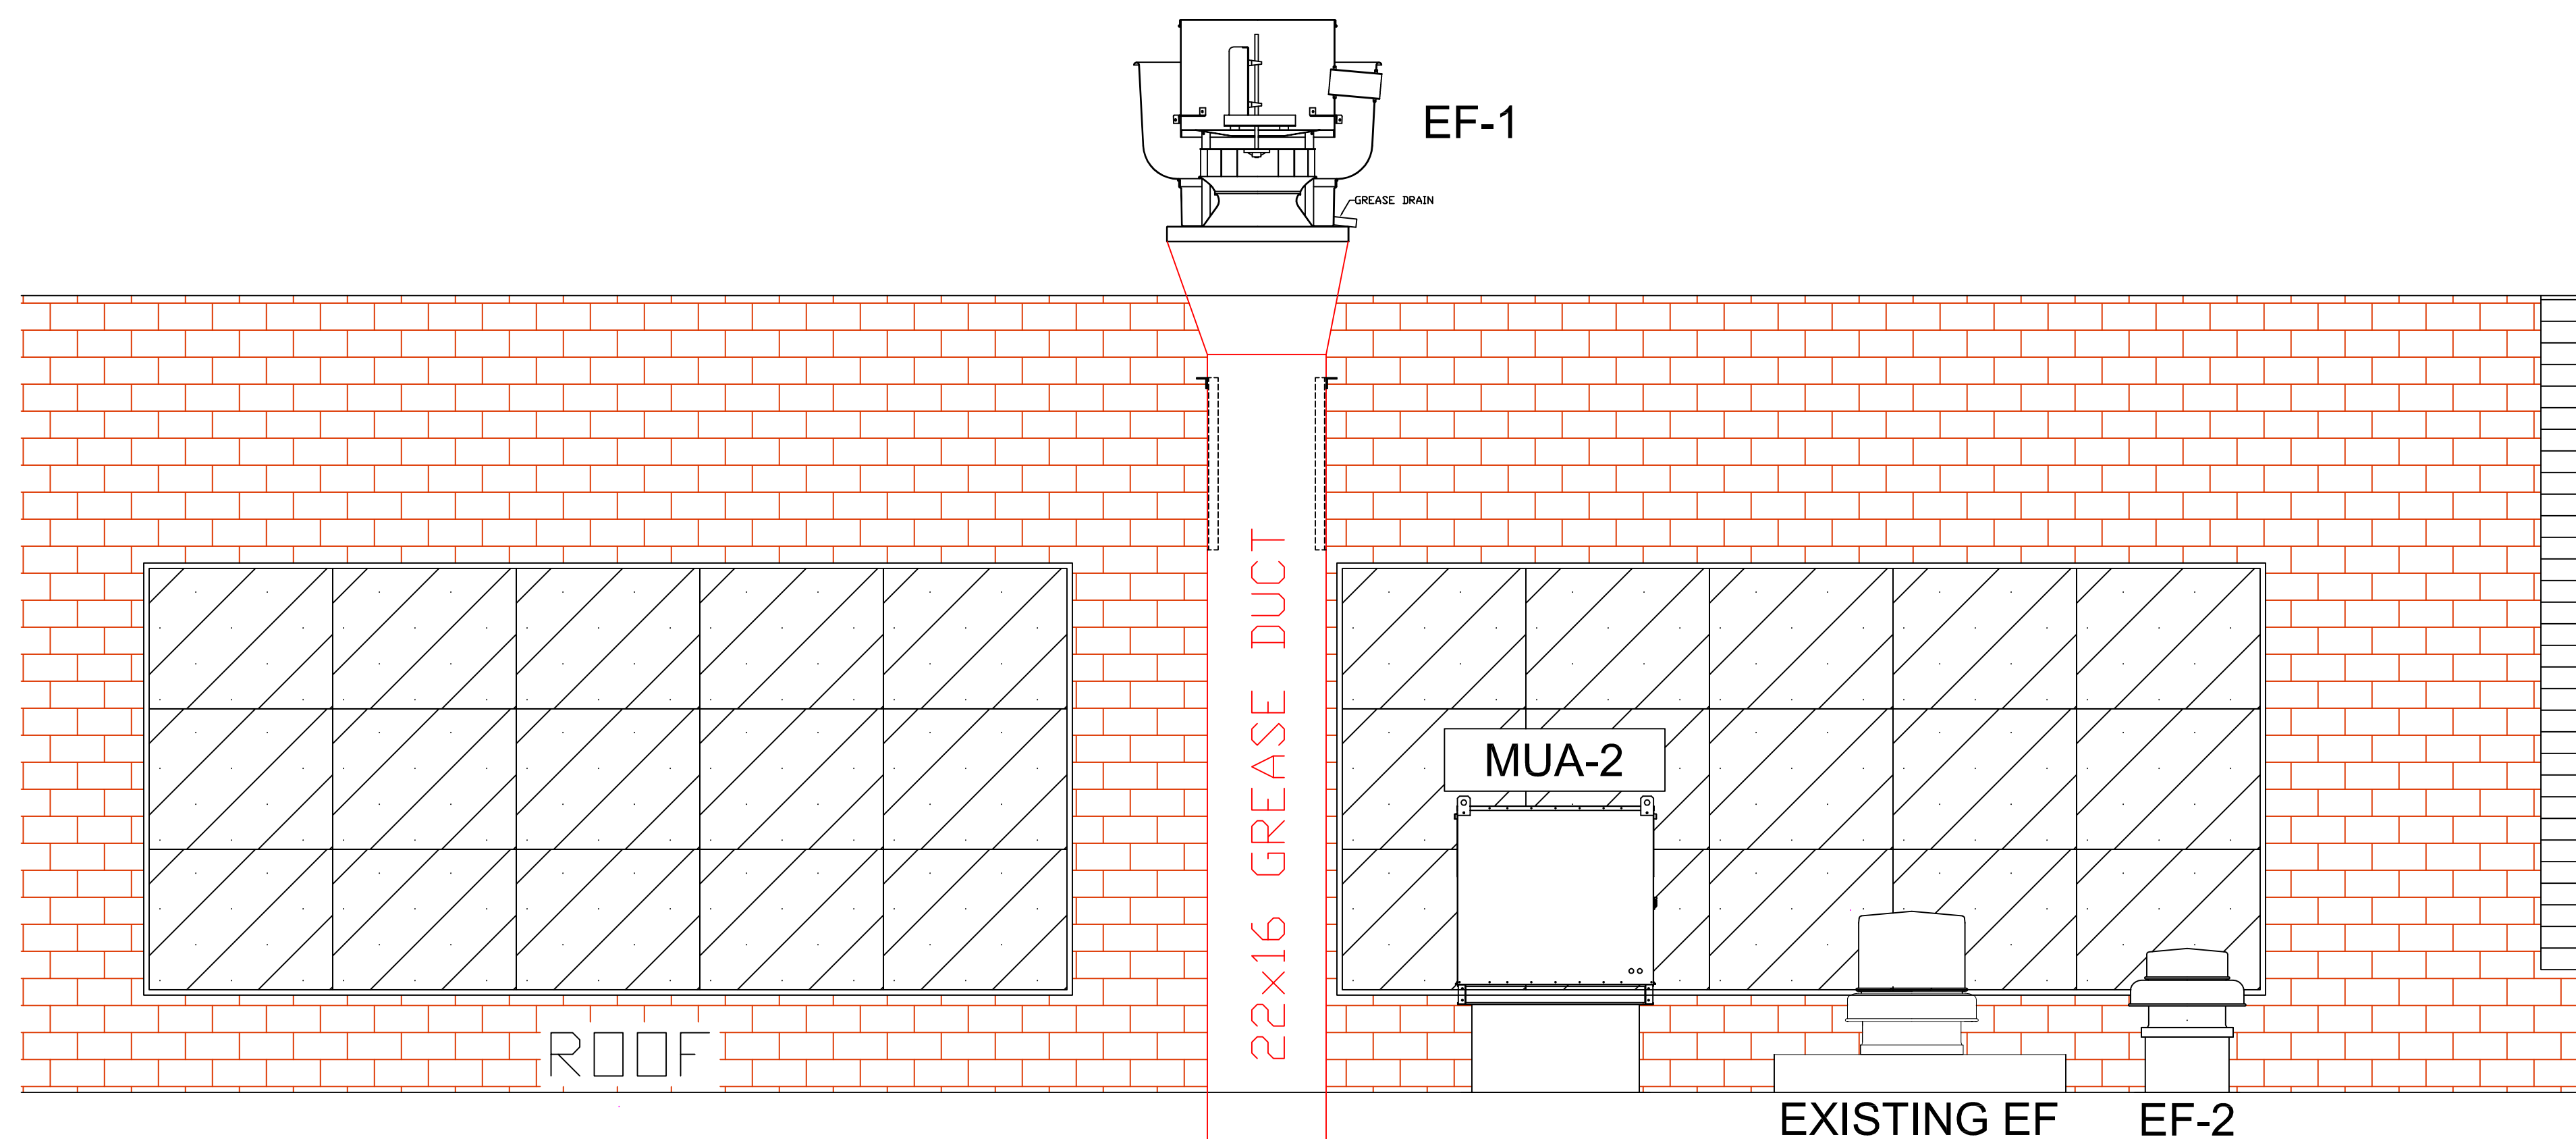

ROOF FRONT ELEVATION

FOR CONSTRUCTION

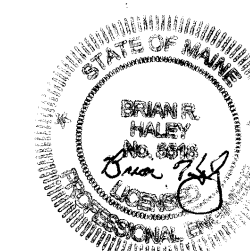

Halley's Metal Shop, Inc.
Since 1917



HALEY'S METAL SHOP, INC.
539 ELM STREET
BIDDEFORD, MAINE 04005
PH: 207-284-8571, FAX: 207-284-9597

DATE: 07/30/15

SCALE: 1/2"=1'-0"

**ROUSTABOUT RESTAURANT
PORTLAND, MAINE
ROOF VENTILATION PLAN**

**HVAC
M-2**