


UNIT FIRE ALARM SEQUENCE NOTES

1. ON BUILDING SYSTEM ACTIVATION ALL AUDIO/VISUAL AND VISUAL ONLY DEVICES SHALL ALARM.
2. WHEN UNIT SMOKE DETECTOR GOES INTO ALARM ALL AUDIO/VISUAL AND VISUAL ONLY DEVICES WITHIN THAT UNIT WILL ACTIVATE. THIS WILL NOT TRIP THE ENTIRE BUILDING SYSTEM. IT WILL ANNUNCIATE AT THE FACP.

NOTES

1. REFER TO ARCHITECTURAL REFLECTED CEILING PLAN FOR LOCATIONS OF ALL FIXTURES.
2. REFER TO DRAWING E21 FOR UNIT AND COMMON SPACE KEYED NOTES.

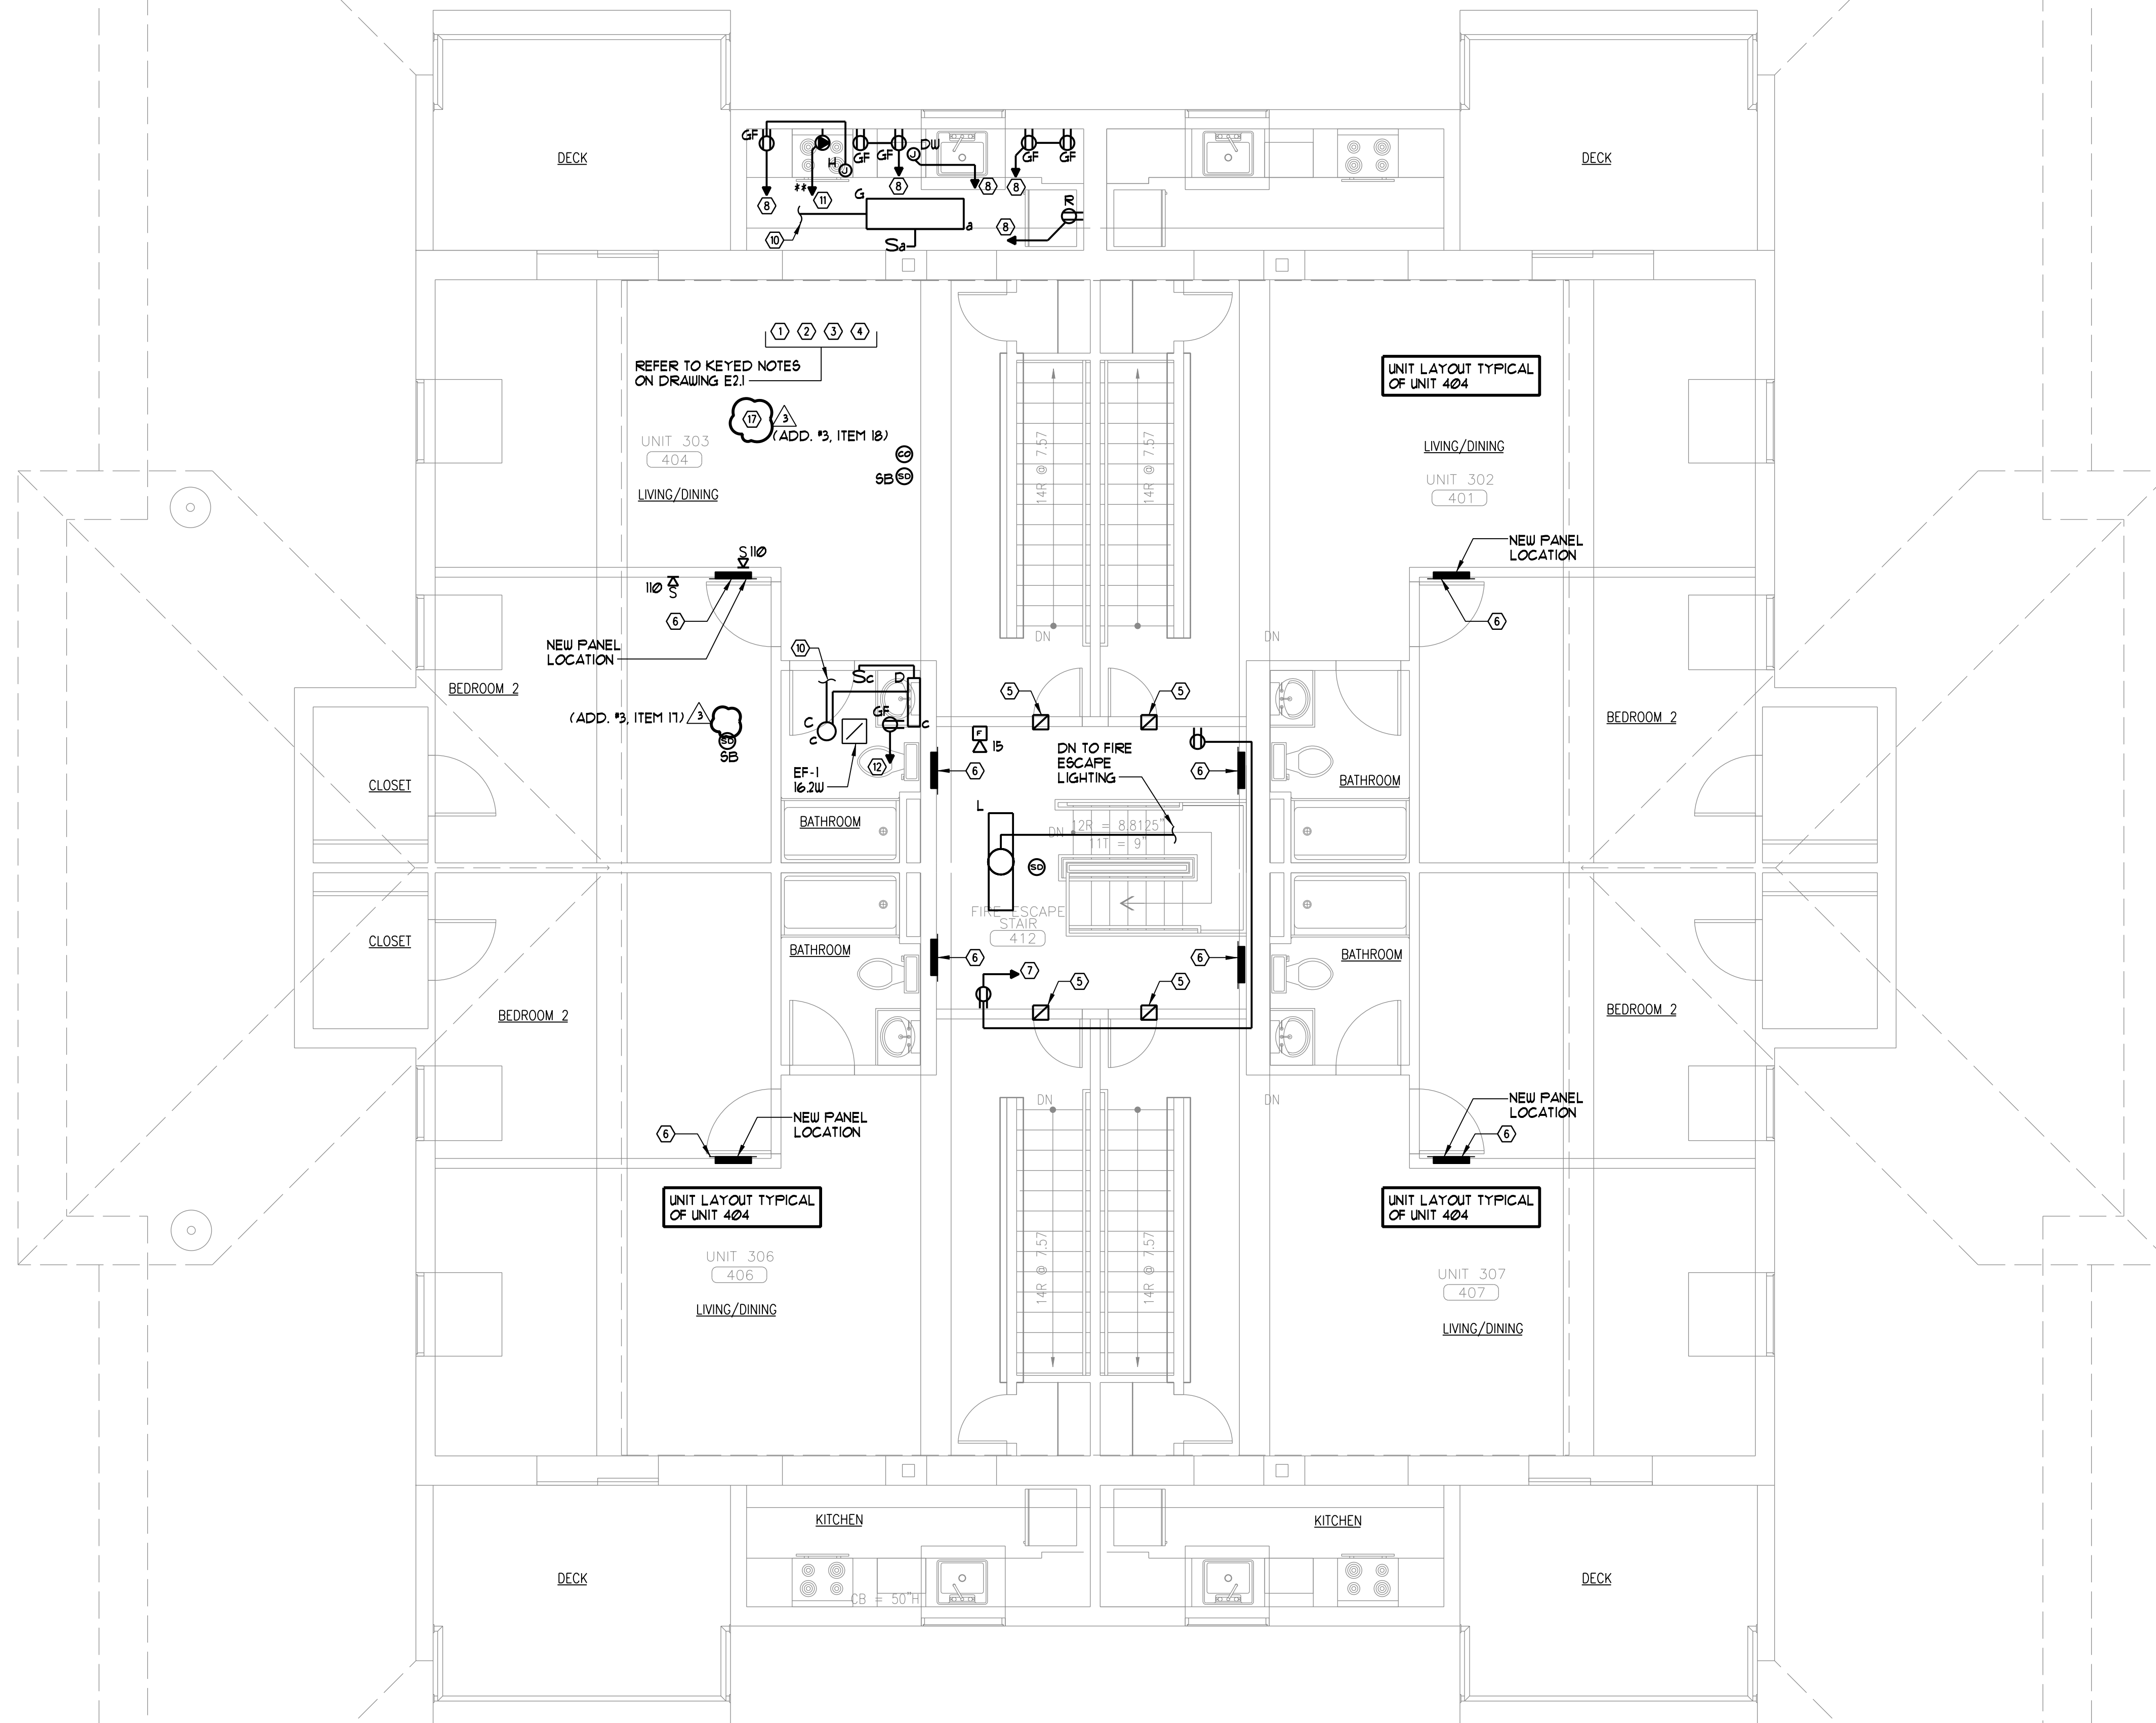

1

FOURTH FLOOR ELECTRICAL PLAN

REFERENCED FROM:

SCALE: 1/4" = 1'-0"





CWS Architects

Architecture
Space Planning
Value Design

434 Cumberland Avenue
Portland, ME 04101
Phone: (207)774-4441
Fax: (207)774-4016

www.CWSarch.com

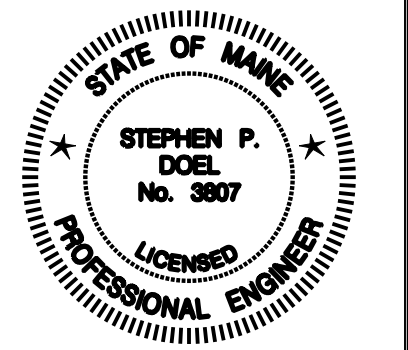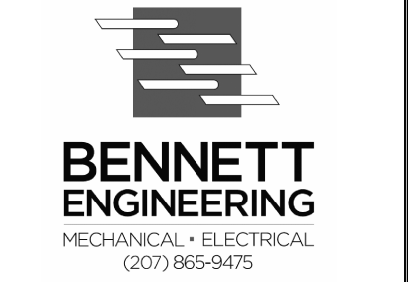

Owner:
**Avesta Munjoy
Commons, LP.**

307 Cumberland Ave.
Portland, Maine 04101
TEL: 207-553-7780

**Munjoy Commons
Apartments**

Portland, Maine

Project No: 07429

Drawing Title:
**EMERSON
FOURTH FLOOR
ELECTRICAL PLAN**

Scale: 1/4" = 1'-0"

Date: August 28, 2009

Revisions:
November 25, 2009
ADDENDUM 01, 02 AND 03

Drawing Number:
**EMERSON
E1.5**