

Owner:
Avesta Munjoy Commons, LP.
307 Cumberland Ave.
Portland, Maine 04101
TEL. 207-553-7780

Client:

Munjoy Commons Apartments

Portland, Maine


Project No: 07429

Drawing Title:
SHAILER ROOF PLAN

Scale: 1/4" = 1'-0"
Date: August 28, 2009

- Revisions:
- △
 - △
 - △
 - △
 - △

Drawing Number:
SHAILER A1.8

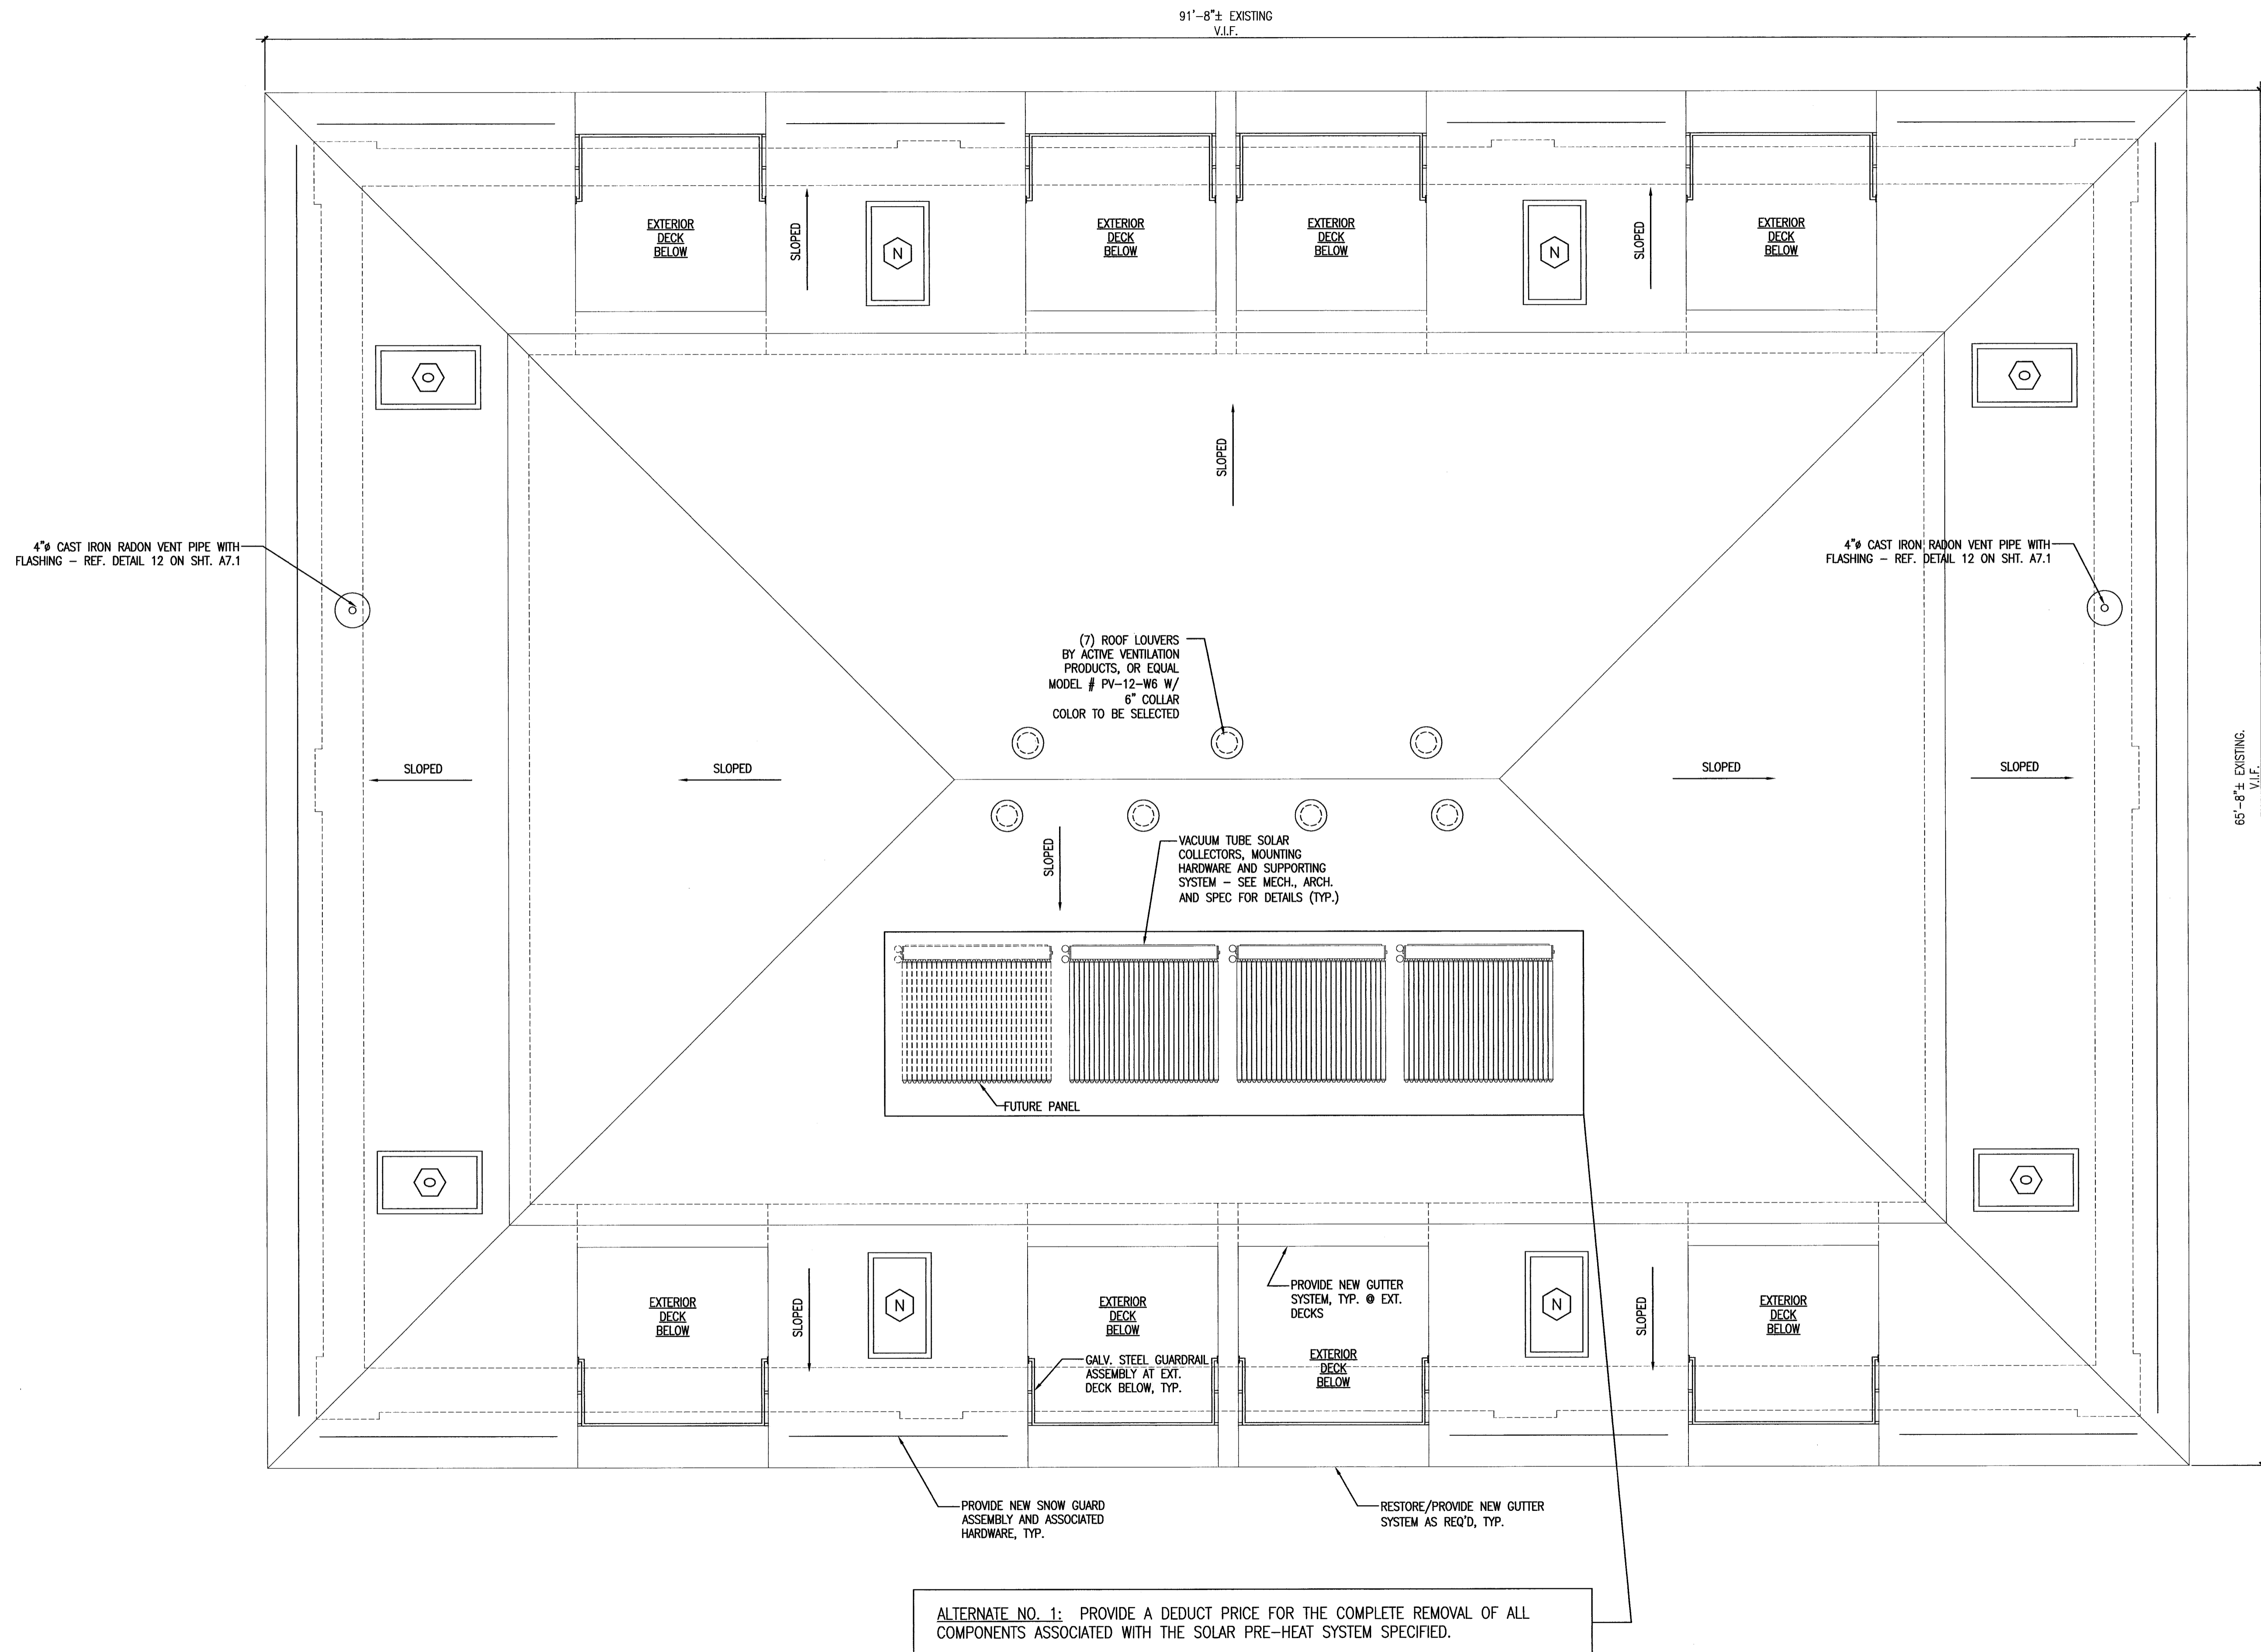

4" CAST IRON RADON VENT PIPE WITH FLASHING - REF. DETAIL 12 ON SHT. A7.1

4" CAST IRON RADON VENT PIPE WITH FLASHING - REF. DETAIL 12 ON SHT. A7.1

(7) ROOF LOUVERS BY ACTIVE VENTILATION PRODUCTS, OR EQUAL MODEL # PV-12-W6 W/ 6" COLLAR COLOR TO BE SELECTED

VACUUM TUBE SOLAR COLLECTORS, MOUNTING HARDWARE AND SUPPORTING SYSTEM - SEE MECH., ARCH. AND SPEC FOR DETAILS (TYP.)

PROVIDE NEW SNOW GUARD ASSEMBLY AND ASSOCIATED HARDWARE, TYP.

RESTORE/PROVIDE NEW GUTTER SYSTEM AS REQ'D, TYP.

ALTERNATE NO. 1: PROVIDE A DEDUCT PRICE FOR THE COMPLETE REMOVAL OF ALL COMPONENTS ASSOCIATED WITH THE SOLAR PRE-HEAT SYSTEM SPECIFIED.

