



PLUMBING NOTES -

- ① EXISTING FIXTURE REPLACED, CONNECT TO EXISTING PLUMBING PIPING.
- ② EXISTING FIXTURE RELOCATED AND REPLACED, CONNECT TO EXISTING PLUMBING PIPING.
- ③ EXISTING WATER HEATER LOCATION, CONNECT TO EXISTING HOT WATER.
- ④ CONNECT NEW FIXTURE TO NEARBY EXISTING PLUMBING PIPING.

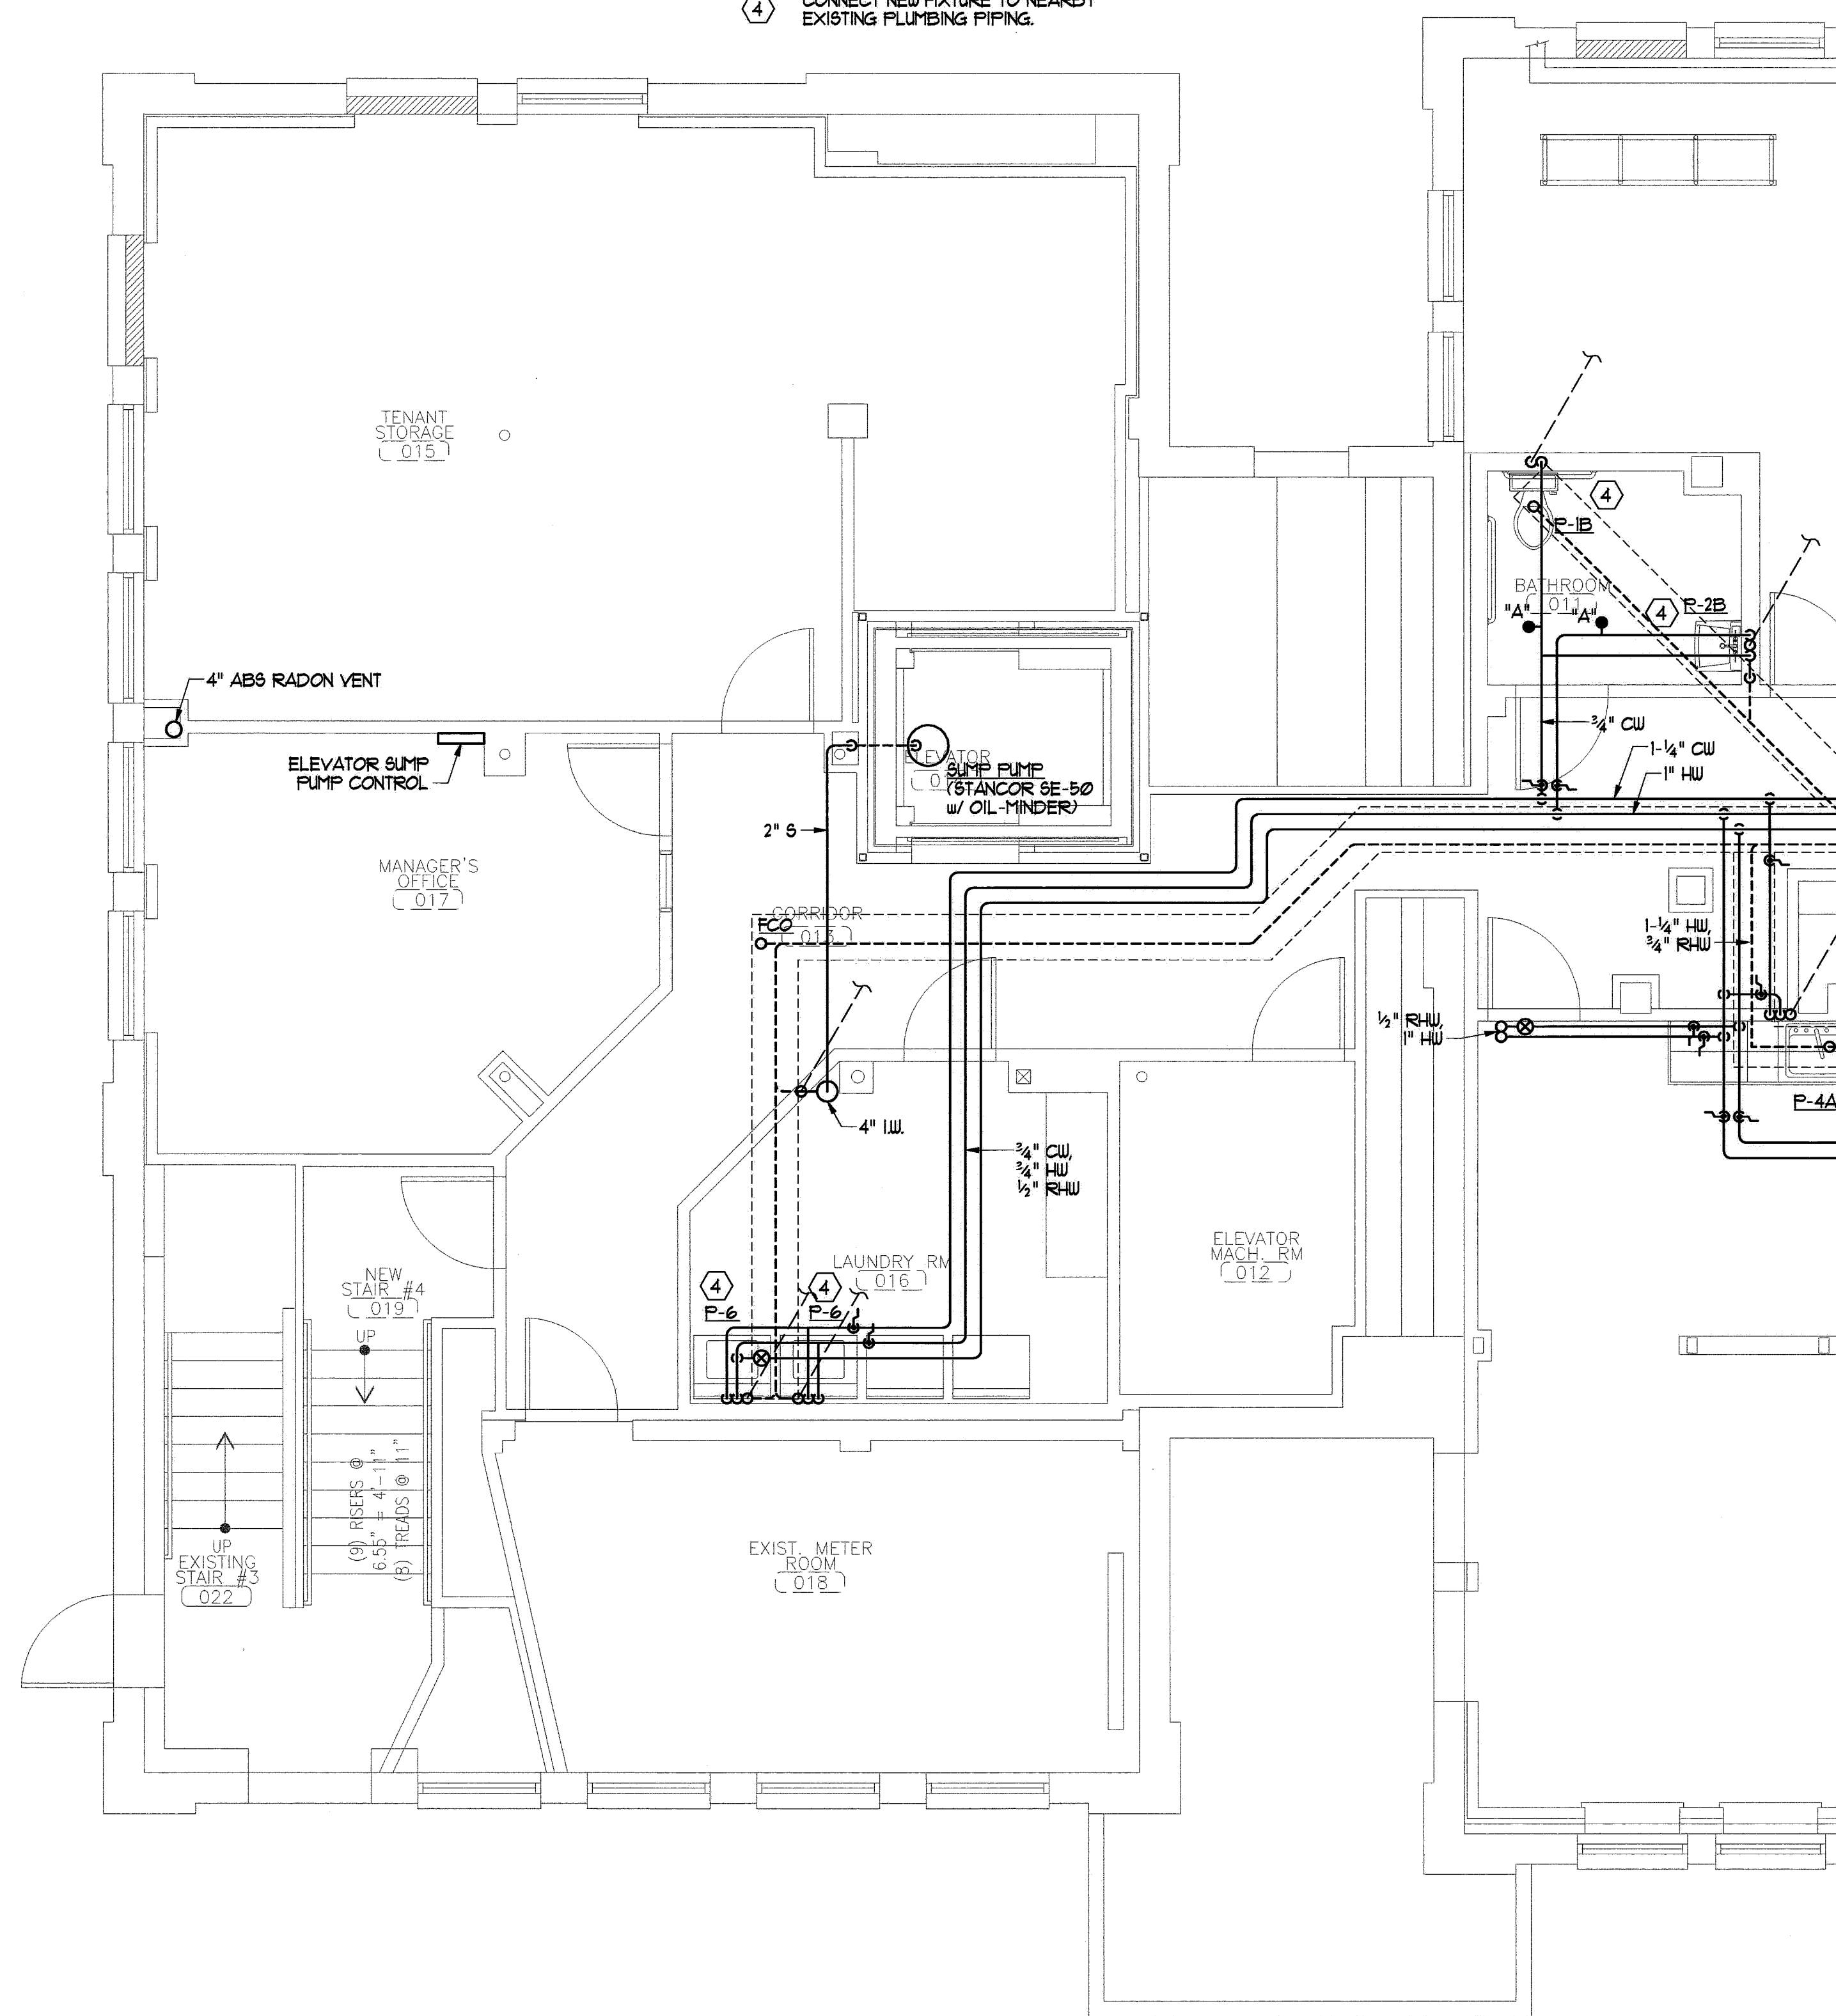

CWS
CWS Architects
Architecture
Space Planning
Value Design
434 Cumberland Avenue
Portland, ME 04101
Phone: (207) 774-4441
Fax: (207) 774-4016
www.CWSarch.com

BENNETT ENGINEERING
MECHANICAL • ELECTRICAL
(207) 865-9475

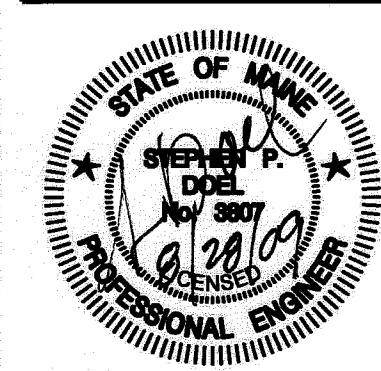

Dweller:
Avesta Munjoy Commons, LP.
307 Cumberland Ave.
Portland, Maine 04101
TEL. 207-553-7780

Munjoy Commons Apartments
Portland, Maine

Project No: 07429

Drawing Title:
SHAILER ANNEX BASEMENT PLUMBING PLAN

Scale: 1/4" = 1'-0"
Date: August 28, 2009

- Revisions:
- △
 - △
 - △
 - △
 - △

Drawing Number:
SHAILER M2.2